

CONCEPTUAL FLOOR PLAN PACKAGE

BOISE SSC NEW BUILDING

3001 W Harvard Street
Boise, Idaho 83705

(Google Maps Coordinates: 43.556183, -116.218832)

July 2021



Prepared for:

DEPARTMENT OF TRANSPORTATION
FEDERAL AVIATION ADMINISTRATION
800 Independence Avenue, S.W.
Washington, DC 20591



Prepared by:

PARSONS

PTSI Managed Service Inc.
955 L'Enfant Plaza SW, Ste: 6100 North
Washington, DC 20024
COA# 24GA28271400

THIS PAGE INTENTIONALLY BLANK

TABLE OF CONTENTS

SPECIFICATIONS

COVER PAGE

DRAWING INDEX

BOI-C-SSC-A001

<No Drawing Number>

BOI-D-SSC-E001

BOI-D-SSC-E001

NEW FLOOR PLAN

BOISE SSC NEW BUILDING – SITE PLAN


NEW POWER PLAN

NEW LIGHTING PLAN

TABLE OF CONTENTS

THIS PAGE INTENTIONALLY BLANK

C:\PROJ\3525-BOISE\BOI-SSC-A-PP05.DWG XREFS:
 SHEET_BOI-C-SSC-A001 - JUL 07, 2021 - 10:53 A. FATAH

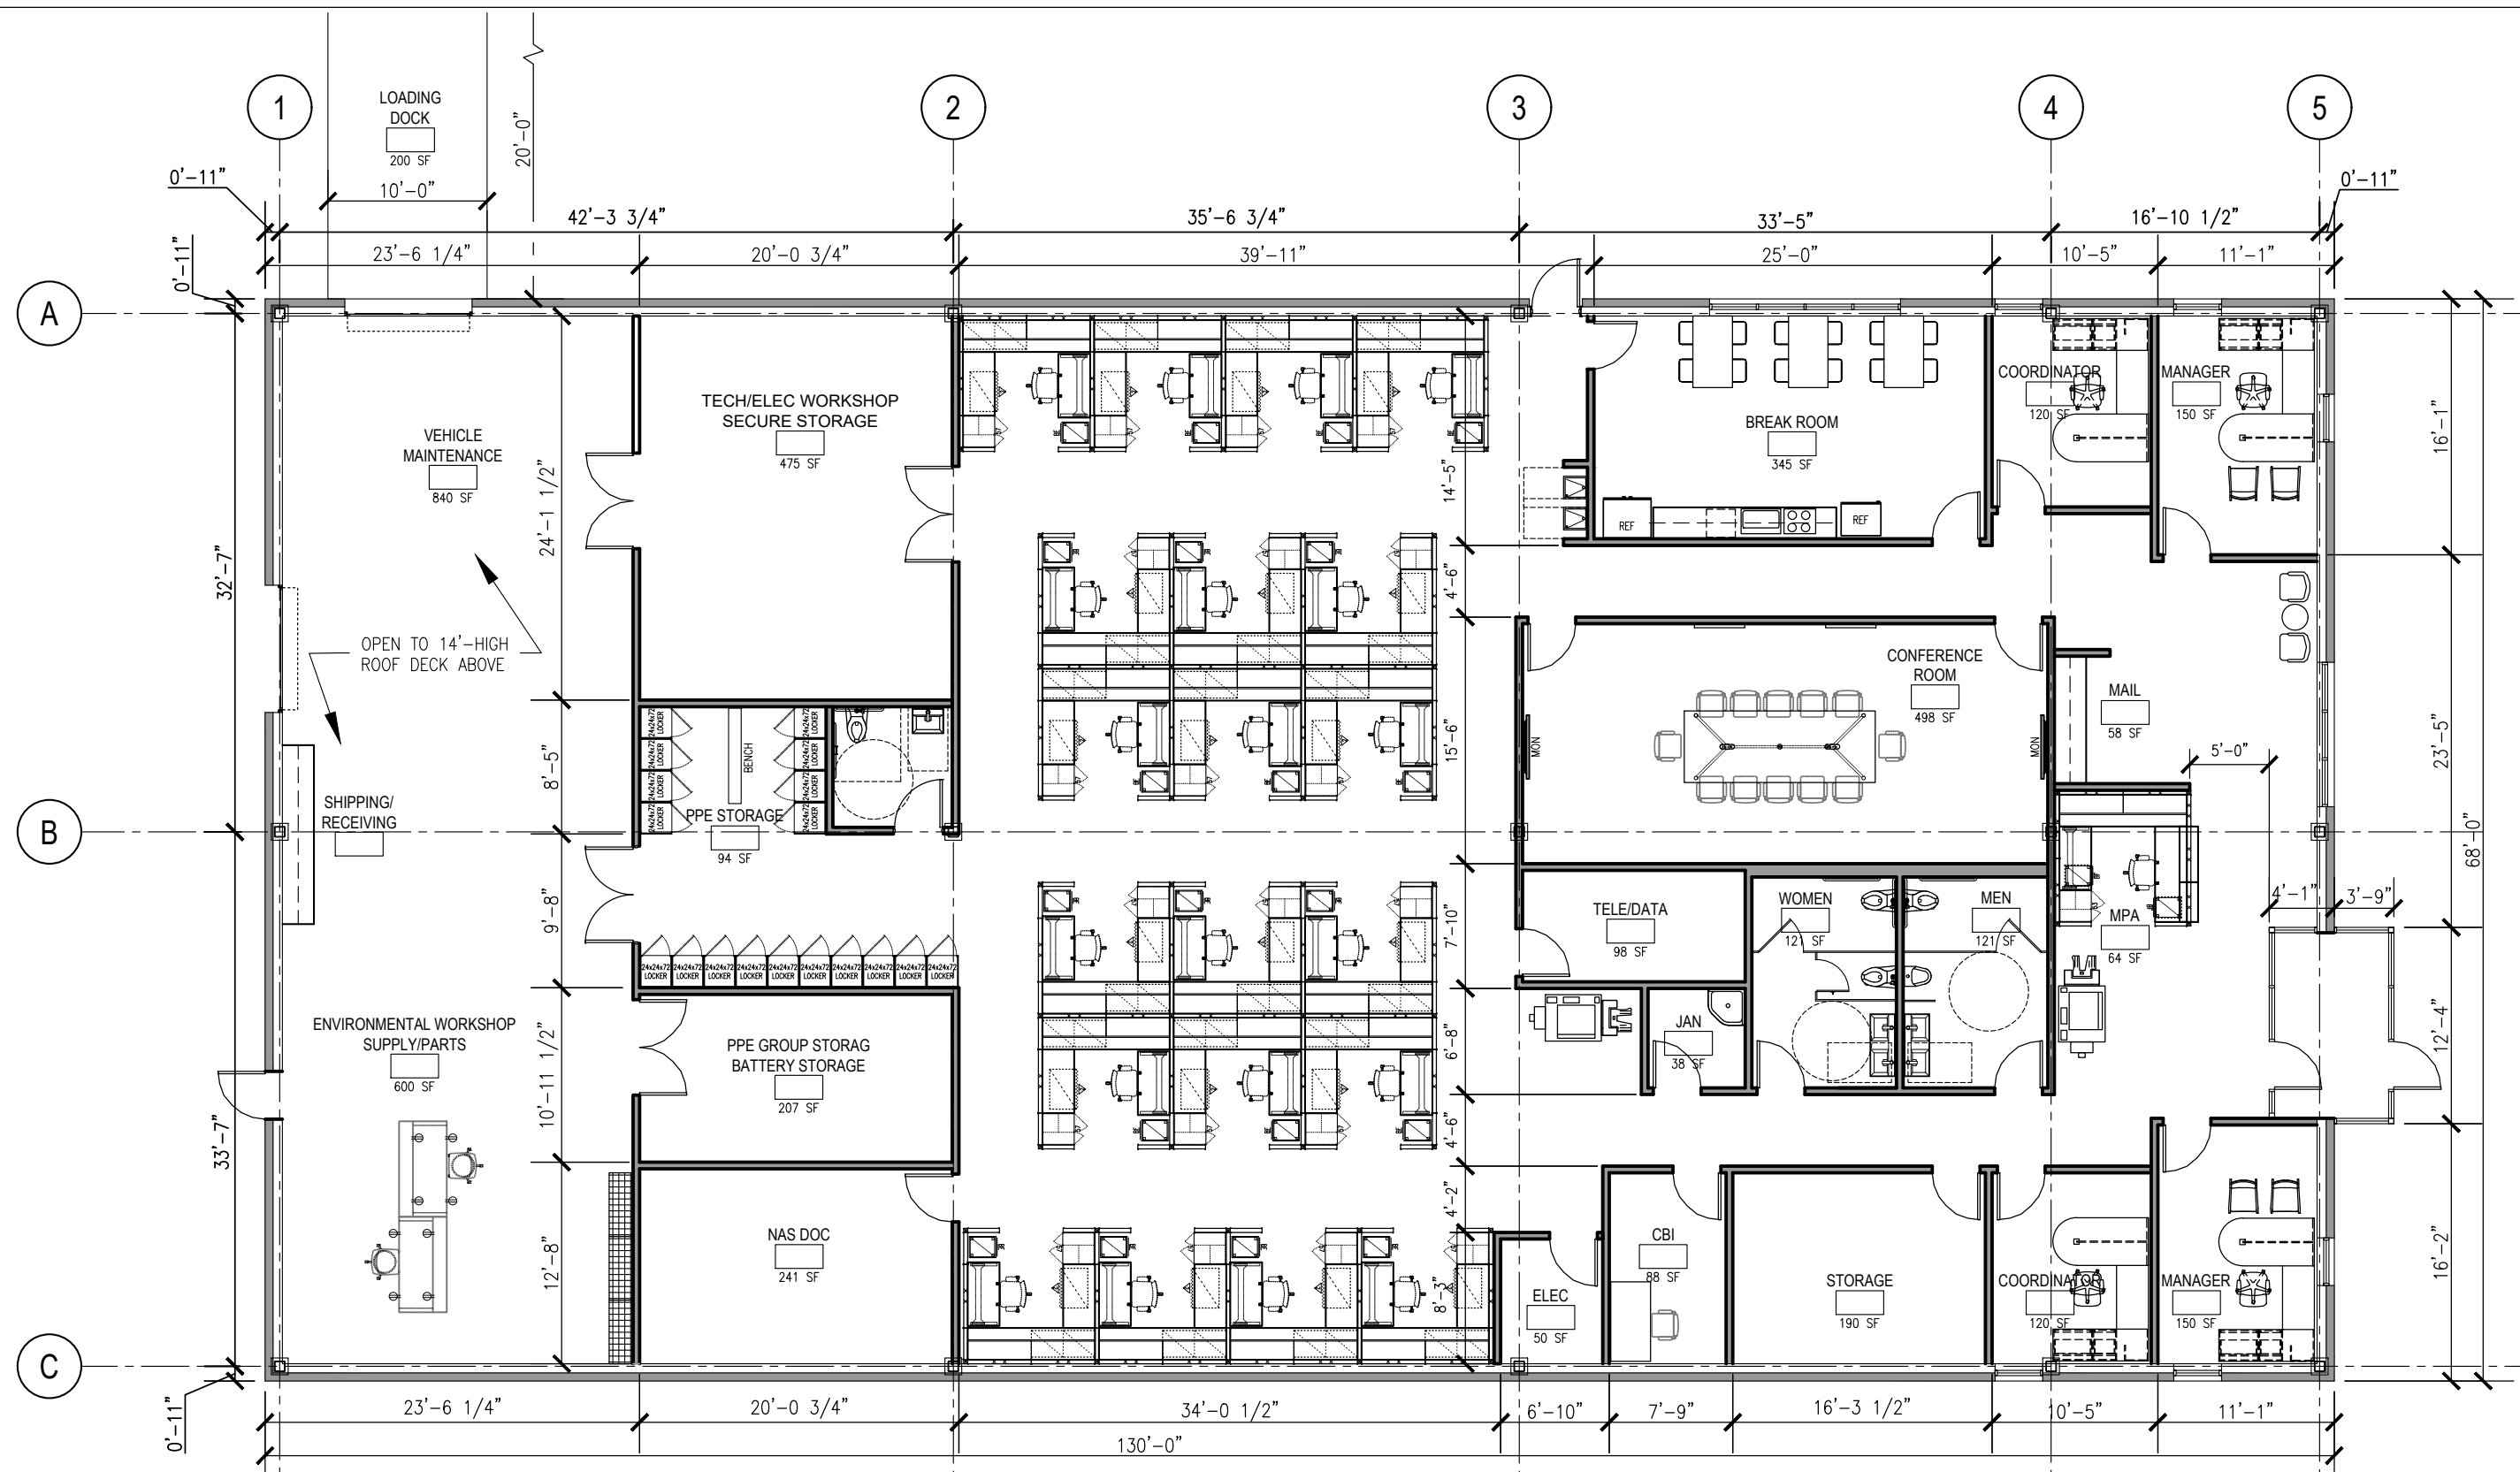

NOTES:

- TOTAL BUILDING AREA = 8,885 SF.
- BUILDING IS LOCATED IN SEISMIC ZONE 2B.
- BUILDING OUTER ENVELOPE IS 4" THK. INSULATED METAL PANELS.
- ALL SPACES HAVE 9' HIGH SUSPENDED CEILING EXCEPT FOR VEHICLE MAINTENANCE, ENVIRONMENTAL SHOP, AND SUPPLY PARTS AREAS, THEY ARE OPEN TO 14' HIGH ROOF DECK ABOVE.

- NO SPRINKLER FIRE SUPPRESSION SYSTEM.
- STRUCTURAL STEEL TUBE COLUMNS, WF GIRDERS, AND OPEN WEB BAR JOISTS WITH RIGID CONNECTIONS FOR ALL STRUCTURAL ELEMENTS.

PARSONS
 PTSI MANAGED SERVICES INC.
 955 L'ENFANT PLAZA NORTH, SW,
 SUITE 6100
 WASHINGTON, DC 20024

RELEASED: FOR REVIEW, NOT FOR CONSTRUCTION

PROJECT: DEPARTMENT OF TRANSPORTATION
 FEDERAL AVIATION ADMINISTRATION

SHEET TITLE: BOISE, IDAHO SSC - TENANTS RELOCATION
 NEW FLOOR PLAN


SHEET NUMBER: BOI-C-SSC-A001

SCALE: 3/32" = 1'-0"

DATE: 06/18/2021

CAD FILE/XREF(S): BOI-SSC-A-PP05

REVISION: 0

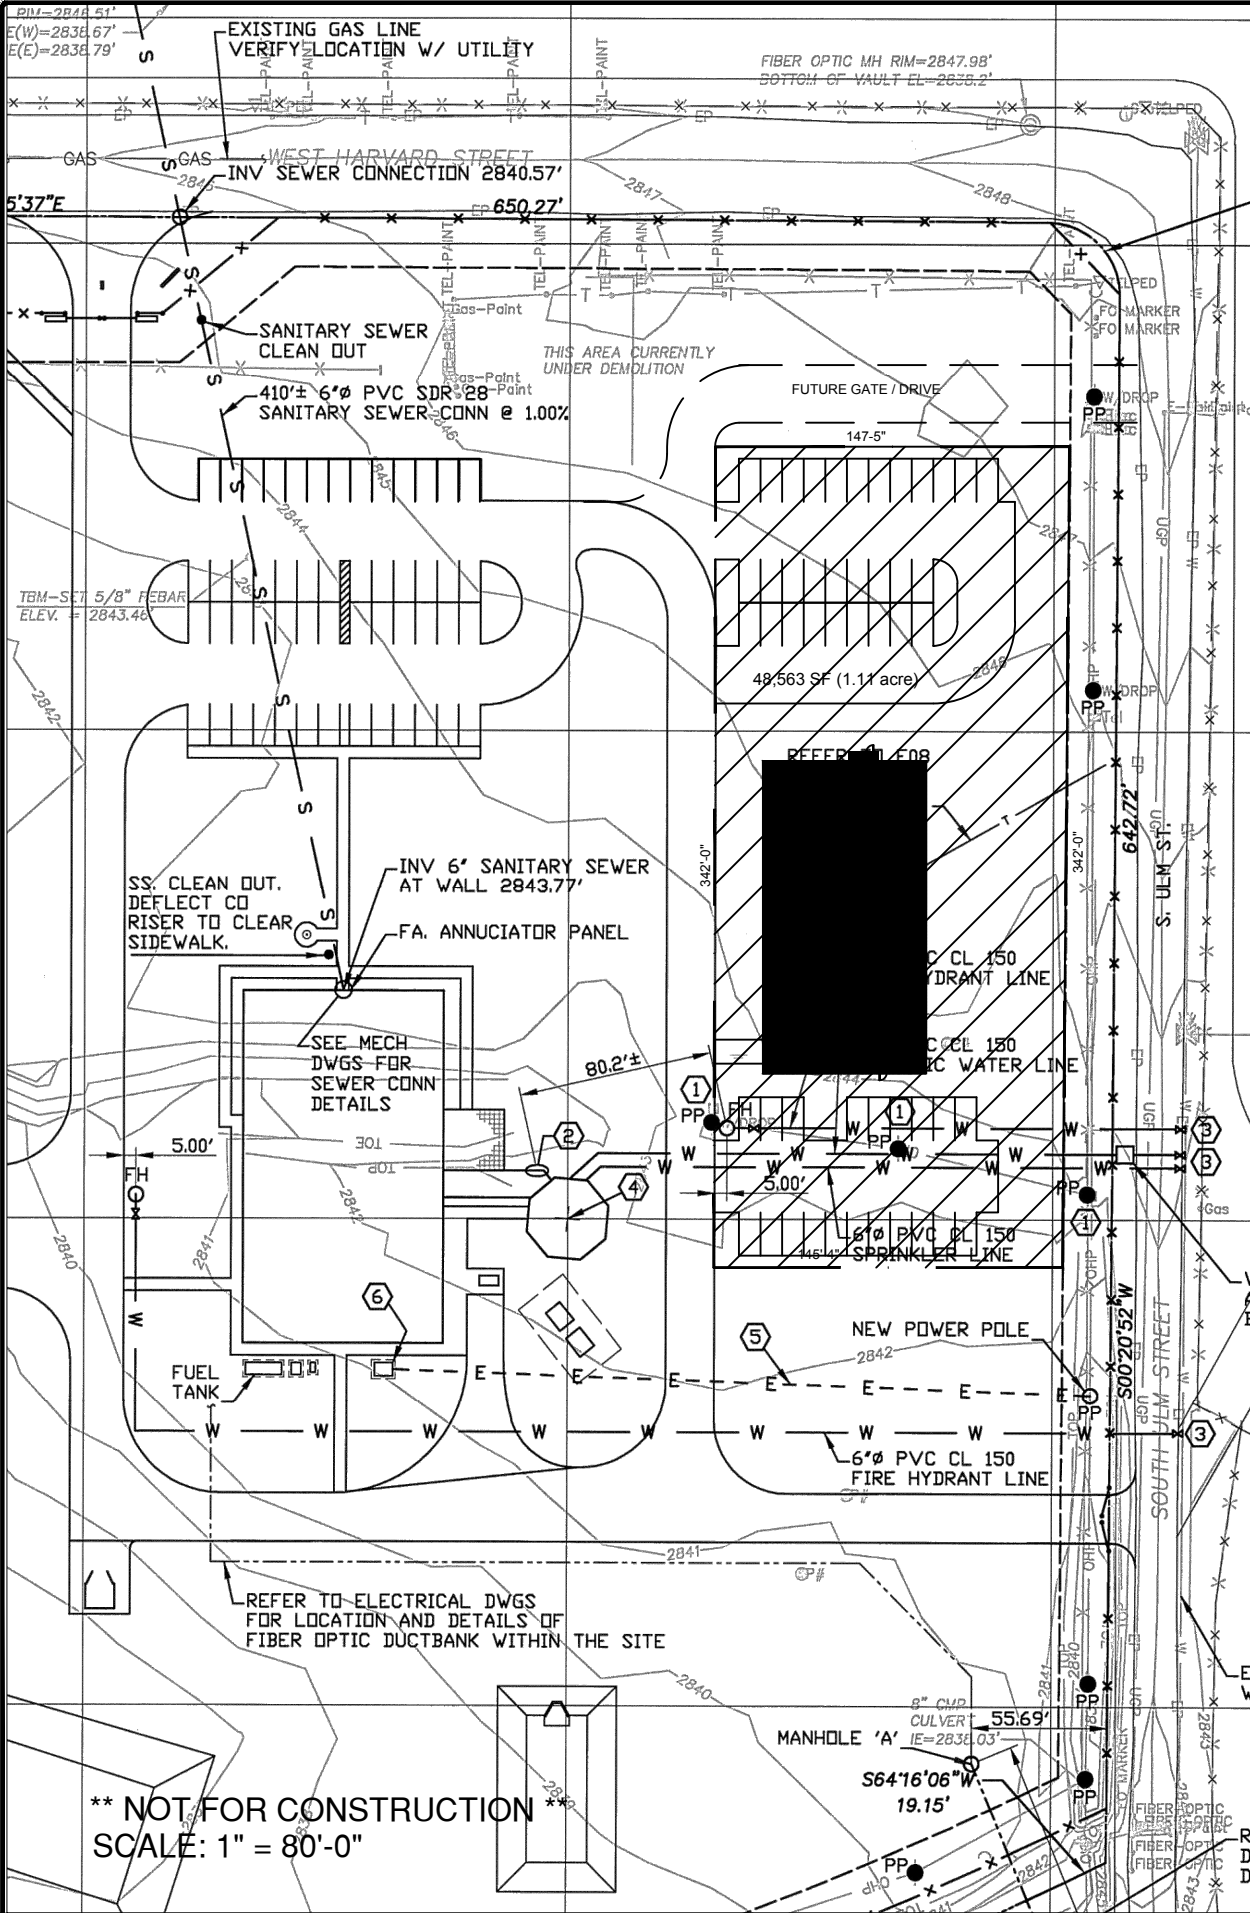

PROJECT	SHEET	DATE
		04.13.21


**BOISE SSC
 NEW BUILDING**
 BOISE, IDAHO

50,063 SQ. FT.
 (1.15 ACRES)

SITE PLAN



**** NOT FOR CONSTRUCTION ****
 SCALE: 1" = 80'-0"

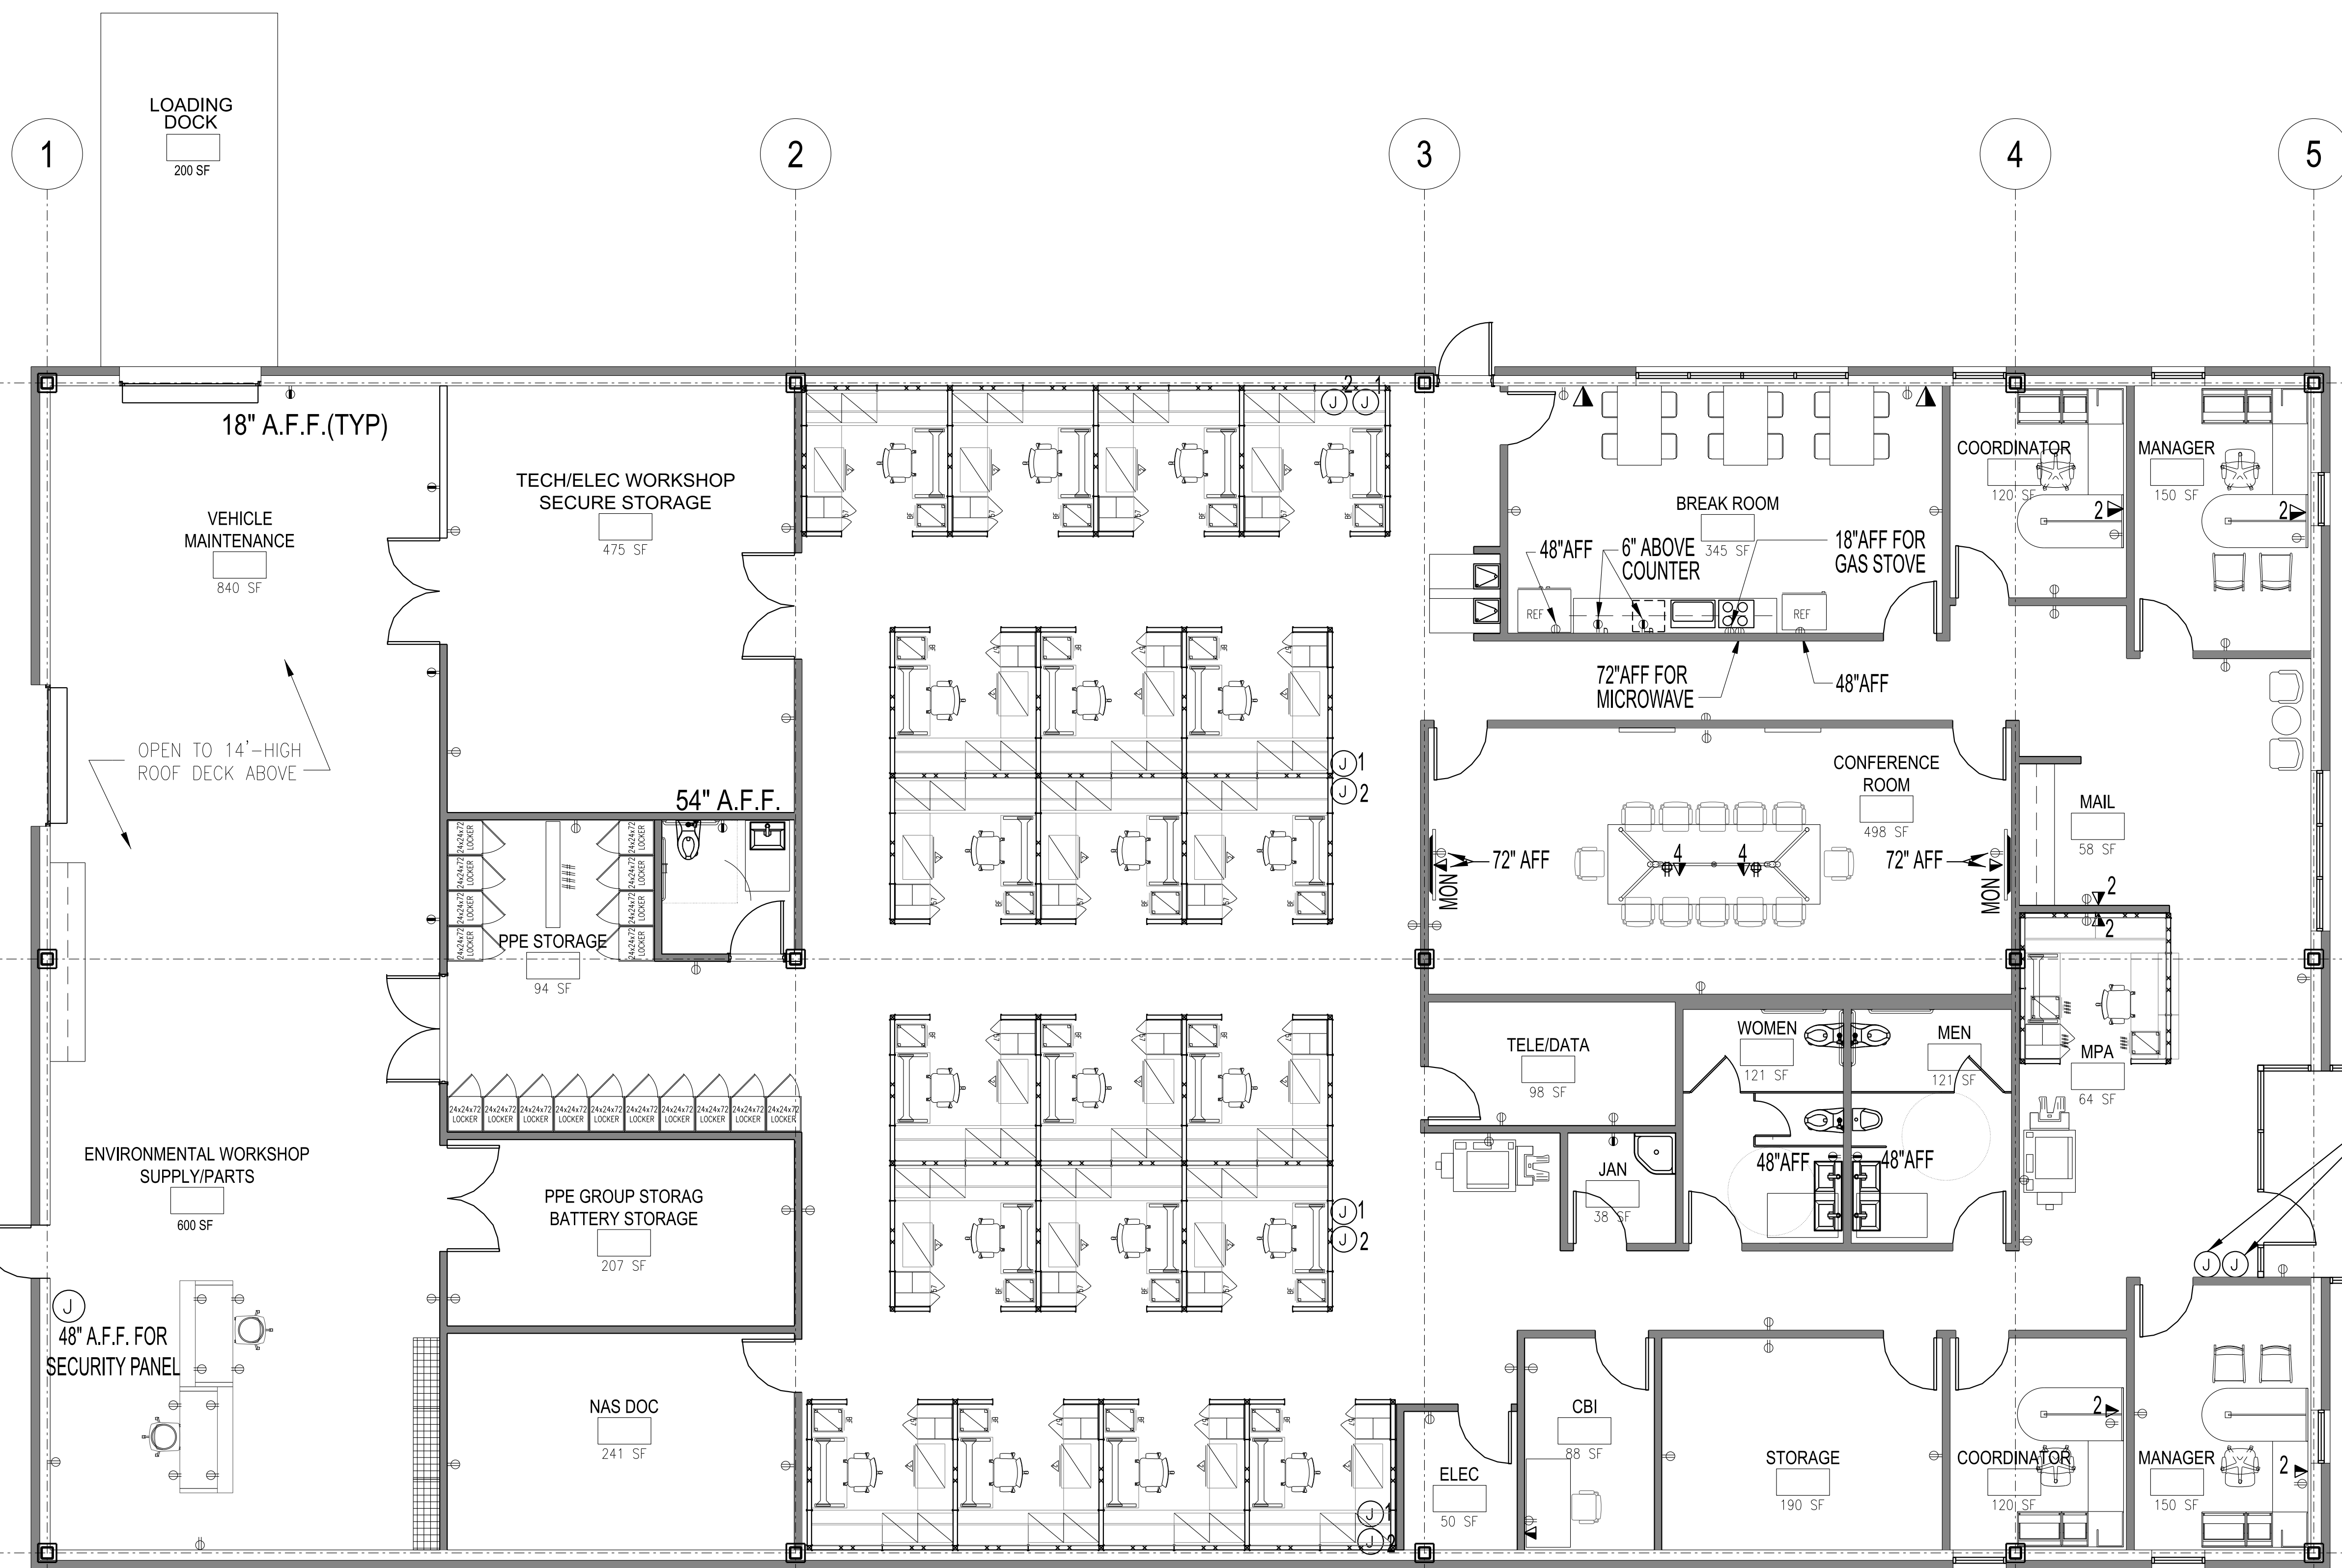

LEGEND

⊕	20 AMP DUPLEX RECEPTACLE - IVORY
⊕	20 AMP QUAD RECEPTACLE - IVORY
⊕	DEDICATED CIRCUIT 20 AMP RECEPTACLE - IVORY
⊕	20 AMP GFCI
⊕	4 SQUARE JUNCTION BOX
⊕	PROVIDE JUNCTION BOX 6" ABOVE FINISHED CEILING WITH 2 CIRCUITS FOR FUTURE POWER POLE BY OTHERS
⊕	PROVIDE JUNCTION BOX (6"x6"x4")
⊕	20 AMP CORD REEL MOUNTED ON THE STRUCTURE ABOVE
⊕	RJ45 DATA RECEPTACLE. PROVIDE 3/4" EMT INTO CEILING SPACE WITH 90° ELBOW AND BUSHING. DATA AND TELCO CABLING BY OTHERS. "X" = NUMBER OF RECEPTACLES ON A YOKE

NOTES

- PROVIDE OTHER ELECTRICAL RECEPTACLES AS REQUIRED BY CODE.
- SUBCONTRACTOR IS RESPONSIBLE FOR ALL OTHER APPUNTENANCES SUCH AS HVAC, AND FIRE ALARM.

PARSONS
 PTSI MANAGED SERVICES INC.
 955 L'ENFANT PLAZA NORTH, SW.
 SUITE 6100
 WASHINGTON, DC 20024


RELEASED: FOR REVIEW, NOT FOR CONSTRUCTION

PROJECT: DEPARTMENT OF TRANSPORTATION
 FEDERAL AVIATION ADMINISTRATION
 SHEET TITLE: BOISE, IDAHO SSC - TENANT RELOCATION
 NEW POWER PLAN

SCALE: 3/32" = 1'-0"
 DATE: 06/18/2021

SHEET NUMBER: []
 CAD FILE/XREF(S): []
 REVISION: 0

48" AFF POWER & WIRING FOR SECURITY PANEL AND FIRE ALARM PANEL

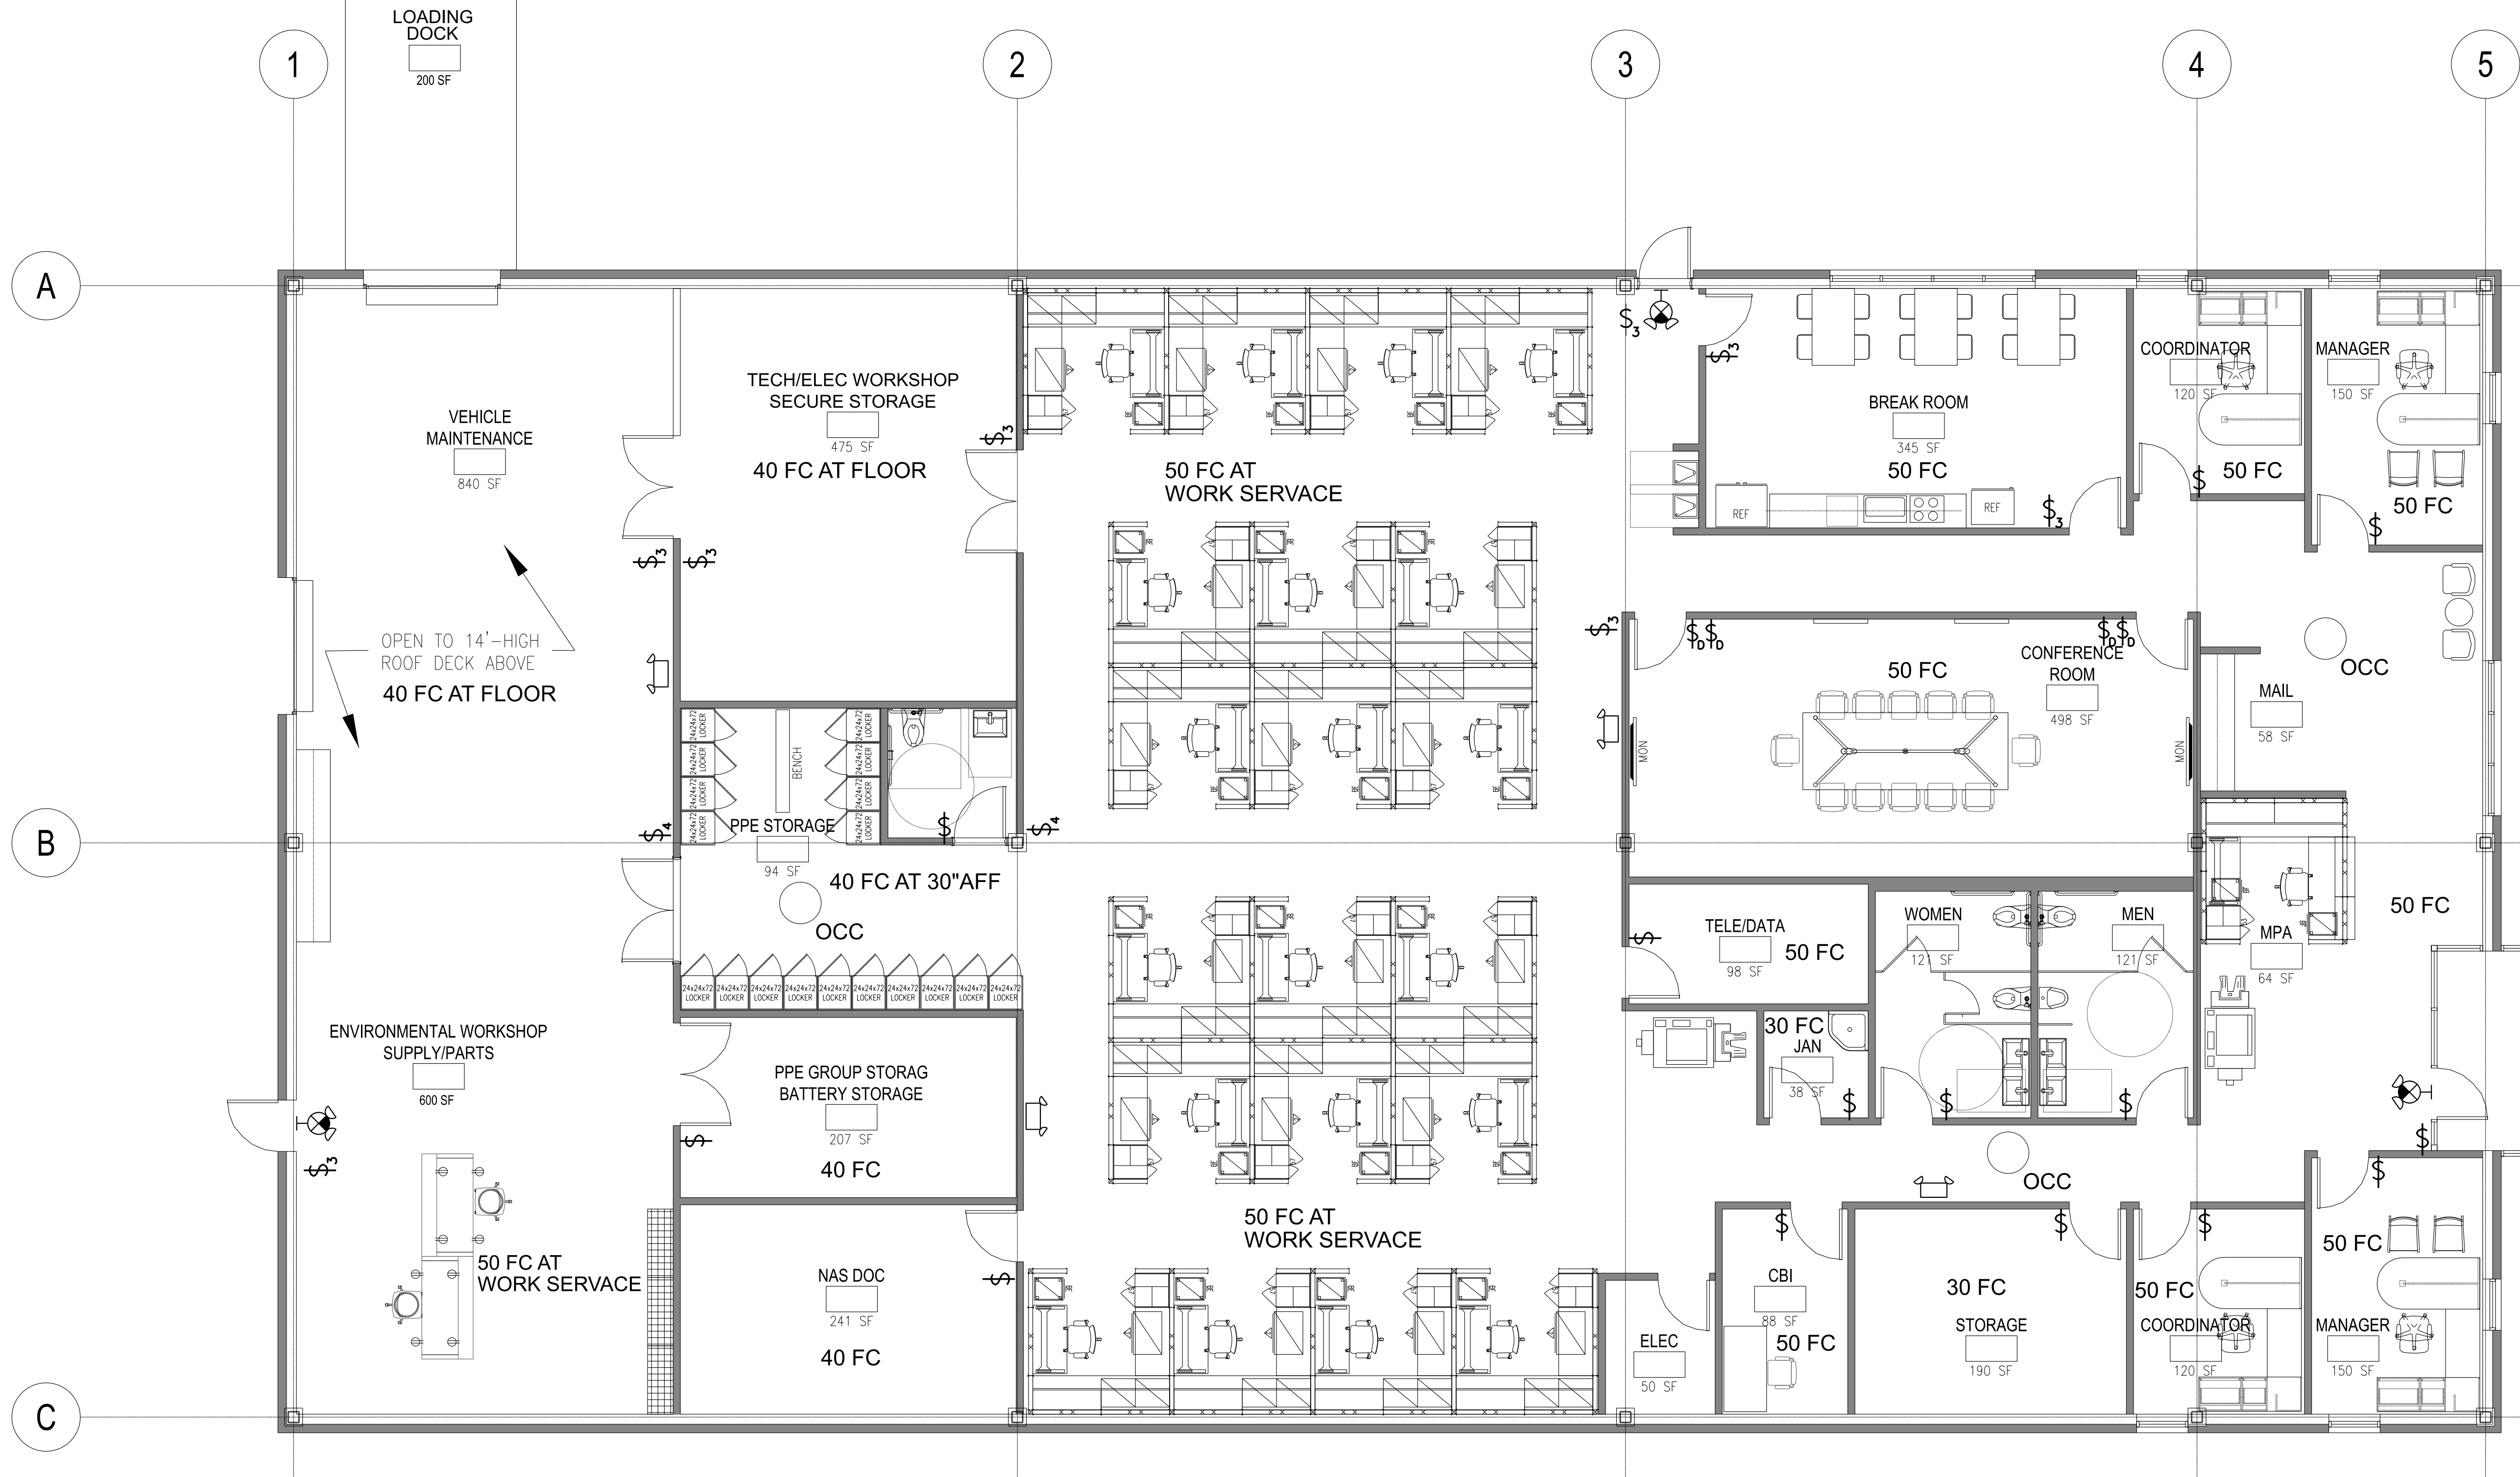

PARSONS
 PTSI MANAGED SERVICES INC.
 955 L'ENFANT PLAZA NORTH, SW,
 SUITE 6100
 WASHINGTON, DC 20024



RELEASED: FOR REVIEW, NOT FOR CONSTRUCTION

PROJECT: DEPARTMENT OF TRANSPORTATION
 FEDERAL AVIATION ADMINISTRATION

SHEET TITLE: BOISE, IDAHO SSC - TENANT RELOCATION
 NEW LIGHTING PLAN

SHEET NUMBER: _____

SCALE: 3/32" = 1' - 0"

DATE: 06/18/2021

CAD FILE/XREF(S): _____

REVISION: 0

10'-8" ↑