


APPENDIX 03

As-Built Drawings

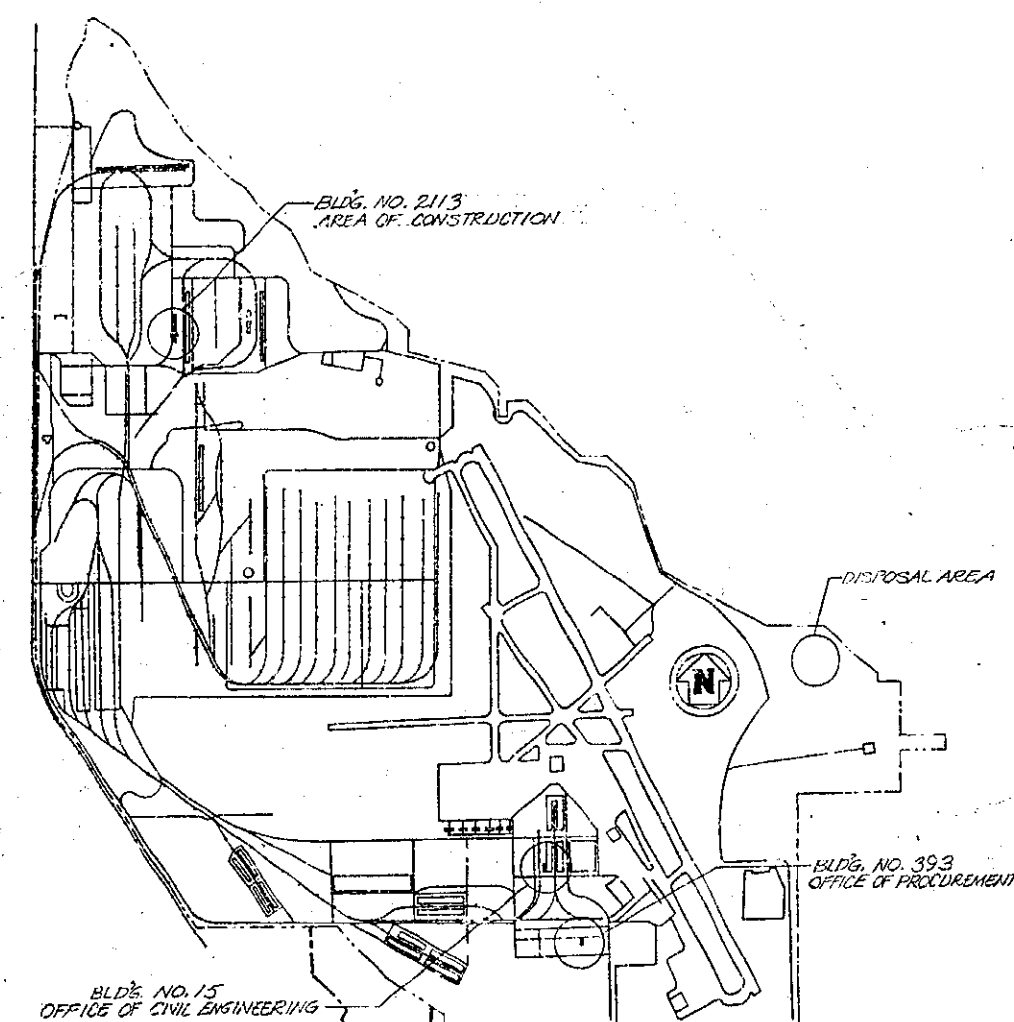

PROJECT HIL 258

1	07Feb62	"AS-10116"	DESCRIPTION
REV	NO	DATE	
HILL AIR FORCE BASE DEPARTMENT OF THE AIR FORCE ODGEN AIR MATERIEL AREA OFFICE OF CIVIL ENGINEERING			GADEN, UT 10
DESIGNED BY <u>CHUNTER</u> DRAWN BY <u>CHUNTER</u> APPROVED BY <u>E. HUNT JR.</u>			REMODEL RADIATION PROOF DOOR OPERATING FACILITY BUILDING NR. 2113
CHECKED BY <u>DATE</u> <u>07Feb 1962</u>			VICINITY MAP-PLAN AND SECTIONS
APPROVED BY <u>DATE</u> <u>07Feb 1962</u>			APPROVAL RECOMMENDED <u>07Feb 1962</u>
APPROVED BY <u>DATE</u> <u>07Feb 1962</u>			APPROVED <u>07Feb 1962</u>
APPROVED BY <u>DATE</u> <u>07Feb 1962</u>			WORK ORDER NO. <u>132-6</u> PROJECT NO. <u>132-6</u>
APPROVED BY <u>DATE</u> <u>07Feb 1962</u>			DRAWING NUMBER <u>67-6524</u>
APPROVED BY <u>DATE</u> <u>07Feb 1962</u>			SHEET 1 OF 3 SCALE AS NOTED

AS-CONSTRUC

241-167-5

49-73



PROJECT HIL 25-8

1	211067	"A'S BUILT"	DESCRIPTION	BY
REV	NO	DATE		

DEPARTMENT OF THE AIR FORCE
ODDEN AIR MATERIAL AREA
OFFICE OF CIVIL ENGINEERING

HILL AIR FORCE BASE OGDEN, UTAH


DESIGNED BY
DRAWN BY WINTER
CHECKED BY F. HUNT JR.
APPROVED BY DATE
SUBMITTED 11/10/46
APPROVAL RECOMMENDED DATE
APPROVED DATE
APPROVED DATE
APPROVED DATE

REMODEL RADIATION PROOF DOGS OPERATING FACILITIES
-- BUILDING NR. 2113
SECTION THROUGH DOOR & PIT
BOMB 150-1
DRAWING NUMBER
67-6524
SHEET 5 OF 3 SCALE AS SHOWN

49-68


2113-67-5

108 #67

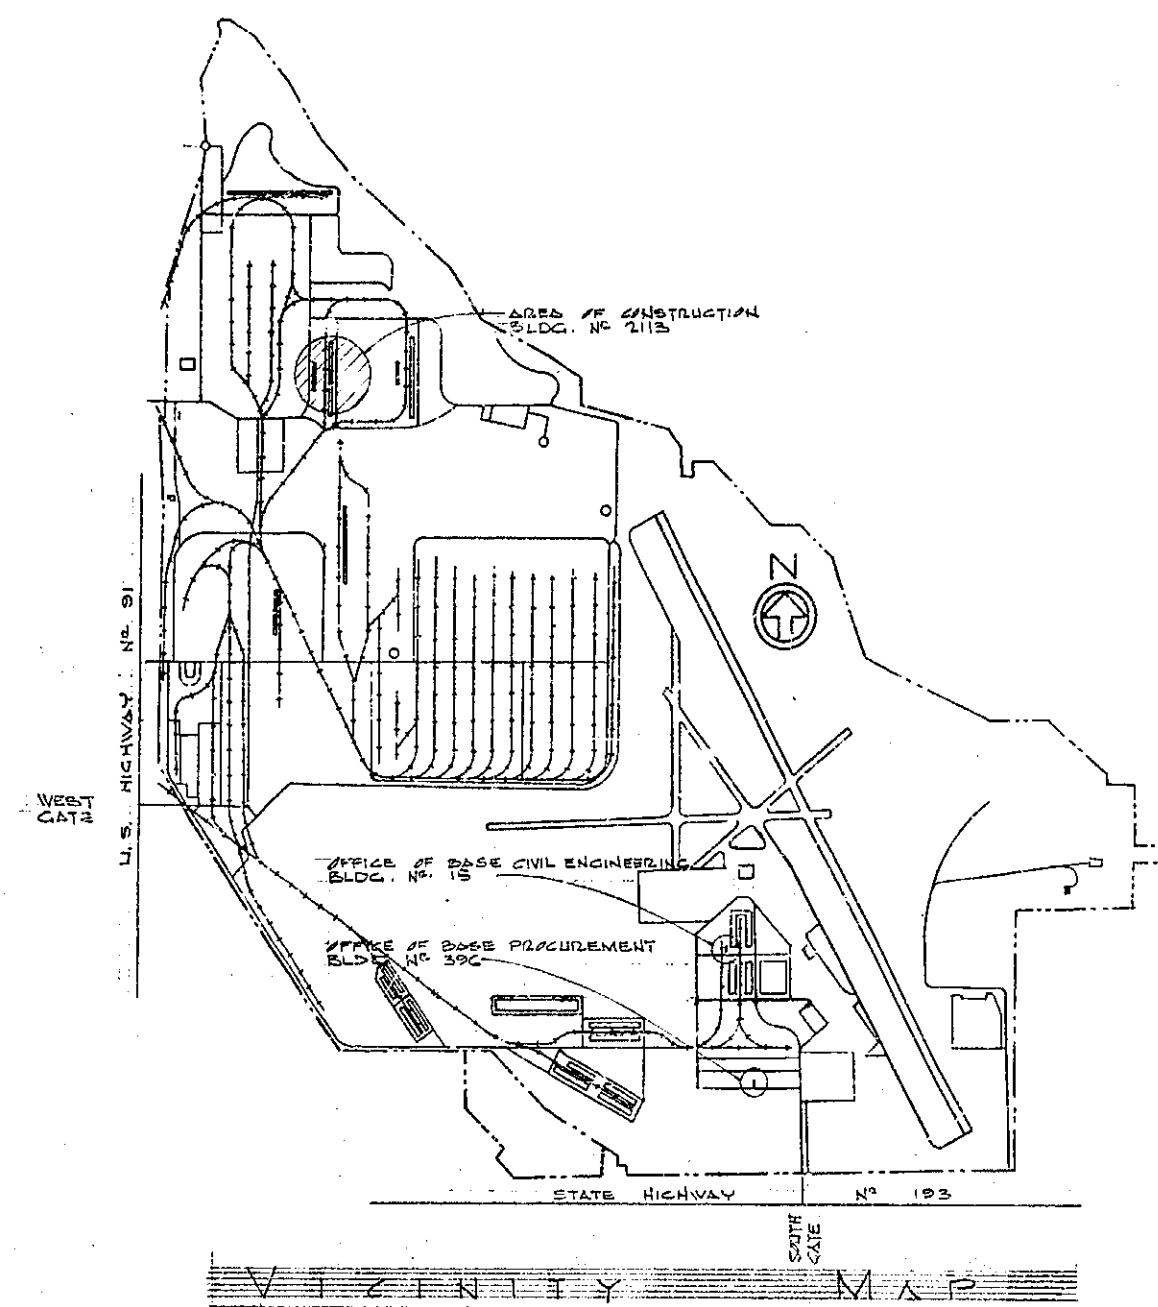

1. DOORS MARKED (A) & (B) SHALL BE EQUIPPED WITH
EXIT DEVICES (ACTIVE LEADS ONLY OF EACH DOOR)

AS CONSTRUCTED

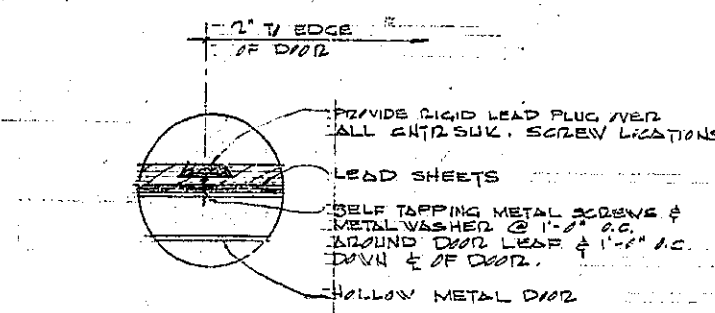

NOTES:


1. AT ALL JOINTS & AT OTHER PLACES WHERE METAL ANCHORING DEVICES PASS THRU LEAD SHEETS, SUCH AREAS SHALL BE PROTECTED BY A DOUBLE THICKNESS OF LEAD.
2. ALL OTHER LEAD LINING SHALL BE IN SINGLE UNBURNED SHEET.

REVISION	DATE	DESCRIPTION	BY
DEPARTMENT OF THE AIR FORCE ODGEN AIR MATERIEL AREA OFFICE OF GENERAL ENGINEERING			
MILL AIR FORCE BASE			ODGEN, UTAH
DESIGNED BY	<u>L.E.W.</u>	ALTERATION TO X-RAY LAB. BLDG. 2113 SITE, PLOT, FLOOR PLAN, & DETAILS	
DRAWN BY	<u>L.E.W.</u>		
TRACED BY			
CHECKED BY	DATE		
APPROVED BY	DATE		
<u>050636 JAN 14 1968</u>			
SUBMITTED	APPROVAL RECOMMENDED	APPROVED	
<u>Franklin</u>	<u>W. H. Work</u>	<u>Shelly</u>	
APPROVED (FINITE PROTECTION)	DATE	WORK ORDER NO.	
			<u>W. H. 0072 E</u>
APPROVED (SPECIAL INDUST. HYGIENE CASE)	DATE	DRAWING NUMBER	
<u>W. H. 0072 E</u>	<u>25 JAN 68</u>	C5-5280	
APPROVED (GROUND SAFETY)	DATE		
<u>W. H. 0072 E</u>	<u>25 JAN 68</u>		
SHEET (1) OF 2		SCALE NOTED	

49-93


5280-1

2113-65-A

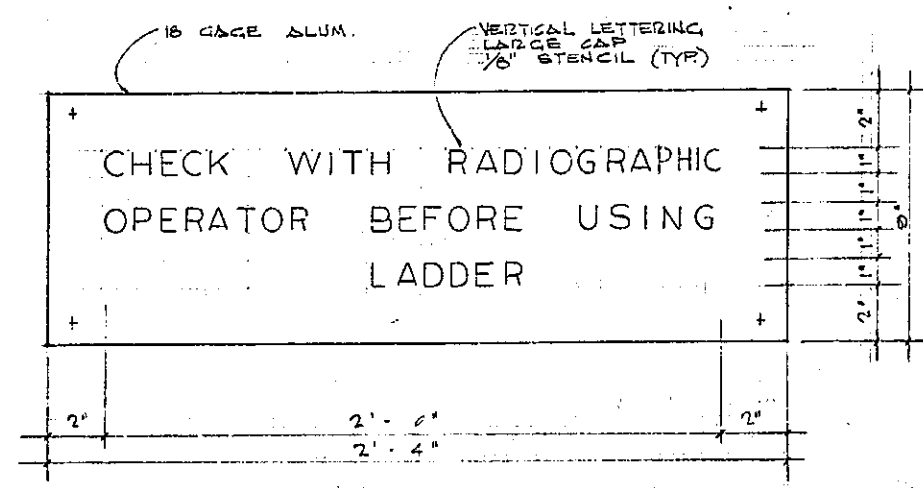


SIGN DETAIL #1
NOT TO SCALE

NOTE:
1. SEE SPECS FOR PAINT FINISH
2. SIGN TO BE LOCATED AS SHOWN AT GATE ELEV.
3. SECURE TO CONC. WALL WITH 4-5/16" x 1/4" LING LAG. BOLTS WITH EXPANSION SHIELD
4. REMOVE ALL BURRS & SHARP EDGES

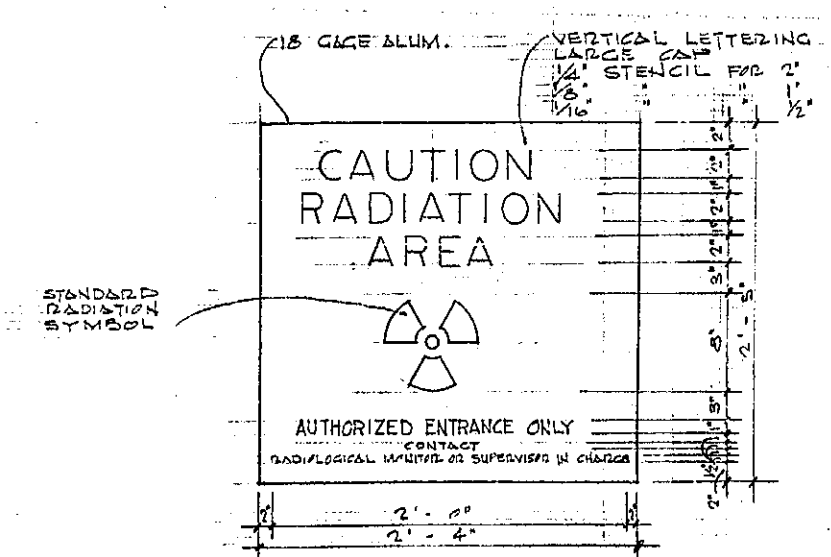



SIGN DETAIL #2
NOT TO SCALE

NOTE:
1. SEE SPECS FOR PAINT FINISH
2. SECURE SIGN TO EXIST. VEST. METAL DWDS. OF 250 K.V.P. RM.
3. SECURE SIGN TO EXIST. VEST. METAL DWDS. WITH 4-5/16" x 1/4" LING LAG. BOLTS WITH EXPANSION SHIELD
4. REMOVE ALL BURRS & SHARP EDGES

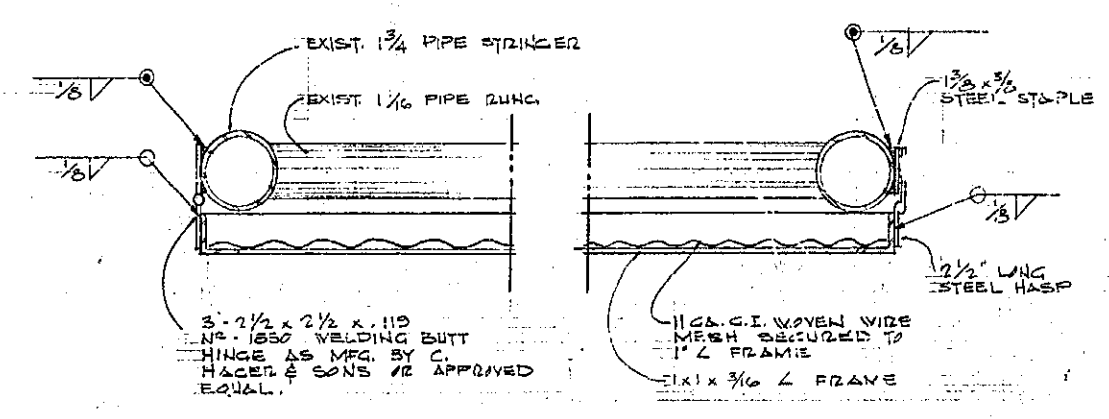


SECTION A-A
GATE & EXTERIOR LADDER
NOT TO SCALE

NOTE:
1. CONTRACTOR TO FURNISH 1" YALE SUPER PIN TUMBLER PADLOCK CAT. IN BSI WITH THREE KEYS. KEYS TO BE MADE BY MASTERKEY SYSTEM.
2. PAINT FINISH OF GATE AND SIGN: SEE SPECS.
3. INSTALL STAPLE TO CONC. WALL TO SECURE GATE IN OPEN POSITION WHILE USING LADDER.

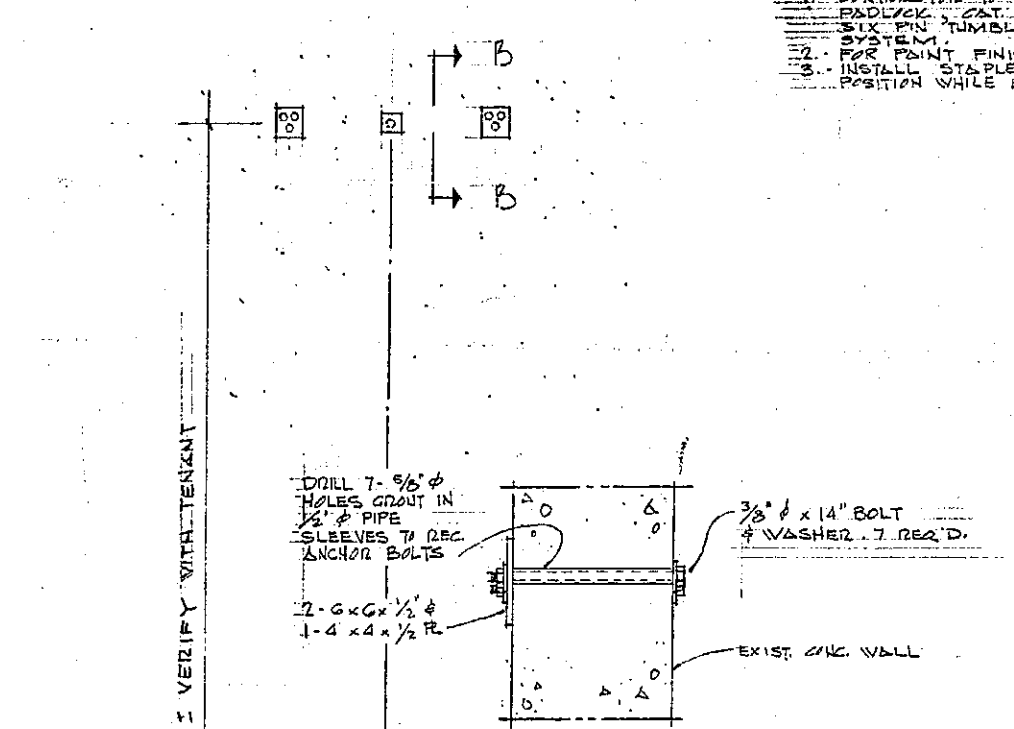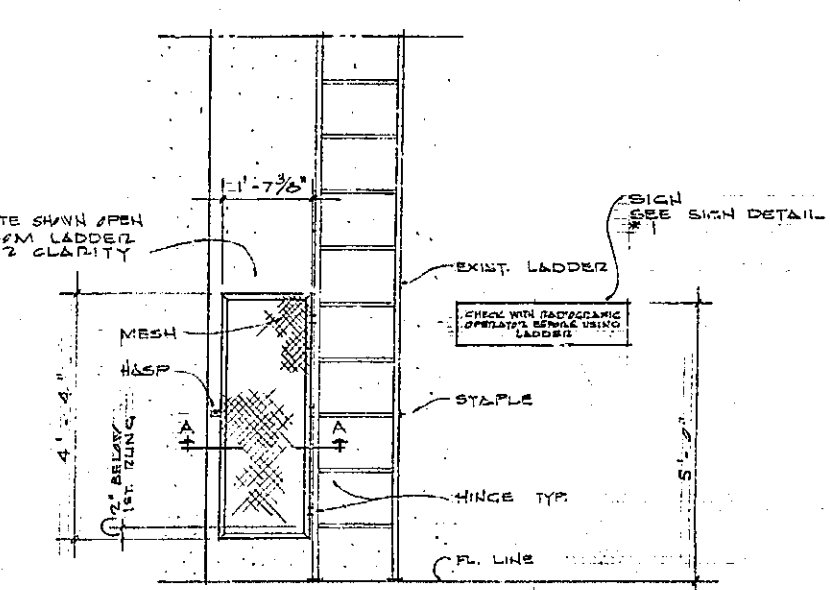

SECTION B-B
NOT TO SCALE

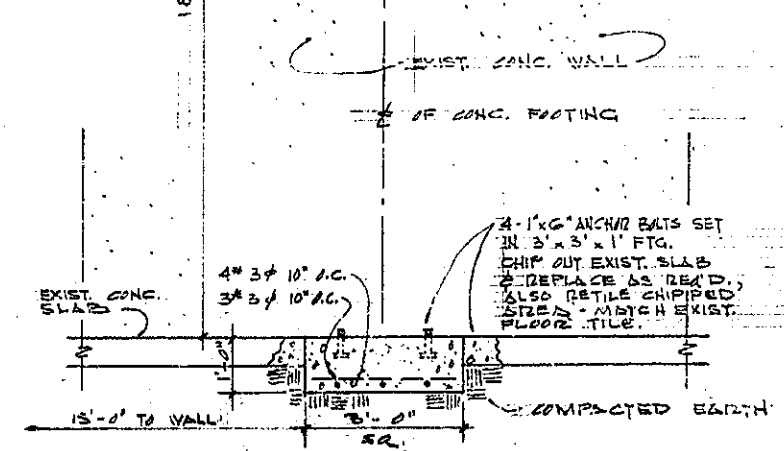

ELEV. OF CONCRETE SUPPORTS
NOT TO SCALE

NOTE: VERIFY EXIST. LOCATIONS OF ALL BOLTS FOR JIB CRANE WITH TENANT.

AS CONSTRUCTED


REVISION	DATE	DESCRIPTION	BY
DEPARTMENT OF THE AIR FORCE OGDEN AIR MATERIEL AREA OFFICE OF CIVIL ENGINEERING OGDEN, UTAH			
DESIGNED BY	DATE	ATTENTION TO X-RAY LAB.	
DRAWN BY	DATE	BLDG. 2113	
CHECKED BY	DATE	MISCELLANEOUS DETAILS	
APPROVED BY	DATE		
SUBMITTED	DATE	APPROVAL RECOMMENDED	APPROVED
APPROVED (FIELD PROTECTION)	DATE	WORK ORDER NO.	PROJECT NO.
APPROVED (CONSTRUCTION)	DATE	DRAWING NUMBER	
APPROVED (GROUND SAFETY)	DATE		
SHEET 1 OF 1		SCALE	NOTED

49-94



2113-65-1A

5280-2

REVISIONS			
SYM	DESCRIPTION	DATE	APPROV

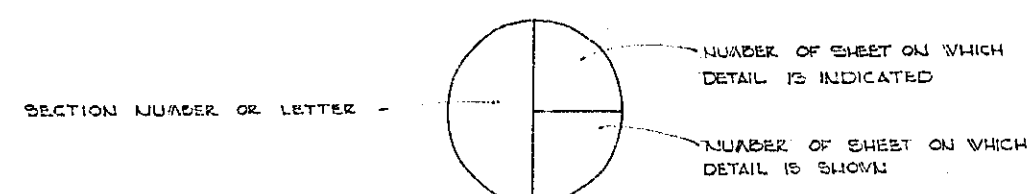

CROSS REFERENCE SYSTEMS

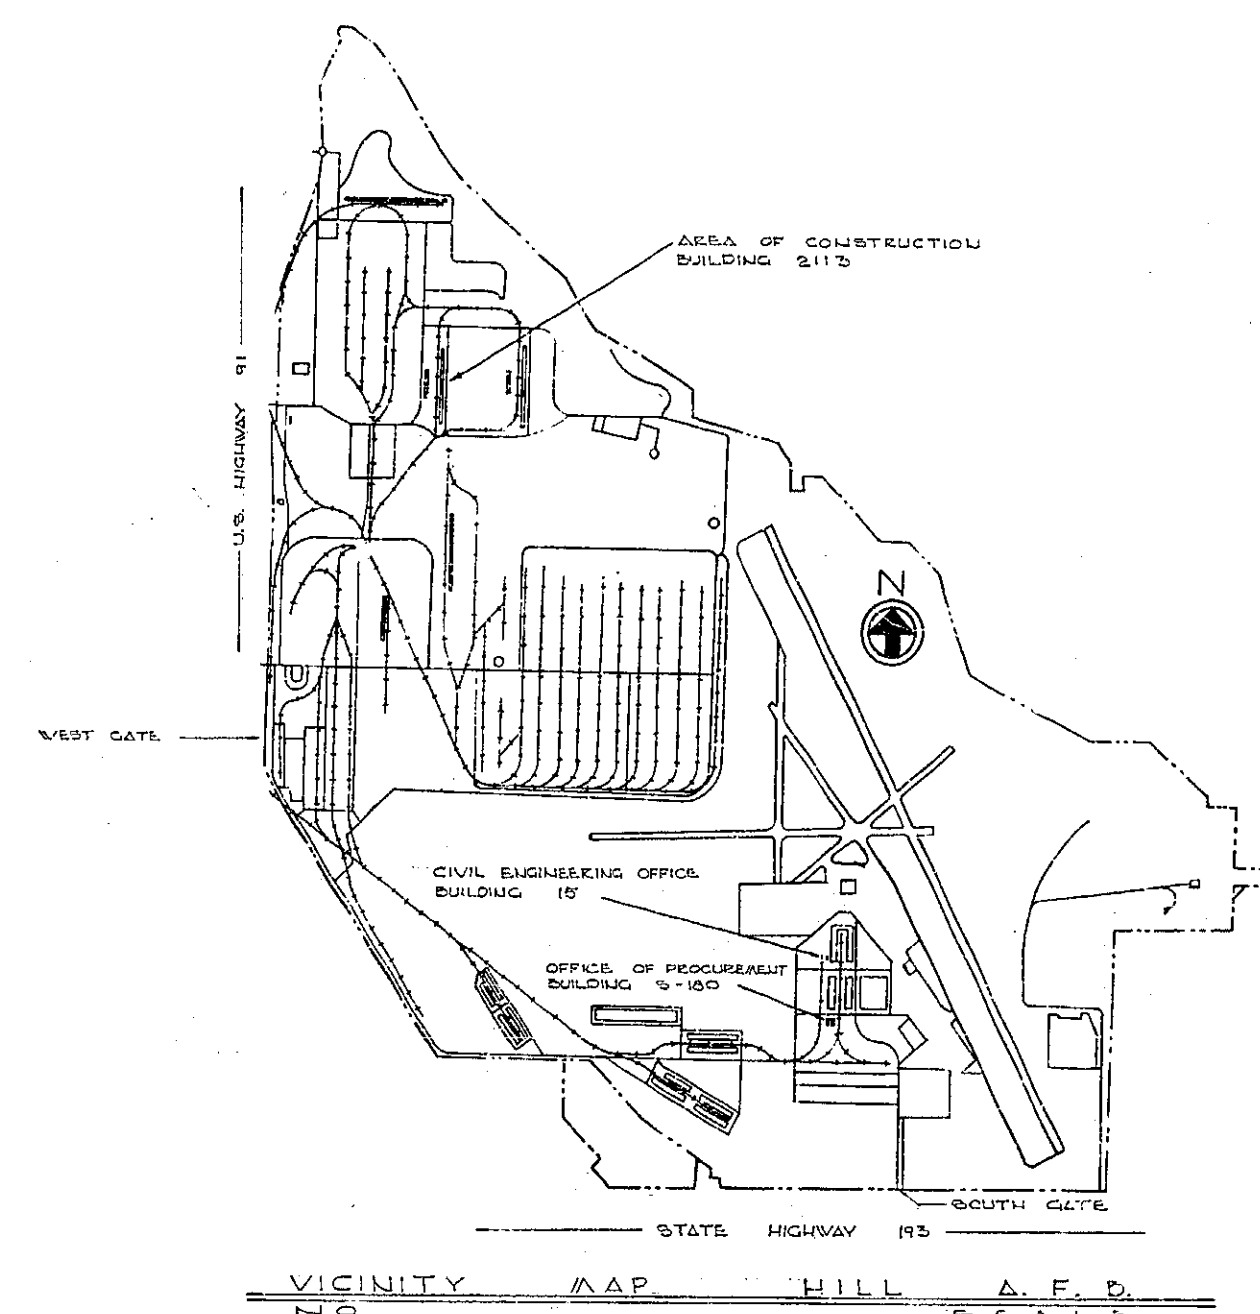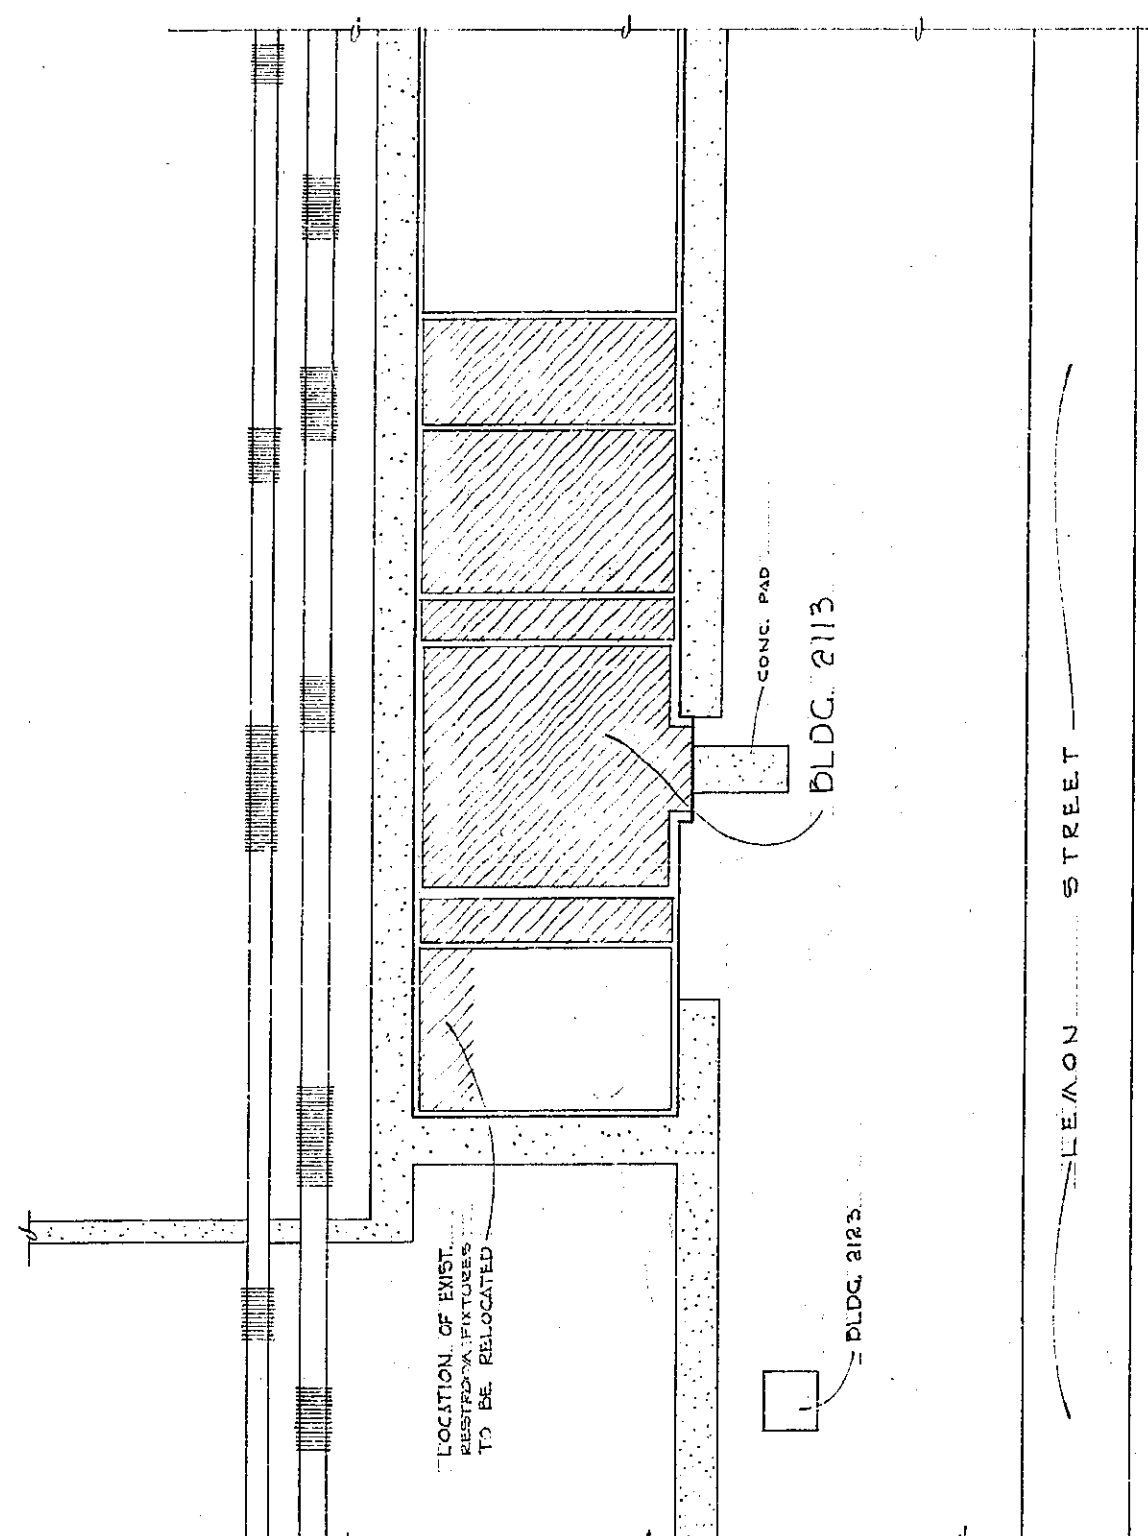

LIST OF DRAWINGS

<u>S.N. NO.</u>	<u>TITLE</u>
1 - - - - -	PLOT PLAN & VICINITY MAP
2 - - - - -	FLOOR PLAN
3 - - - - -	SECTION THRU BLDG. & DETAILS
4 - - - - -	DETAILS & GENERAL NOTES

PLOT PLAN BLDG. 2113
SCALE 1" = 20'-0"

 ---- AREA TO BE ALTERED

49-95

AS - CONSTRUCTED

2076 ~~2076~~ 17 Feb 68
 2nd Lt. Joseph D. 19 Feb 68
 Paul J. Romagnolo BA FIP Jask
 00 VP 111 - 2nd Lt. J. P. Romagnolo

ADDITIONAL CODE IDENT NO	DRAWN BY	DATE	U.S. AIR FORCE	
	D.U.E.	FEB. 64	OGDEN AIR MATERIEL AREA	
CHECKER	R. M. & C. G. J.	FEB. 64	1111 AIR FORCE BASE	OFFICE OF CIVIL ENGINEERING
DESIGNED	D.U.E.	FEB. 64	OGDEN UT	
QUANTITY	1	11/64	ALTERATION TO X-RAY LAB. BLDG. 2113 PLOT PLAN & VICINITY MAP	
BY	R. M. & C. G. J.	11/64		
DATE	11/64	11/64		
APPROVAL	APPROVED	DATE	CODE IDENT NO.	SIZE
11/64	11/64	11/64	F	DRAWING N°
11/64	11/64	11/64		64 - 5163
FINAL	APPROVAL	DATE	SCALE	SHEET
11/64	11/64	11/64	1:1	1 OF 1


214

AE FORA 1657



2113-64-C

ENGINEERING DRAWING LAYOUT


REVISIONS			
SYM	DESCRIPTION	DATE	APR JVS

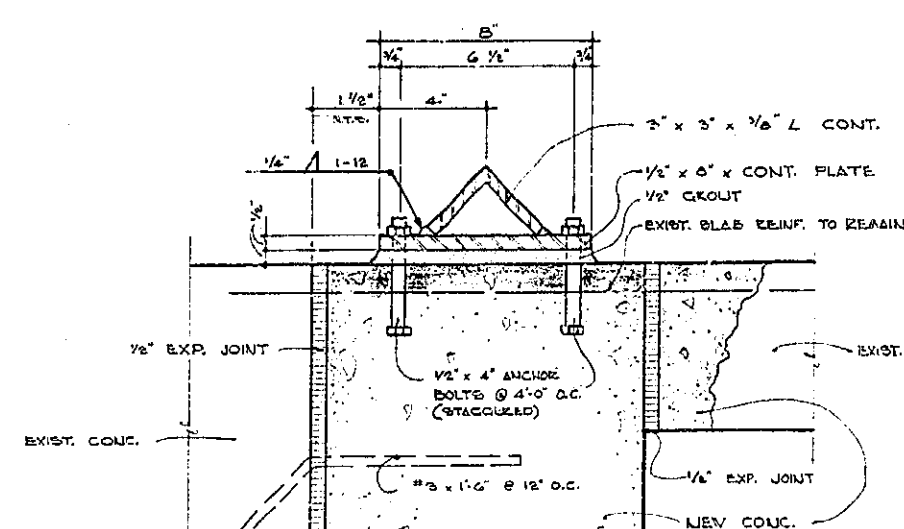

DETAIL

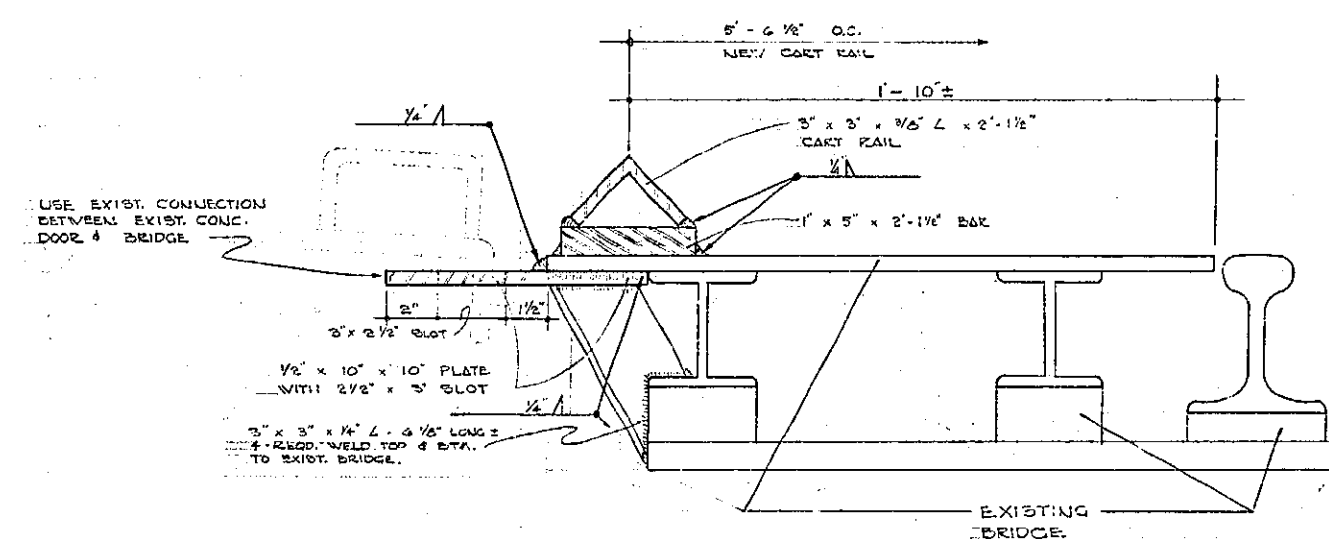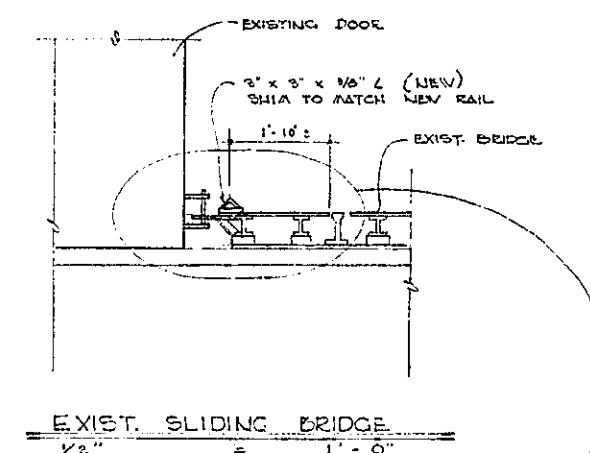

② DETAIL (TYP.)

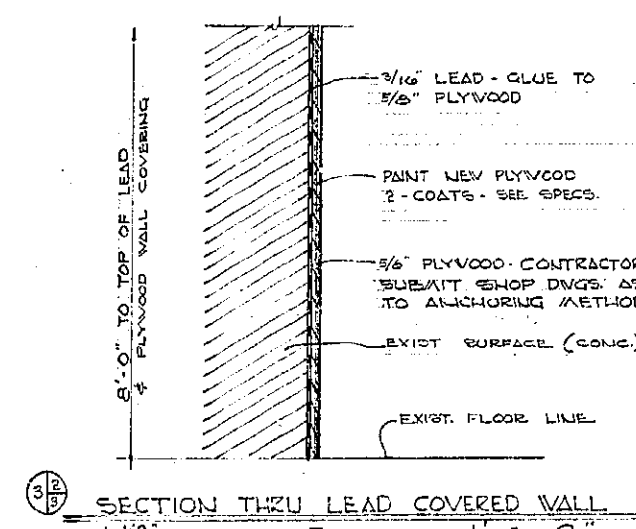

SECTION THRU LEAD COVERED WALL

SECTION A(2/3)
SCALE 1/4" = 1'-0"

44-97

AS-CONSTRUCTED


CO. 76 ~~17 Feb 64~~ 17 Feb 64
 2nd Sgt. BD 17 Feb 64
 OO BAF Paul Rompfelt 17 Feb 64
 OO VPM - Kent L. Newlin

ADDITIONAL CODE IDENT NO.	DRAWING BY D.U.E.	DATE FEB. 66	U.S. AIR FORCE ORDEN AIR MATERIAL AREA	
CHECKER R. A. F. C. Q. J.	DATE FEB. 66	1.111 AIR FORCE BASE	OFFICE OF CIVIL ENGINEERING	
DESIGNED D.U.E.	FEB. 66	ALTERATION TO X-RAY LAB. BLDG. 2113		
SUBMITTED R. A. F. C. Q. J.	DATE FEB. 66	SECTION THREE BLDG. & DETAILS		
APPROVED R. A. F. C. Q. J.	DATE FEB. 66	CODE IDENT NO.	SIZE	DRAWING NO.
APPROVAL/RECOMMENDED R. A. F. C. Q. J.	DATE FEB. 66	F		64-5163
FINAL APPROVAL R. A. F. C. Q. J.	DATE FEB. 66	SCALE AS NOTED	PROJ. NO. -	SHEET 3 OF 4

216

2113-64-A

ENGINEERING DRAWING LAYOUT 5


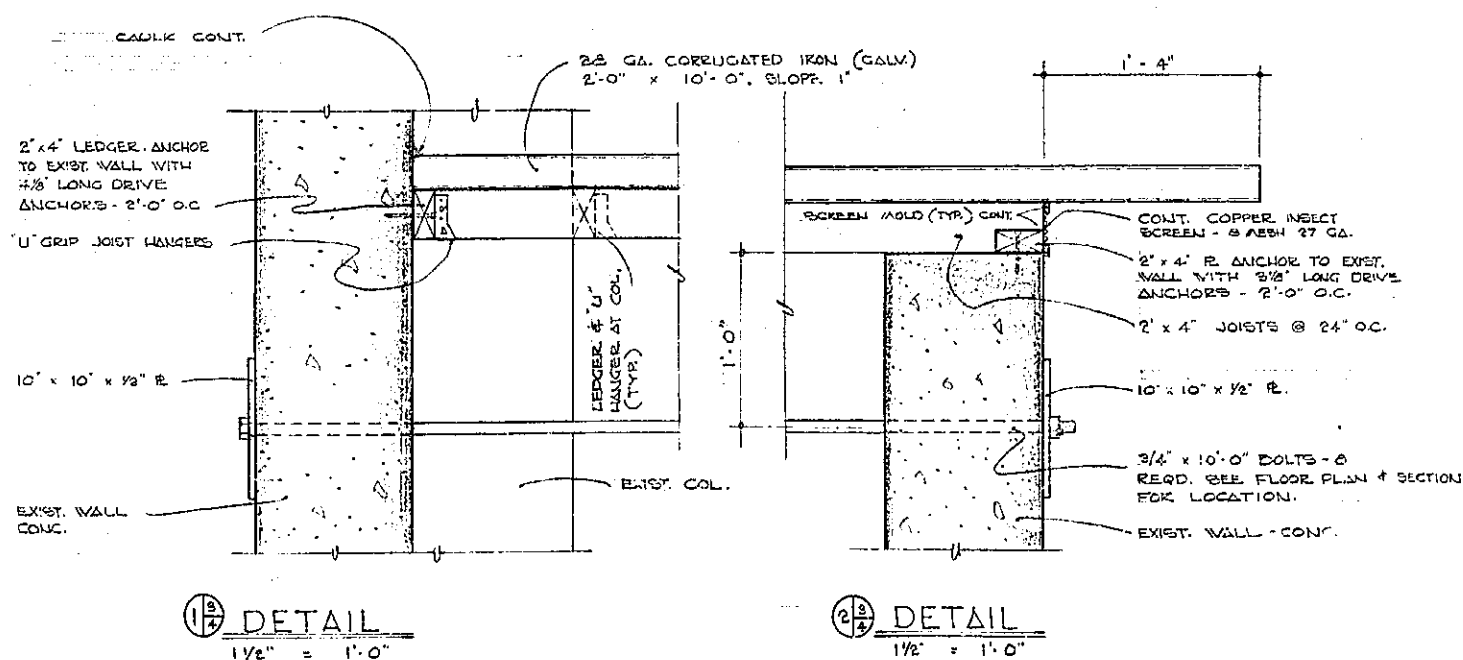


1. CONTRACTOR SHALL MAKE A PRE-BID SITE INSPECTION TO ASCERTAIN THE SCOPE & AMOUNT OF WORK TO BE ACCOMPLISHED.
2. ALL WORK INVOLVED IN THIS CONTRACT SHALL CONFORM TO THE NATIONAL BLDG. CODE INVOLVED.
3. ALL ITEMS CALLED OUT BY AFG. HAZARD MAY BE SUBSTITUTED WITH AN APPROVED EQUAL IN LIEU OF.
4. REMOVE FROM EXIST. RESTROOM THE FOLLOWING FIXTURES & EQUIPMENT IF AVAILABLE:
 - a) WATER CLOSET
 - b) PAPER TOWEL DISPENSER, (1) TOILET PAPER DISPENSER, (1) SOAP DISPENSER, & (OTHER) EQUIPMENT AS DIRECTED BY CONTRACTING OFFICER.
5. INSTALL 11 "NEW RESTROOM LOCATIONS" AS SHOWN ON FLOOR PLAN. CAP ALL EXISTING WATER & DRAIN LINES AFTER REMOVAL OF FIXTURES FROM EXISTING RESTROOM. INSTALL NEW URINAL "WASHAL" * F-6200 & F-6200-1 FLUSH VALVE. NEW METAL SCREEN & TOILET PARTITION SHALL BE "MILLS METAL PARTITION" (SEMI-GLASS STYLE) SIZE SHALL BE AS SHOWN ON FLOOR PLAN. COLOR TO BE SELECTED BY CONTRACTING OFFICER. ALSO INSTALL NEW LABORATORY "NEW URGENT" * F-50-40 WITH "N-201-B, R-260-4, & 7700-4 ACCESSORIES."
6. NORTH BARRICADE SHALL BE FILLED TO A HEIGHT OF 10'-0" WITH A SANDY SOIL AS SHOWN ON SECTION 18. SOUTH BARRICADE SHALL BE FILLED WITH A 3" S&G CONCRETE, 1/2" LIEUT OF EXISTING OFFICER. ALSO INSTALL SANDY SOIL TO A FINISHED HEIGHT OF 20'-0". SEE SPECIFICATIONS FOR CONCRETE MIX & SANDY SOIL.
7. NEW ELECTRIC WHICH SHALL BE "YALE TOWNE (CABLE KING) * W371F, 440 VOLTS, 3 PHASE, 60 CYCLE EXPLOSION PROOF WITH STAINLESS STEEL CABLE & LOCK. USE 4" - 7/8" ANCHOR BOLTS SET IN LEAD EXPANSION SHIELDS.
8. DOORS MARKED 1, 2, 3, 718, 71

AS-CONSTRUCTED

0076 ~~0076~~ ~~0076~~ 17 Jul 64
 2nd of 2nd BD 17 Jul 64
 Part of Romblet BAF 17 Jul 64
 DDVPM - Part 2. P. 17

ADDITIONAL CODE IDENT NO.	DESIGNED BY D.U.E.	DATE FEB. 64	U.S. AIR FORCE OGDEN AIR MATERIAL AREA	
	CHECKED R.M. & G.O.J.	FEB. 64	MIL AIR FORCE BASE OFFICE OF CIVIL ENGINEERING	
	DESIGNED D.U.E.	FEB. 64	OGDEN UT	
ALTERATION TO X-RAY LAB. BLDG. 2113 DETAILS & GENERAL NOTES				
APPROVED <i>[Signature]</i>	SUBMITTED <i>[Signature]</i>	<i>[Date]</i>	CODE IDENT NO.	SIZE F
APPROVAL RECOMMENDED <i>[Signature]</i>	<i>[Signature]</i>	<i>[Date]</i>		
FILLER APPROVAL <i>[Signature]</i>	APPROVAL <i>[Signature]</i>	<i>[Date]</i>	SCALE	SHEET 1 OF 4

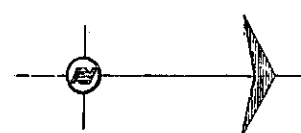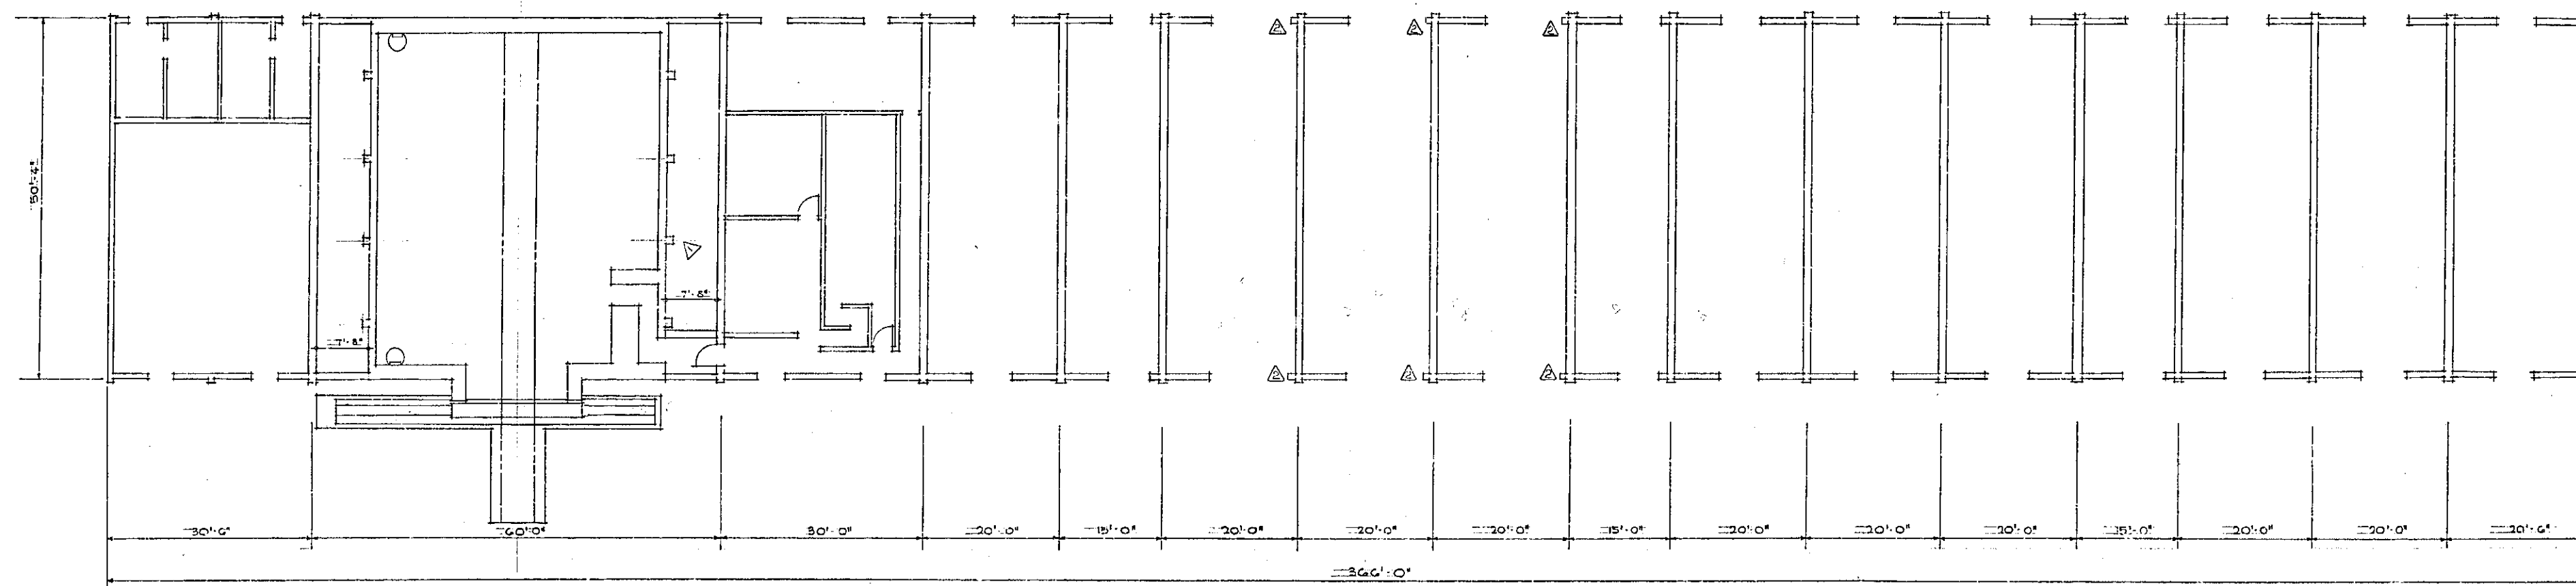

FLOOR PLAN BLDG. 2113
 AS SCALE 1/8"=1'-0"

12 JUNE 68	325-61	ENLARGE THE SIX DOORS IN BAYS 6, 7 & 8	K.A.A.
5 MAR 59	5801	MODIFY BLDG. 2113 TO INSTALL FPLY EQUIPMENT	AND
REVISION	DATE	DESCRIPTION	BY
DEPARTMENT OF THE AIR FORCE OGDEN AIR MATERIEL AREA OFFICE OF INSTALLATIONS			
HILL AIR FORCE BASE			OGDEN, UTAH
DESIGNED BY			
DRAWN BY			
CHECKED BY	DATE		
APPROVED BY	DATE		
SUBMITTED	APPROVAL RECOMMENDED	APPROVED	
APPROVED	DATE	PROJECT NO.	
APPROVED	DATE	DRAWING NUMBER	
APPROVED	DATE	SHEET	OF SCALE

318

DD FORM 405
 1 MAR 55 (REV)


2113-59-A

49-12

BLDG 2113

MODIFICATION OF BUILDING N° 2113 FOR X-RAY FACILITIES

HILL AIR FORCE BASE - OGDEN, UTAH

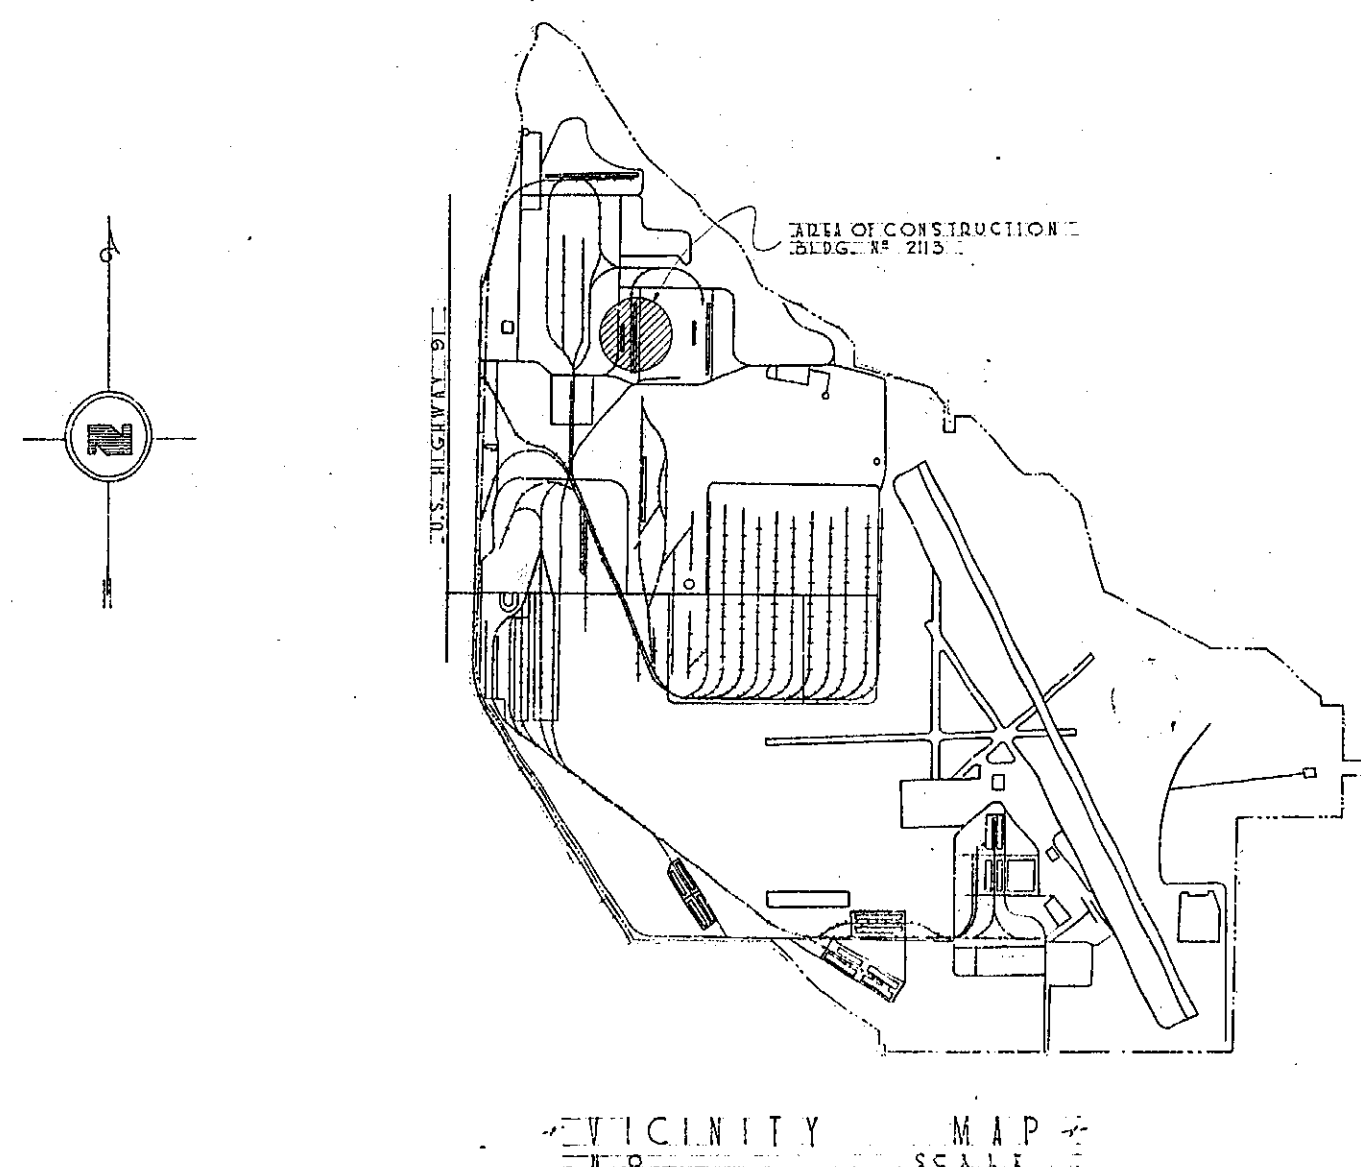


INDEX OF SHEETS

1. COVER SHEET & VICINITY MAP
2. PLOT PLAN & UTILITY LAYOUT
3. FLOOR PLAN
4. ELEVATIONS
5. SECTIONS THRU BUILDING & DETAILS
6. FOOTING, FOUNDATION PLANS & DETAILS
7. WALL REINFORCING & CEILING FRAMING PLANS
8. MISCELLANEOUS DETAILS
9. MISCELLANEOUS DETAILS
10. CONCRETE DOOR & TRACK DETAILS
11. ELECTRICAL

PREPARED BY INSTALLATIONS DIVISION
HILL AIR FORCE BASE - OGDEN, UTAH


PROJECT N° HIL-29-8
DRAWING N° 58-3866
SHEET ① OF 11

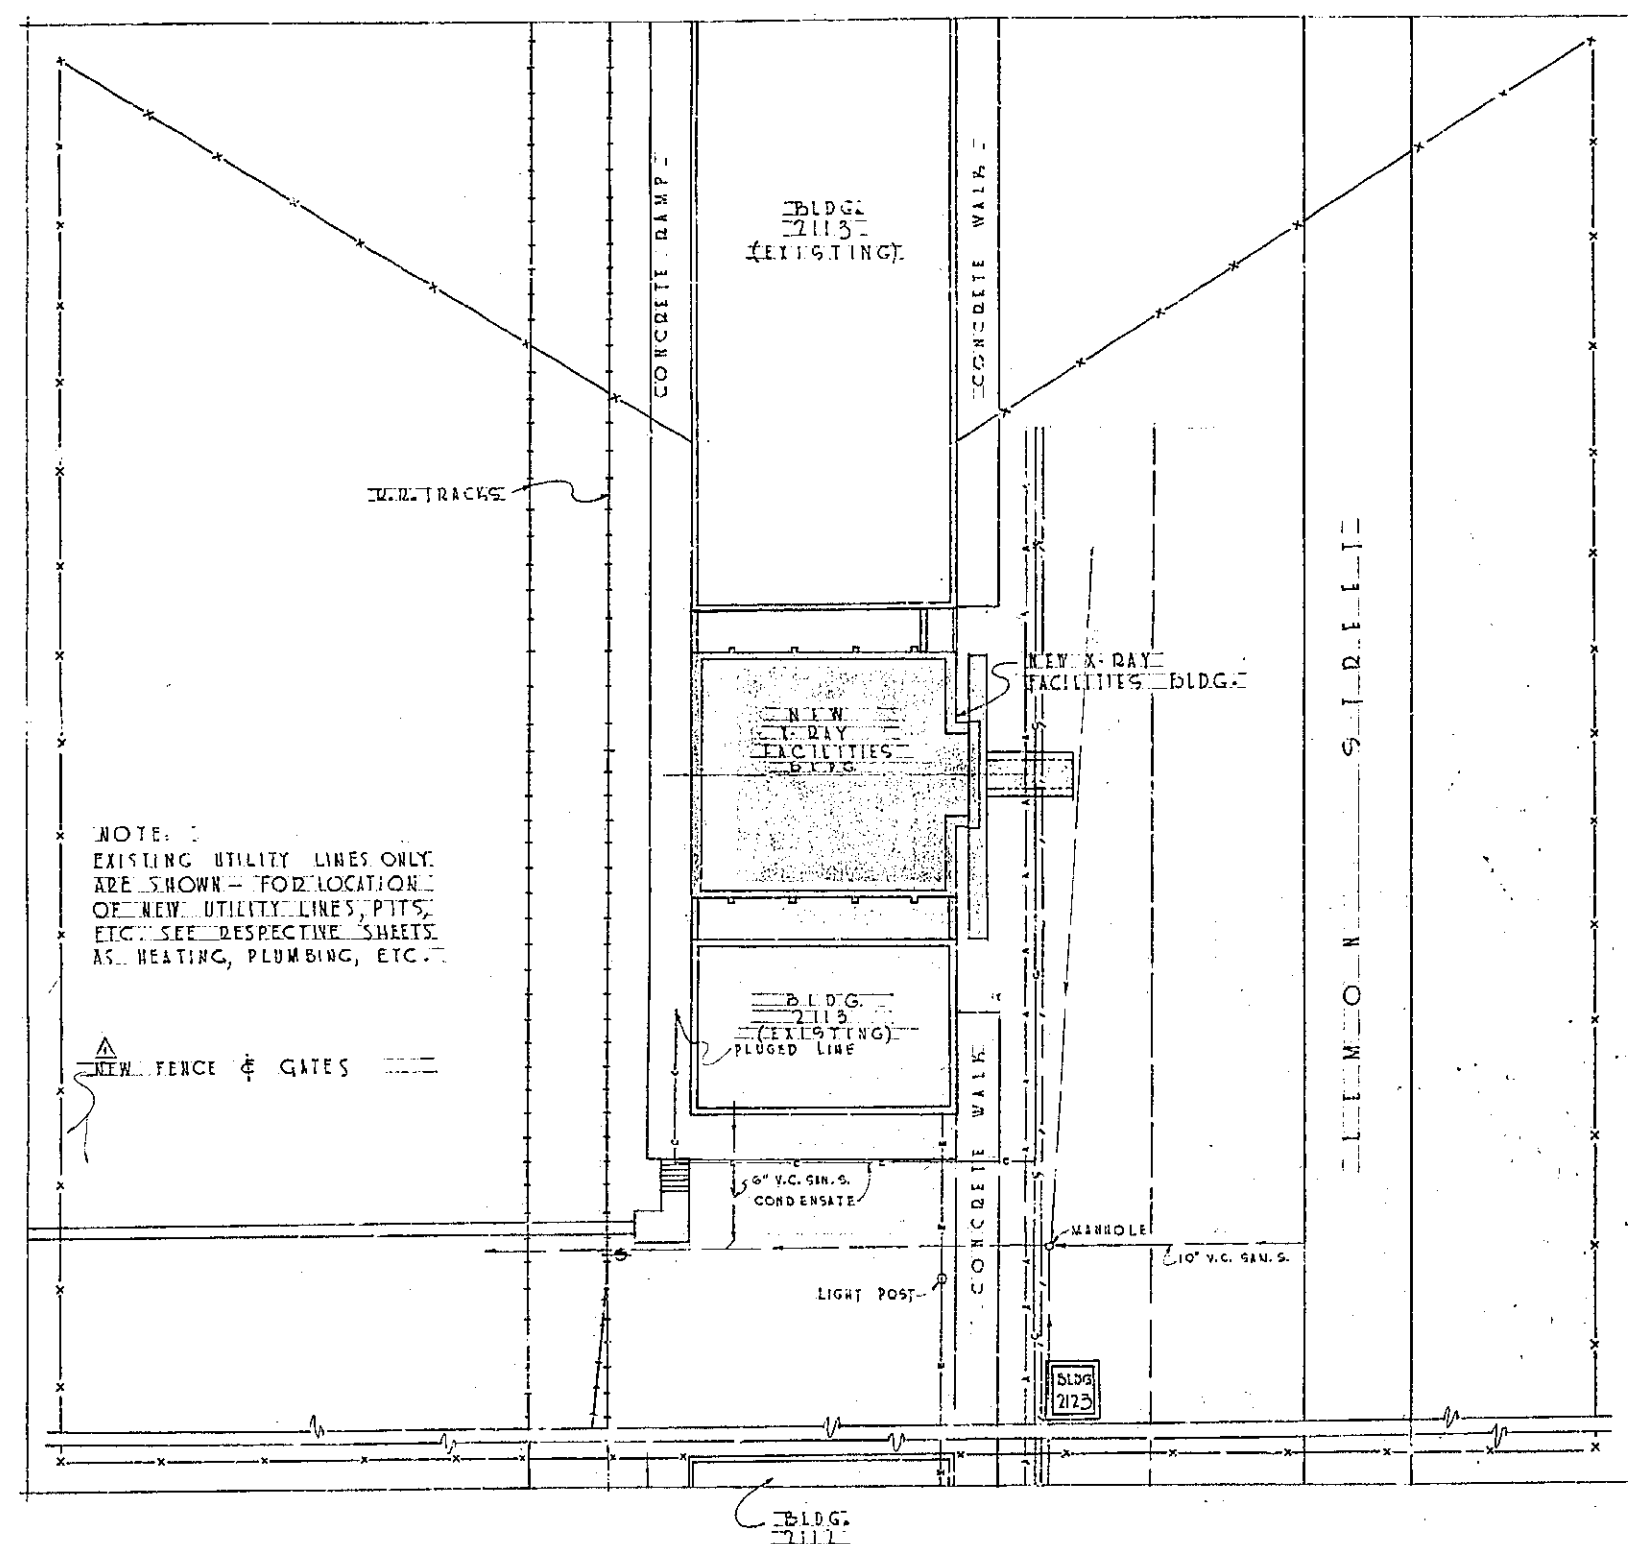

UTILITY LAYOUT
SCALE 1" = 20'

NOTES

FENCING & GATES TO BE ACCOMPLISHED BY OTHERS


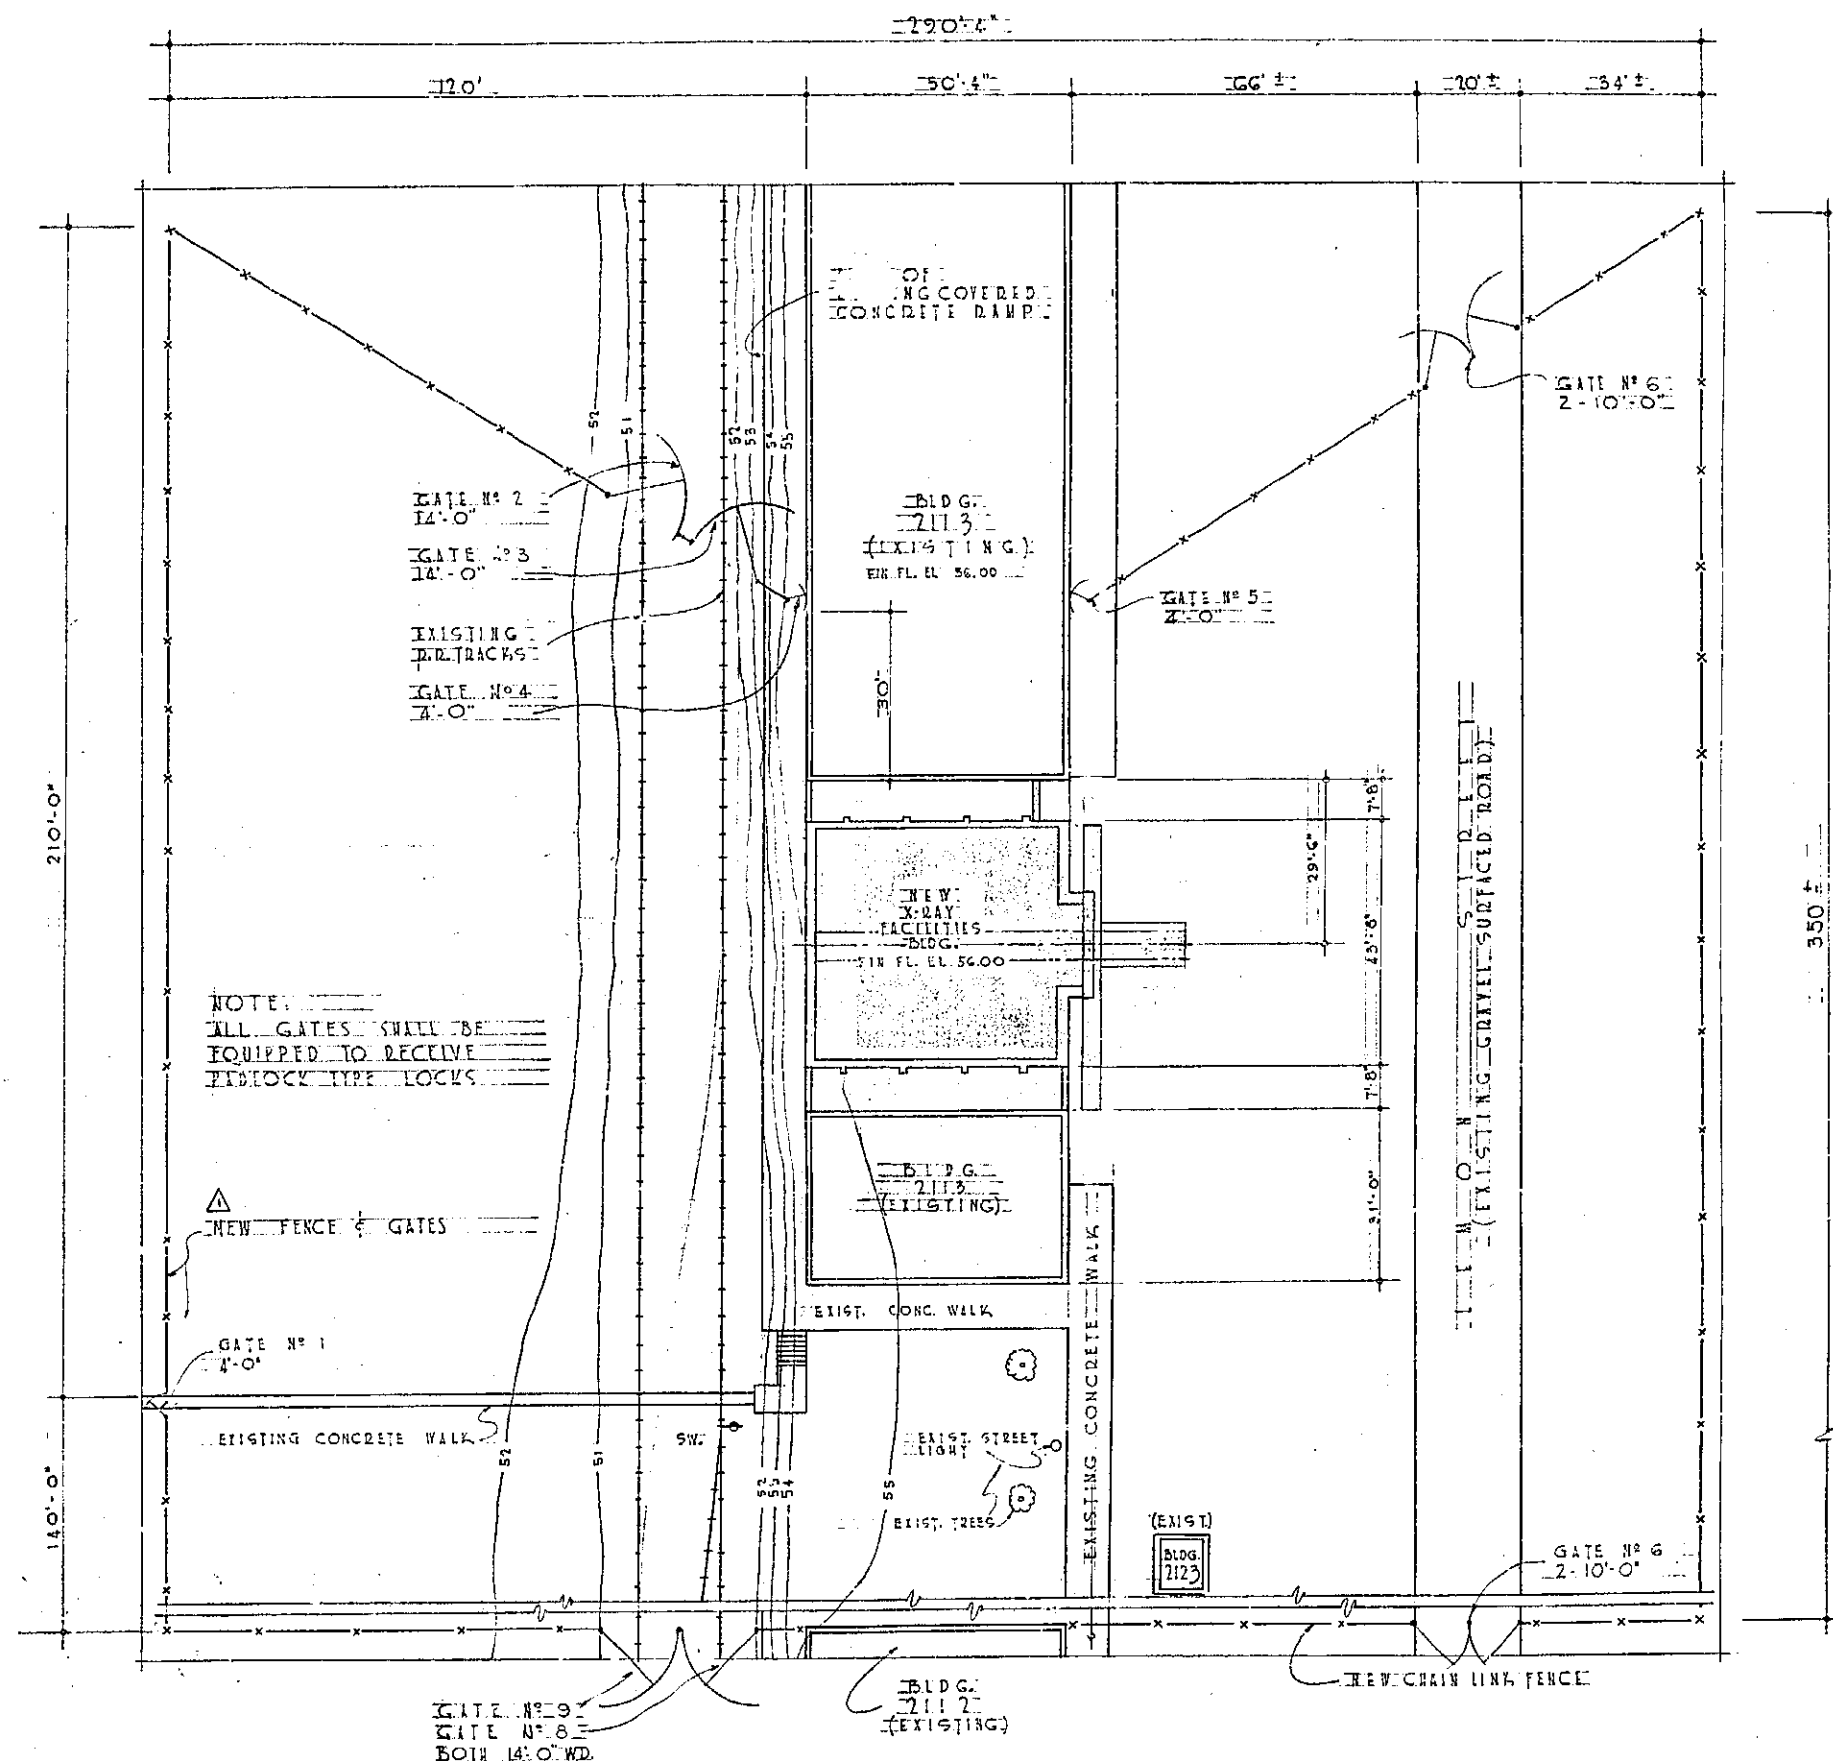


PLOT PLAN
SCALE 1" = 20'

DESIGN CHECK

CIVIL	W.F.	13 Dec 57
MECHANICAL	R.H.T.	13 Dec 57
STRUCTURAL	W.F.	13 Dec 57
ELECTRICAL	W.F.	13 Dec 57
ARCHITECTURAL	W.F.	13 Dec 57
DESIGN CHIEF		

REVISION	DATE	DESCRIPTION
1	4-15-58	CERIAL REVISIONS
DEPARTMENT OF THE AIR FORCE OGDEN AIR MATERIAL AREA OFFICE OF INSTALLATIONS OGDEN, UTAH		
HILL AIR FORCE BASE DESIGNED BY: J.L. McCLINTOCK DRAWN BY: J.L. McCLINTOCK TRACED BY: J.L. McCLINTOCK CHECKED BY: J.L. McCLINTOCK		
MODIFICATION OF BUILDING NO 2113 FOR X-RAY FACILITIES PLOT PLAN & UTILITY LAYOUT		
PROJECT NO. 411-29-8		DRAWING NUMBER 58-3866
SHEET 2 OF 11 SCALE NOTED		49-78

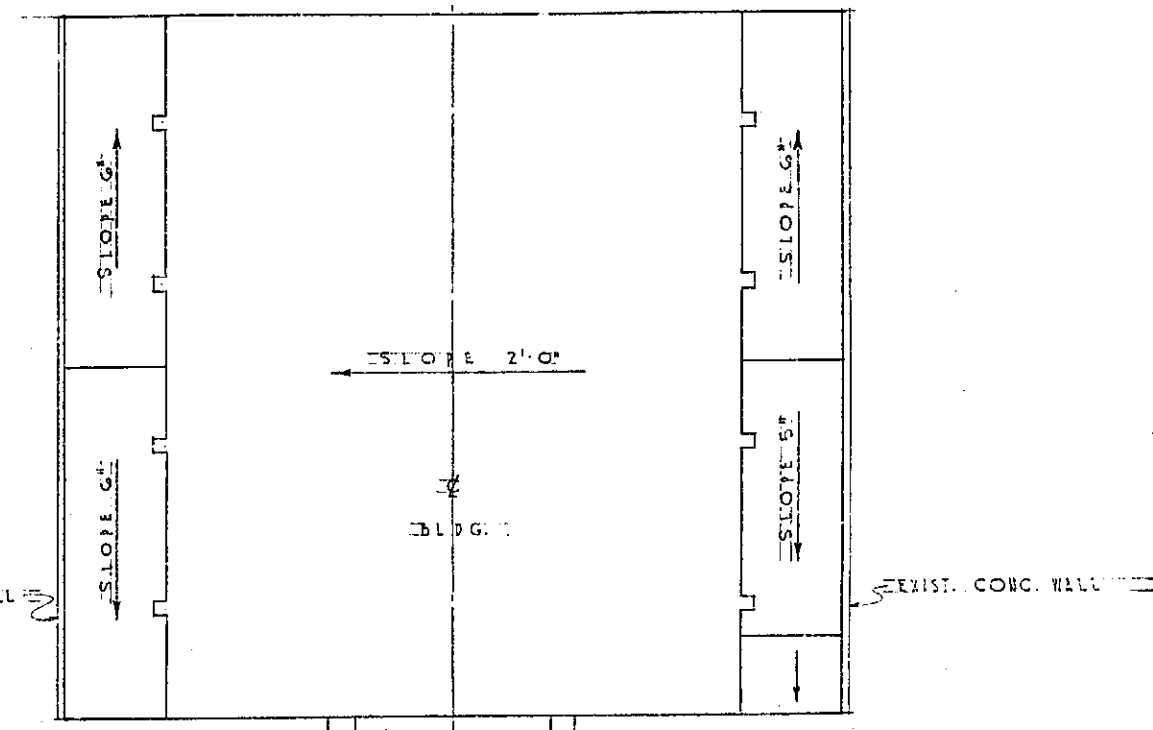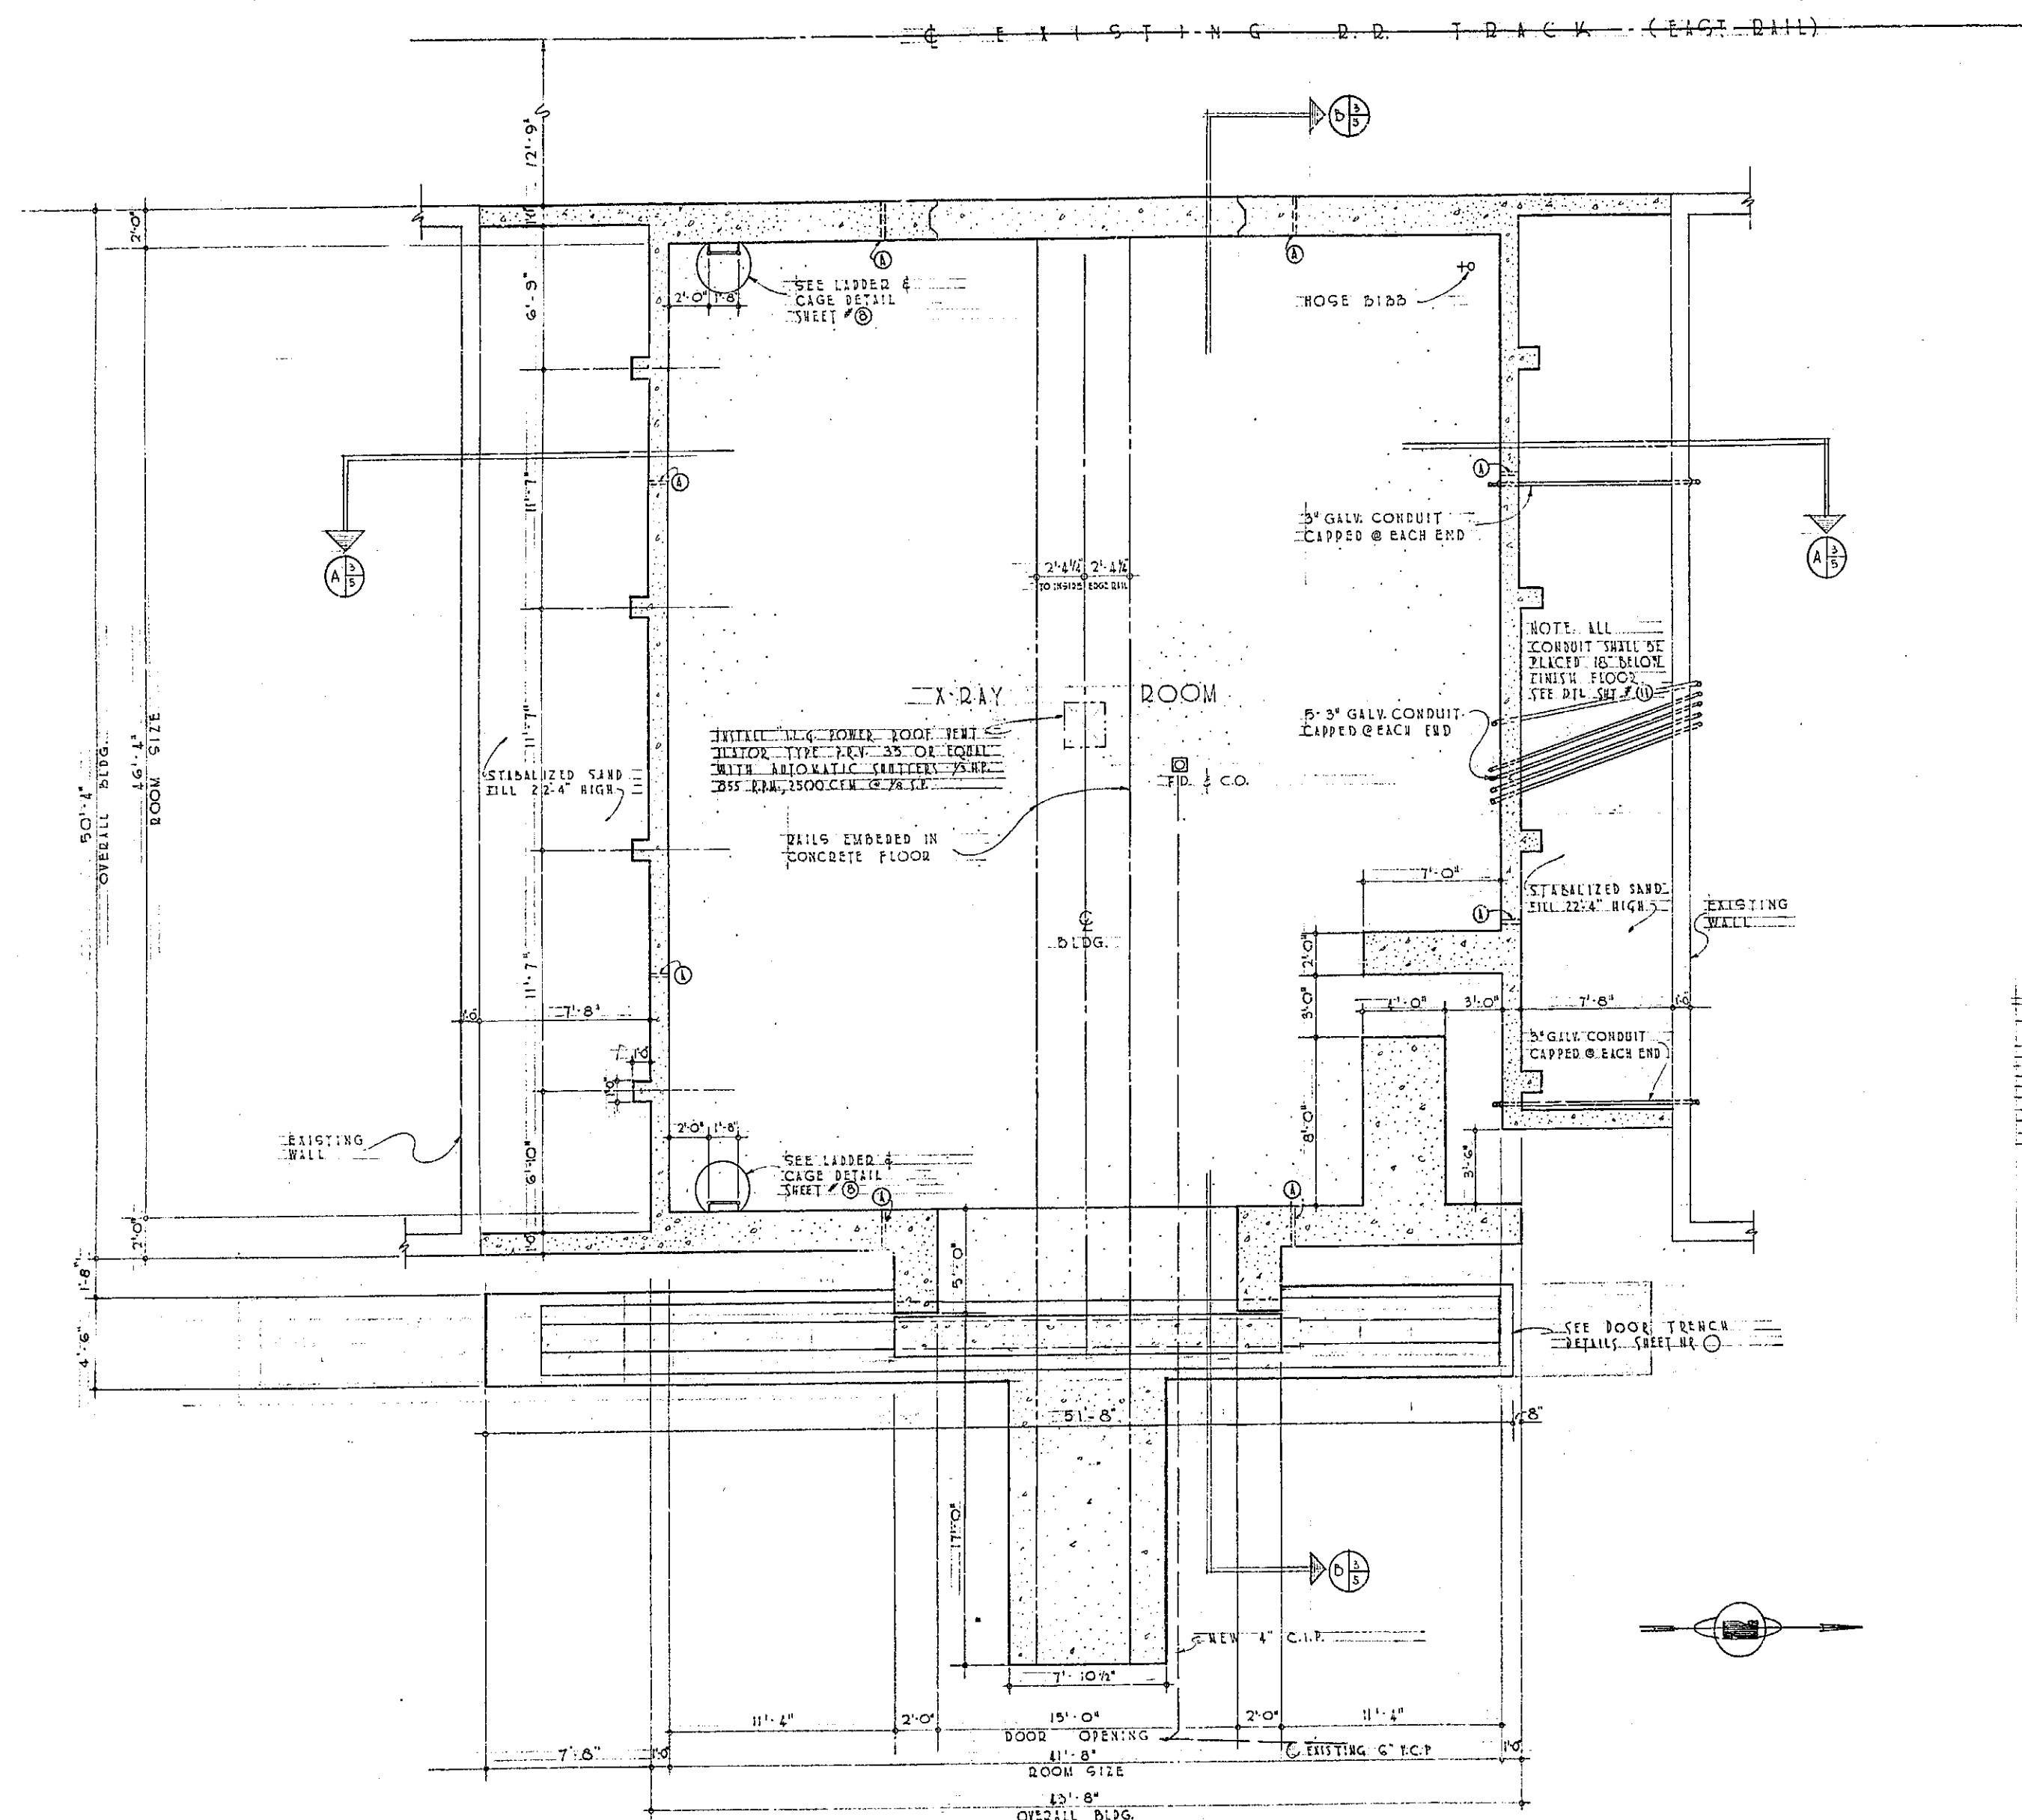


- GENERAL NOTES**
- 1. ① DESIGNATES 2 1/2" RIGID CONDUIT TRIM WITH 22.4" ABOVE FINISH FLOOR. SLOPE 1/4" TO OUTSIDE WALL.
 - 2. SOIL BEARING DESIGN CAPACITY 4,000 P.S.F.
 - 3. CONCRETE 3,000 P.S.F. 1350 P.S.F.
 - 4. STEEL 20,000 P.S.F.


FLOOR PLAN
SCALE 1/4" = 1'-0"

REVISION	DATE	DESCRIPTION	BY
2-14-58 GENERAL REVISIONS			
DEPARTMENT OF THE AIR FORCE OGDEN AIR MATERIAL AREA OFFICE OF INSTALLATIONS			
HILL AIR FORCE BASE			
OGDEN, UTAH			
DESIGNED BY G. L. JOHNS			
DRAWN BY L. G. SHIELDS			
TRACED BY F. B. 1954			
CHECKED BY			
APPROVED BY DATE			
APPROVAL RECOMMENDED			
APPROVED			
PROJECT NO. HPL 29-8			
DRAWING NUMBER			
58-3866			
SHEET ⑤ OF 11 SCALE 1/4" = 1'-0"			


2113-58-A

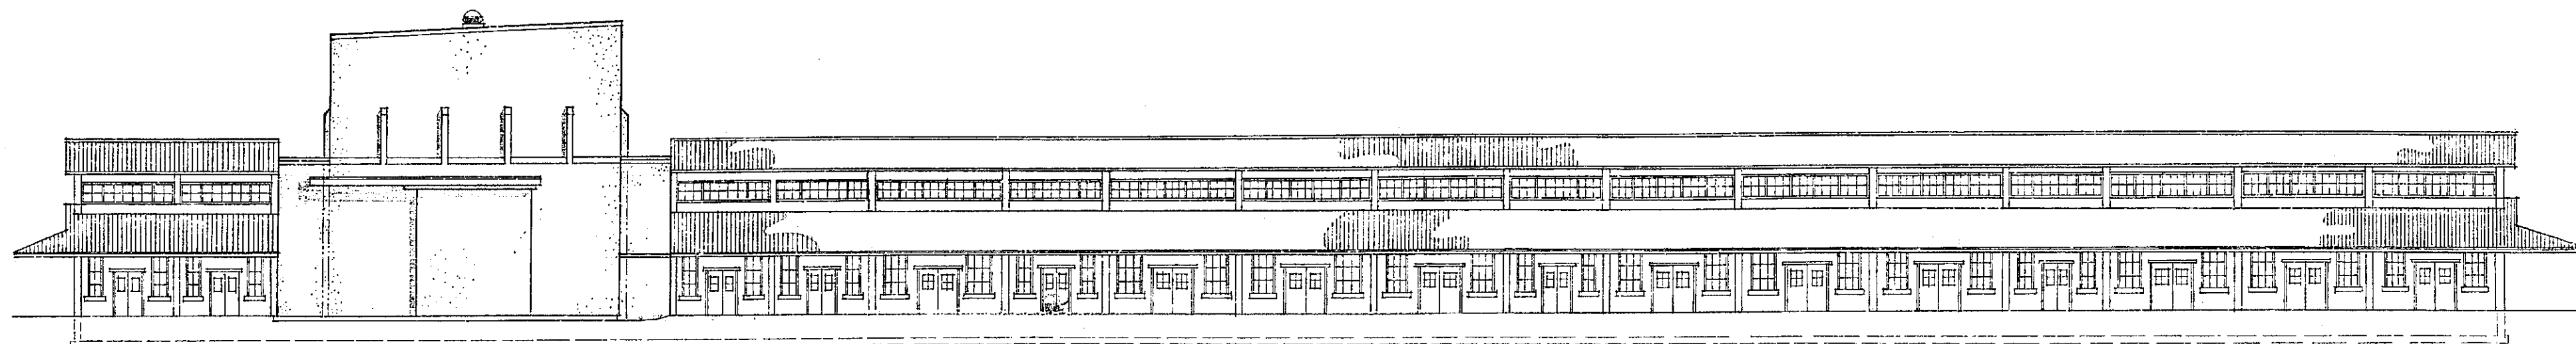

EAST ELEVATION
SCALE 1/32" = 1'-0"

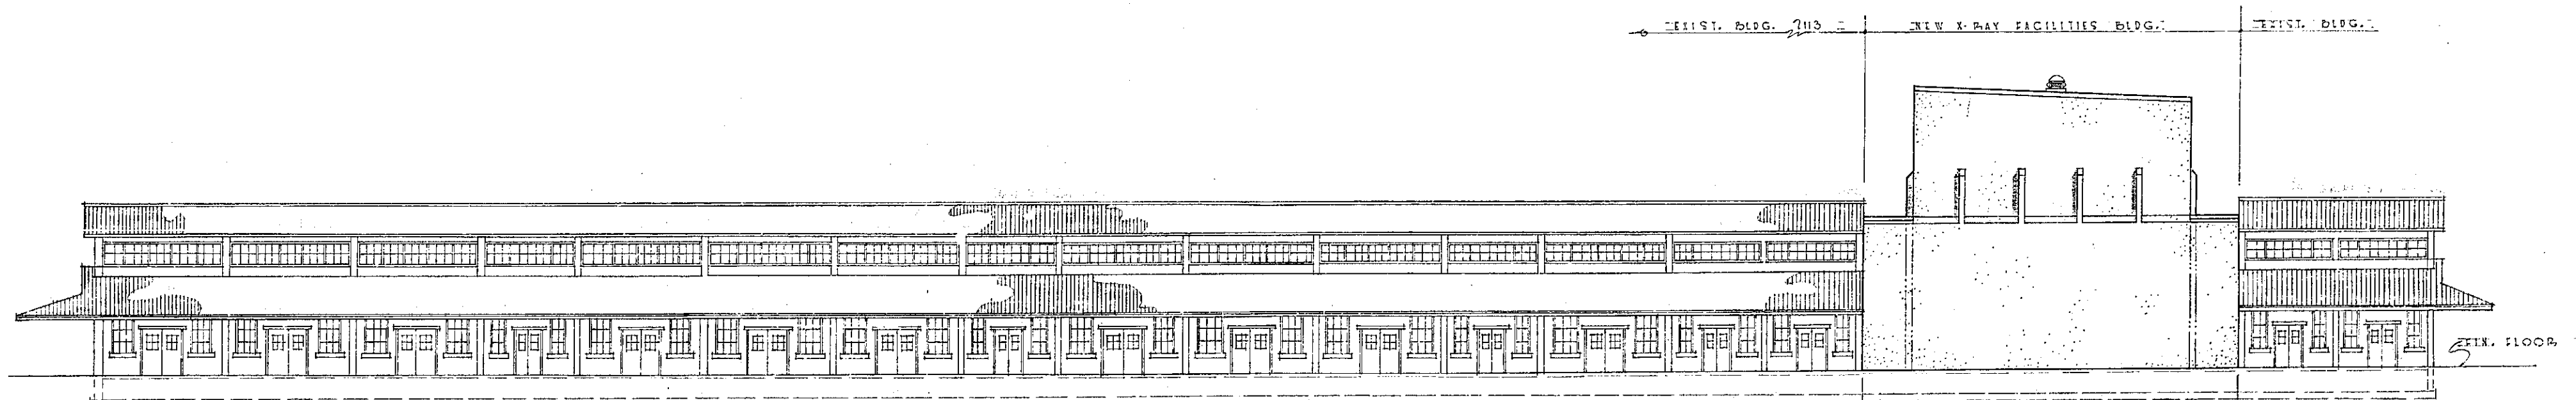

WEST ELEVATION
SCALE 1/32" = 1'-0"

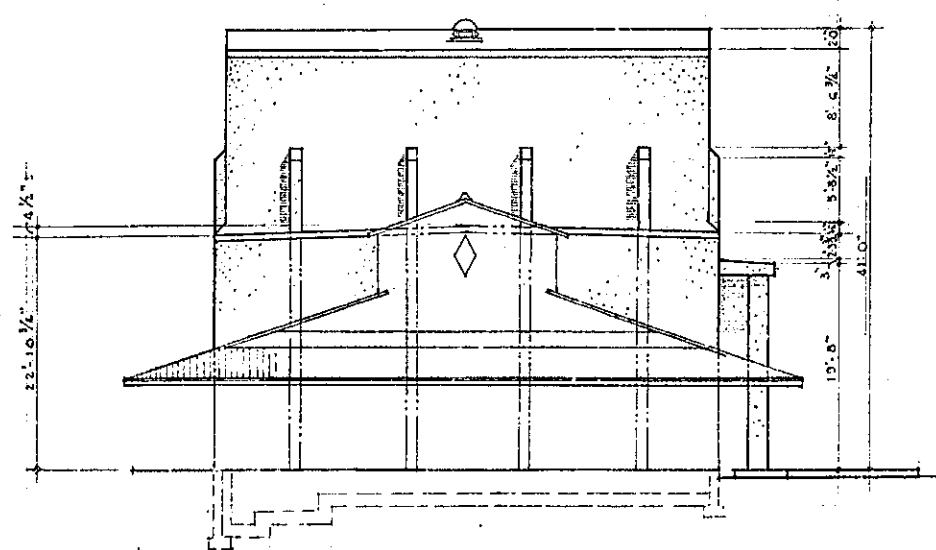


SOUTH ELEVATION
SCALE 1/32" = 1'-0"
(NORTH ELEVATION SIMILAR)

1-14-58		GENERAL REVISIONS		697
REVISION	DATE	DESCRIPTION		BY
DEPARTMENT OF THE AIR FORCE OGDEN AIR MATERIAL AREA OFFICE OF INSTALLATIONS OGDEN, UTAH				
DESIGNED BY E. L. JONES		MODIFICATION OF BLDG. NO. 2113 FOR		
DRAWN BY J. M. GILKIN		X-RAY FACILITIES		
TRACED BY J. L. B. 1958		ELEVATIONS		
CHECKED BY	DATE			
APPROVED BY	DATE			
SUBMITTED		APPROVAL RECOMMENDED		APPROVED
DATE 12/14/58		DATE 12/14/58		DATE 12/14/58
PROJECT NO.		DRAWING NUMBER		
58-3866		58-3866		
SHEET 1 OF 1		SCALE 1/32" = 1'-0"		





49-82

2113-58-A

264

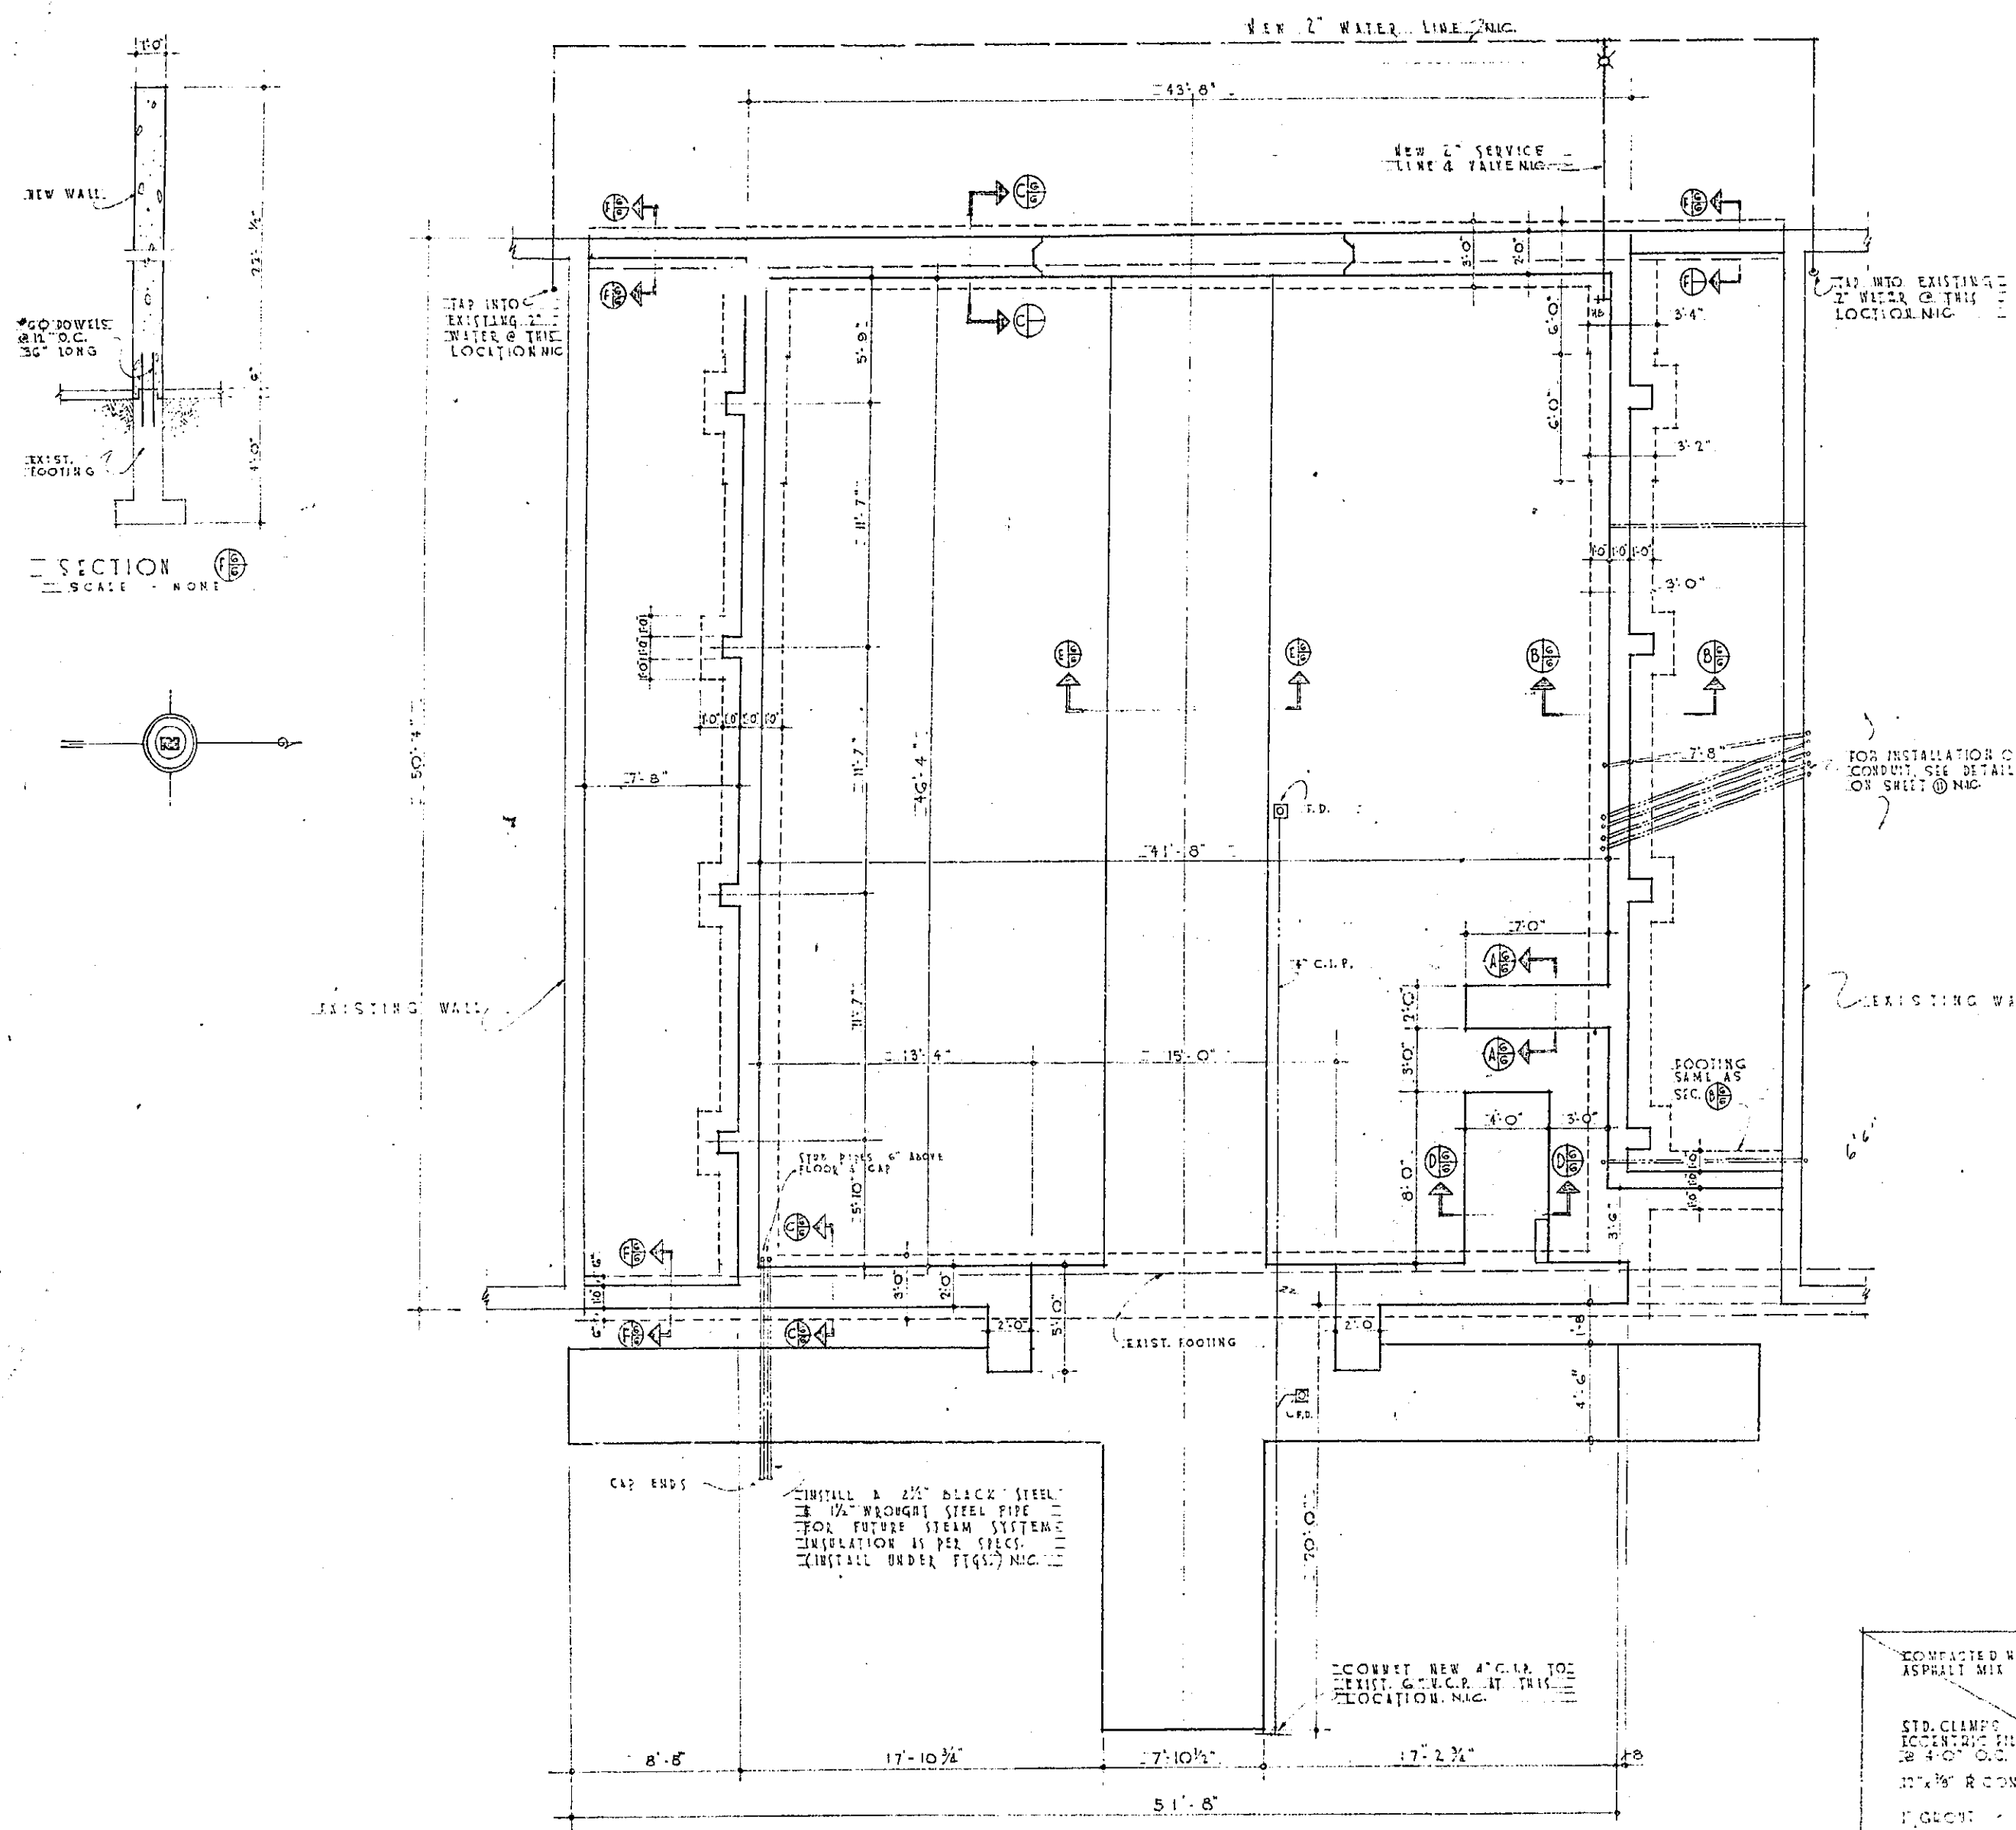

FOOTING & FOUNDATION PLAN
SCALE 1/4" = 1'-0"

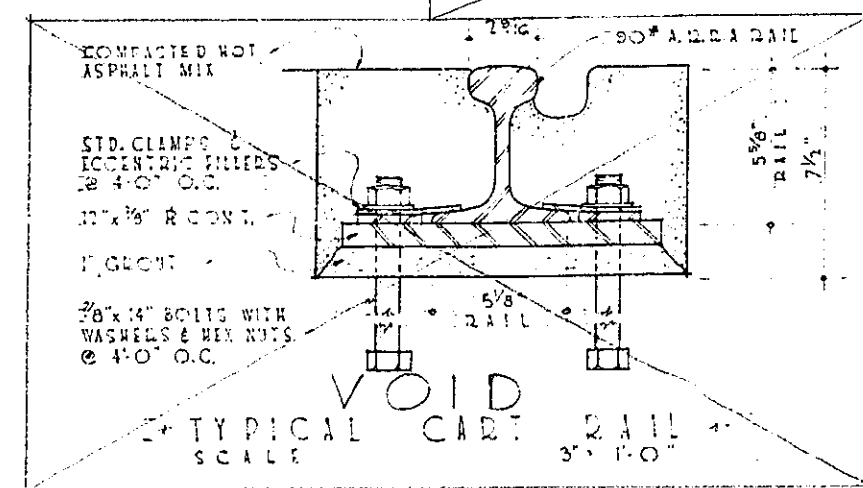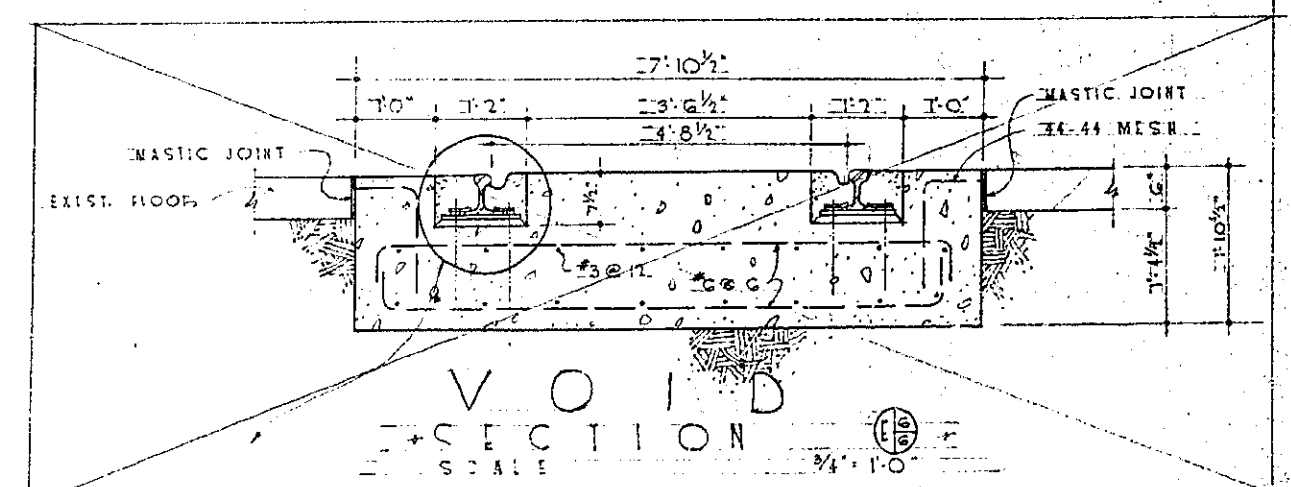
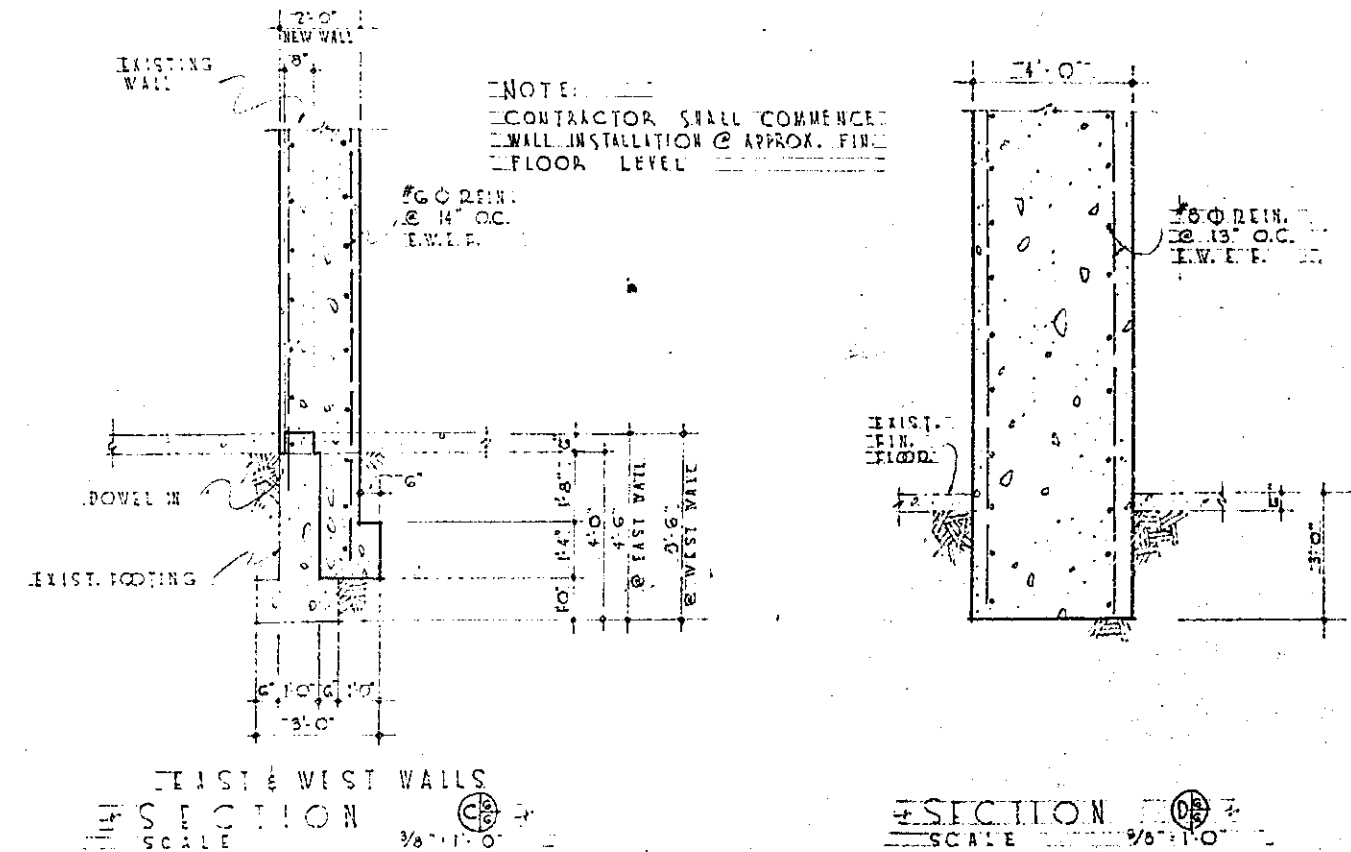
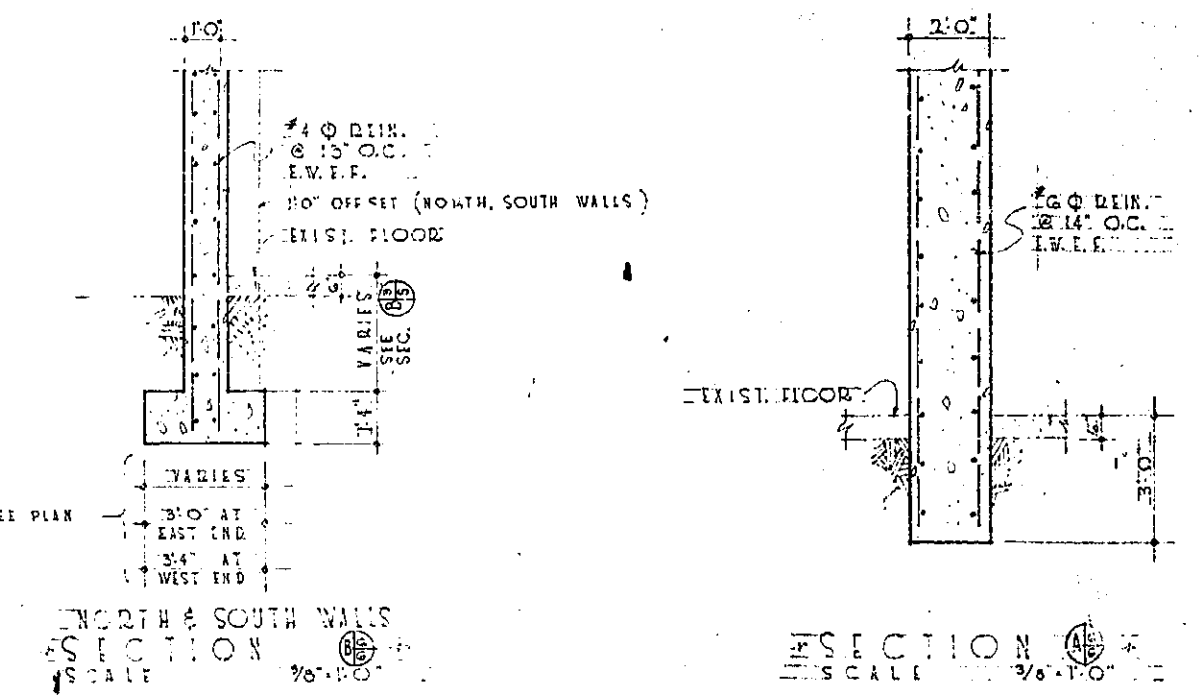


REVISION	DATE	DESCRIPTION	BY
DEPARTMENT OF THE AIR FORCE OGDEN AIR MATERIAL AREA OFFICE OF INSTALLATIONS OGDEN, UTAH			
HILL AIR FORCE BASE DESIGNED BY: J. J. JOHNS DRAWN BY: J. A. JOHNS TRACED BY: J. A. JOHNS CHECKED BY: J. A. JOHNS APPROVED BY: J. A. JOHNS SUBMITTED: J. A. JOHNS APPROVED: J. A. JOHNS DATE: 18 Feb 58			
MODIFICATION OF BUILDING #213 FOR X-RAY FACILITIES FOOTING FOUNDATION PLAN & DETAILS			
PROJECT NO. 49-85 DRAWING NUMBER 58 3866 SHEET 16 OF 11 SCALE 1/4" = 1'-0"			

49-85


CONTRACT DRAWINGS

2113-58-A

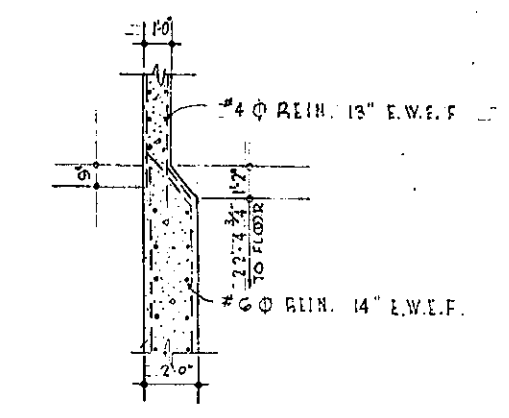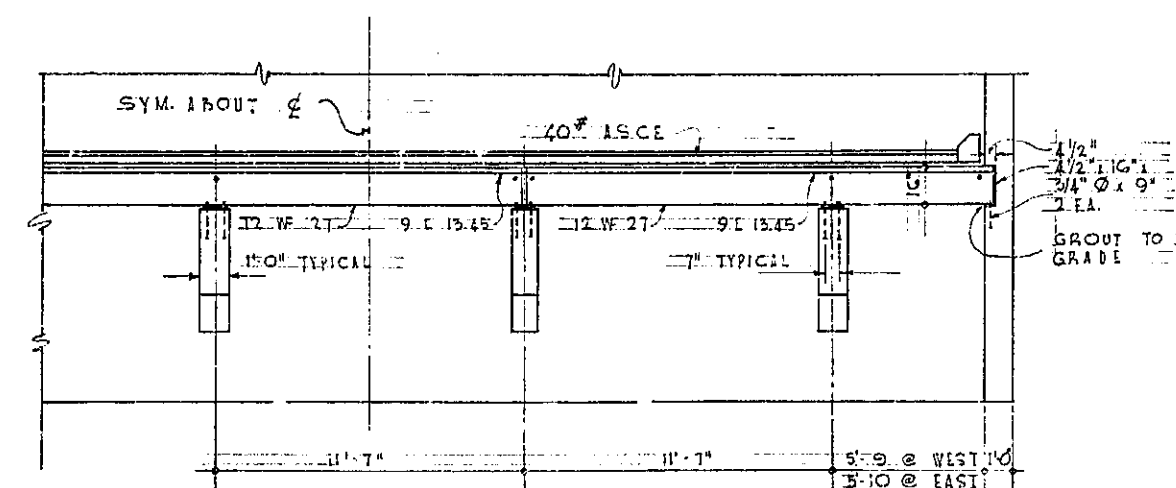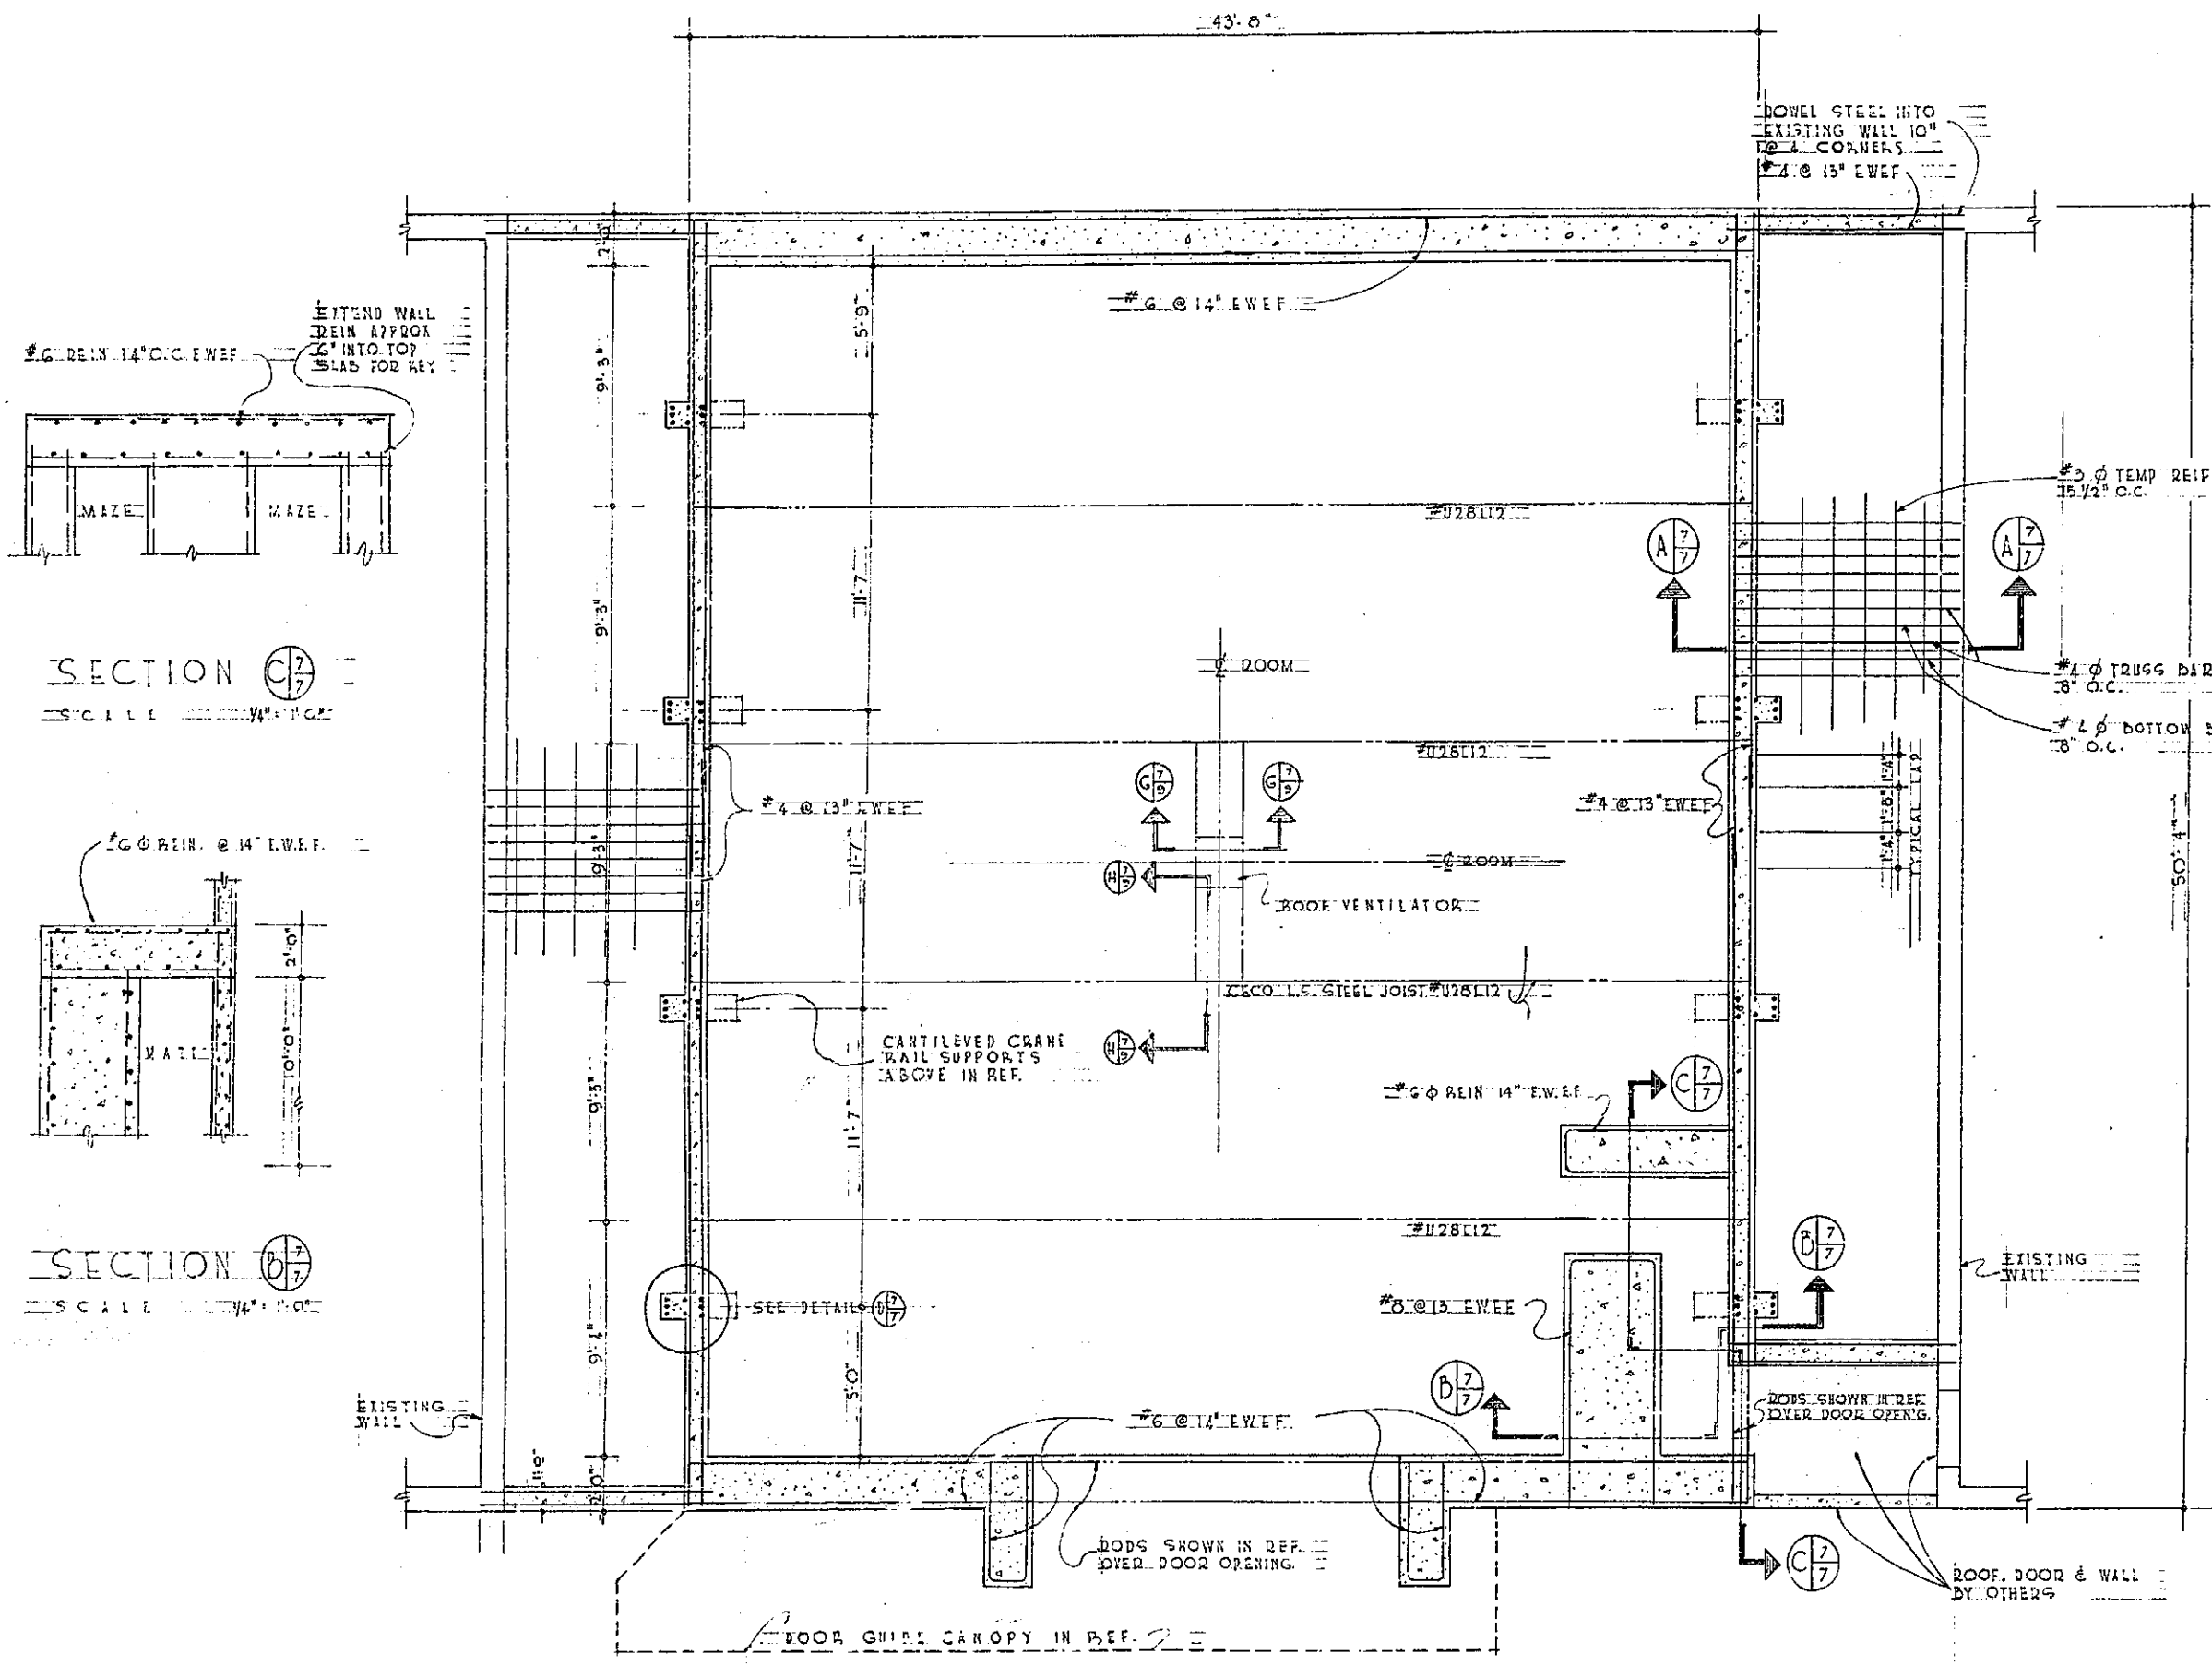


EAST & WEST WALLS
SCALE 1/4\"/>


ELEVATION OF CRANE RAIL SUPPORTS
SCALE 1/4\"/>

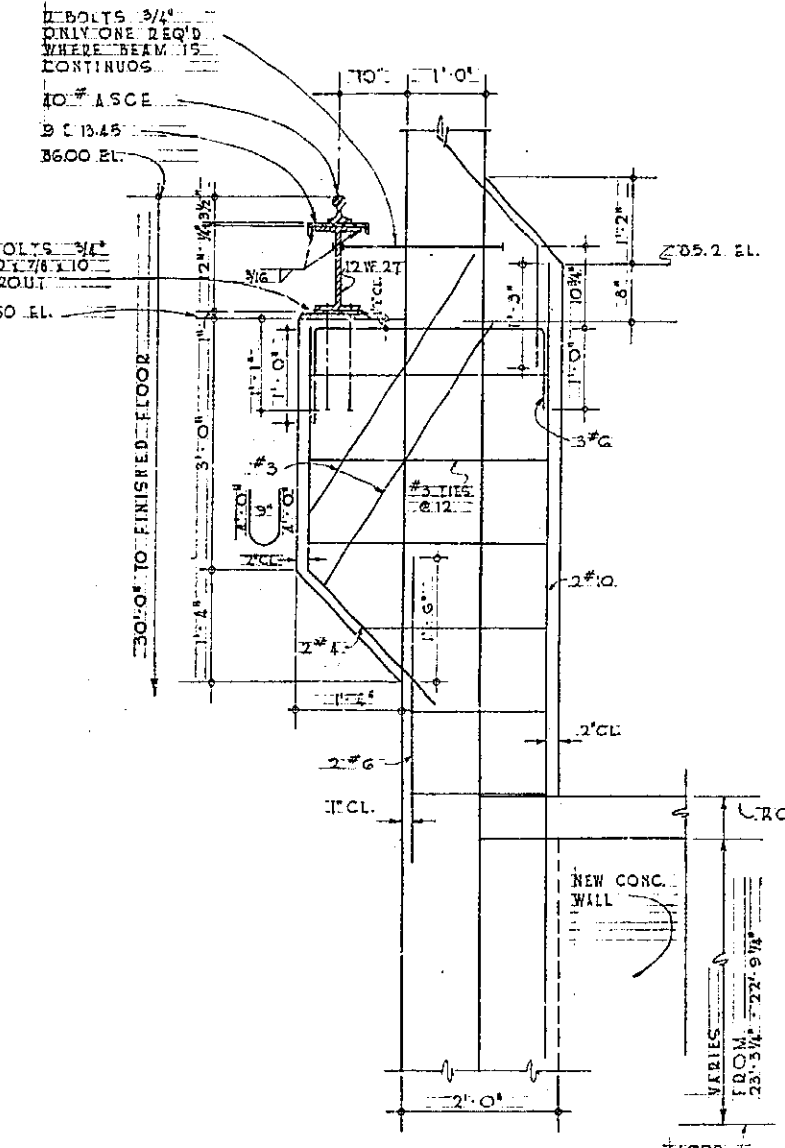


SECTION C-C
SCALE 1/4\"/>

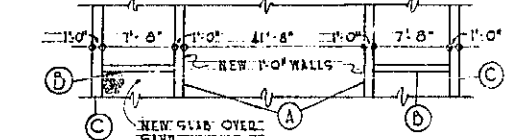

SECTION A-A
SCALE 1/4\"/>

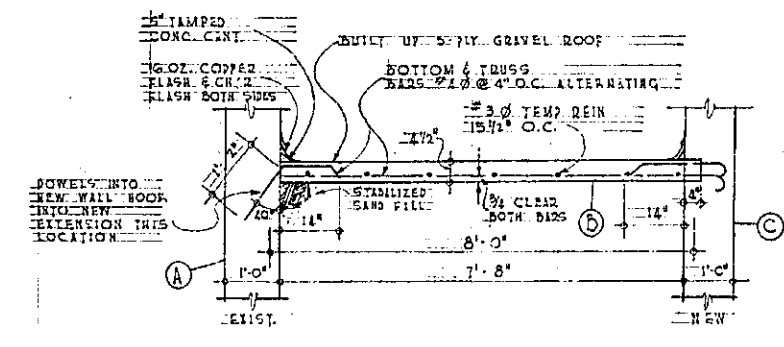

SECTION A-A TIE SLAB OVER STABILIZED SAND
SCALE 1/4\"/>

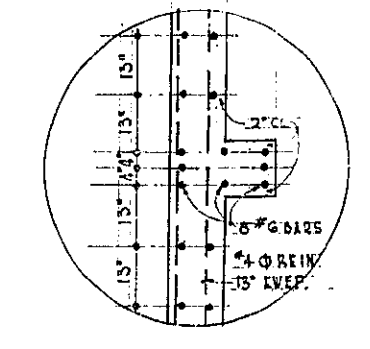

DETAIL D-7
SCALE 1/2\"/>


WALL REINFORCING & ROOF FRAMING
SCALE 1/4\"/>

REVISION	DATE	DESCRIPTION	BY
1	2-14-58	GENERAL REVISIONS	G.C.


HILL AIR FORCE BASE DESIGNED BY G.C. JOLES DRAWN BY L.G. SHILLER TRACED BY CHECKED BY APPROVED BY APPROVED DATE APPROVED DATE APPROVED DATE		DEPARTMENT OF THE AIR FORCE OGDEN AIR MATERIAL AREA OFFICE OF INSTALLATIONS OGDEN, UTAH MODIFICATION OF BUILDING NO 2113 FOR X-RAY FACILITIES WALL REINFORCING & CEILING FRAMING PLAN PROJECT NO. HIL 29-8 DRAWING NUMBER 58-3866 SHEET 1 OF 11 SCALE NOTED	
---	--	---	--

49-88


2113-58-A

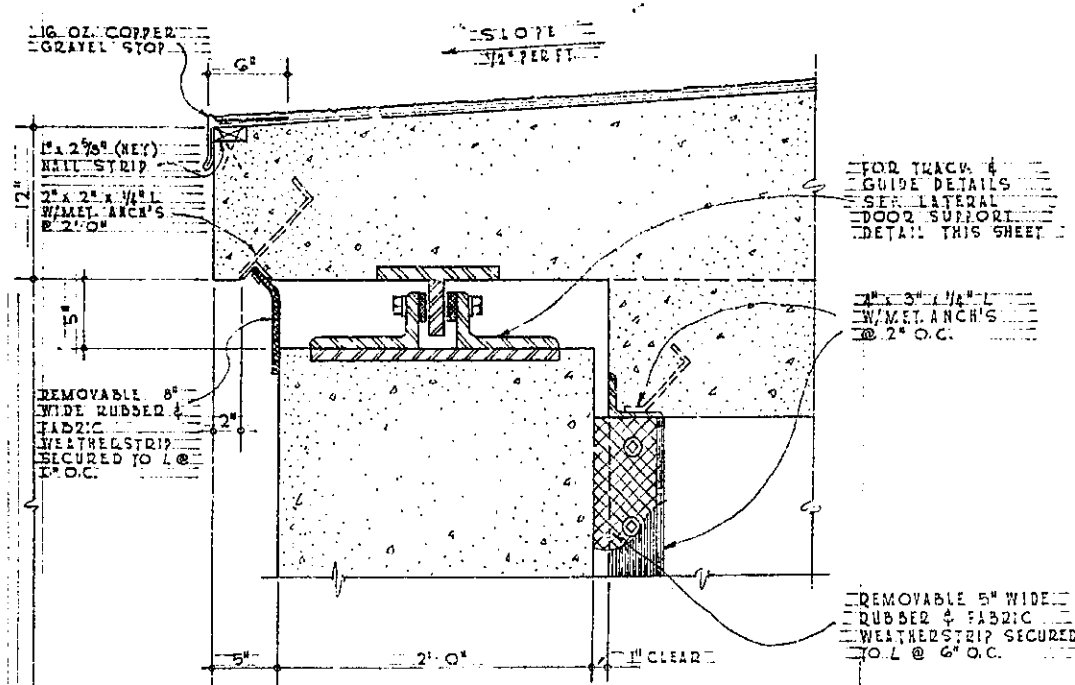


DETAIL @ DOOR HEAD
SCALE: 1/2" = 1'-0"

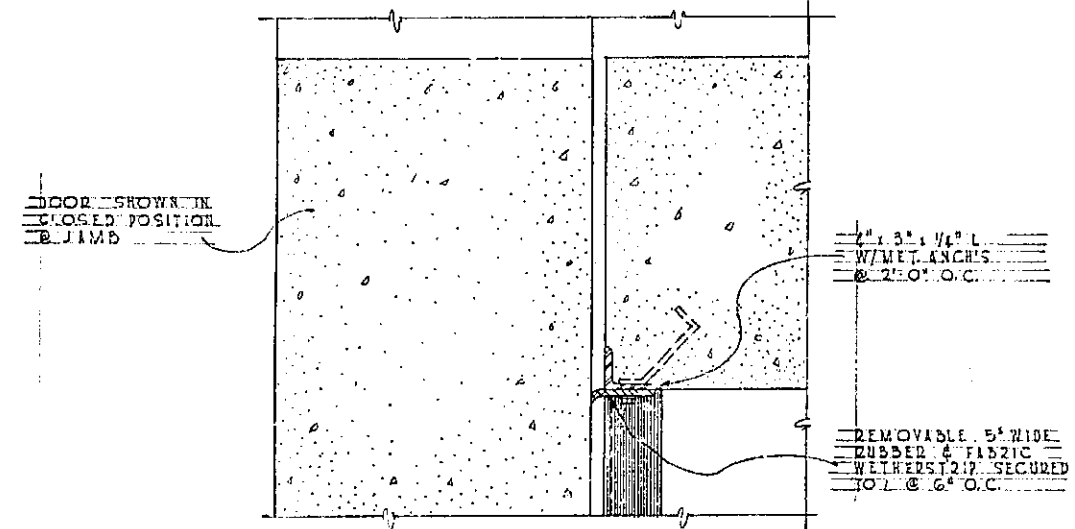


DETAIL @ DOOR JAMB
SCALE: 1/2" = 1'-0"

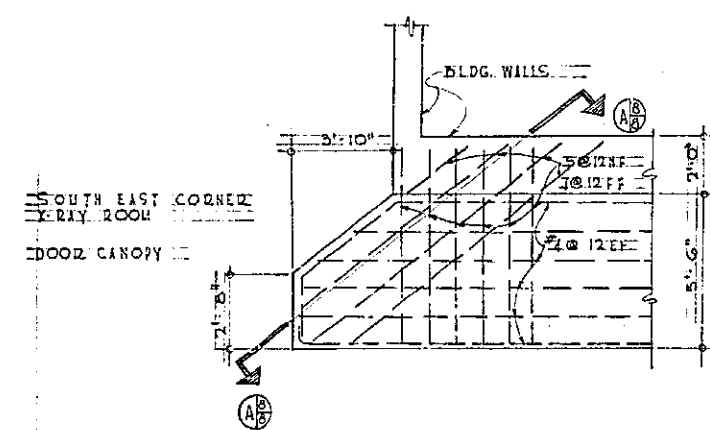


REIN DETAIL S.E. CORNER DOOR CANOPY
SCALE: 1/2" = 1'-0"

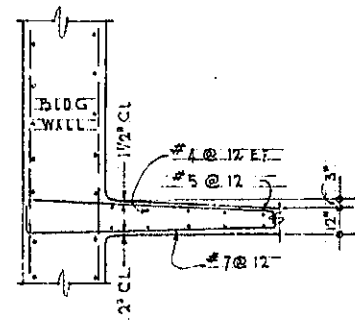


SECTION 15
SCALE: 1/2" = 1'-0"

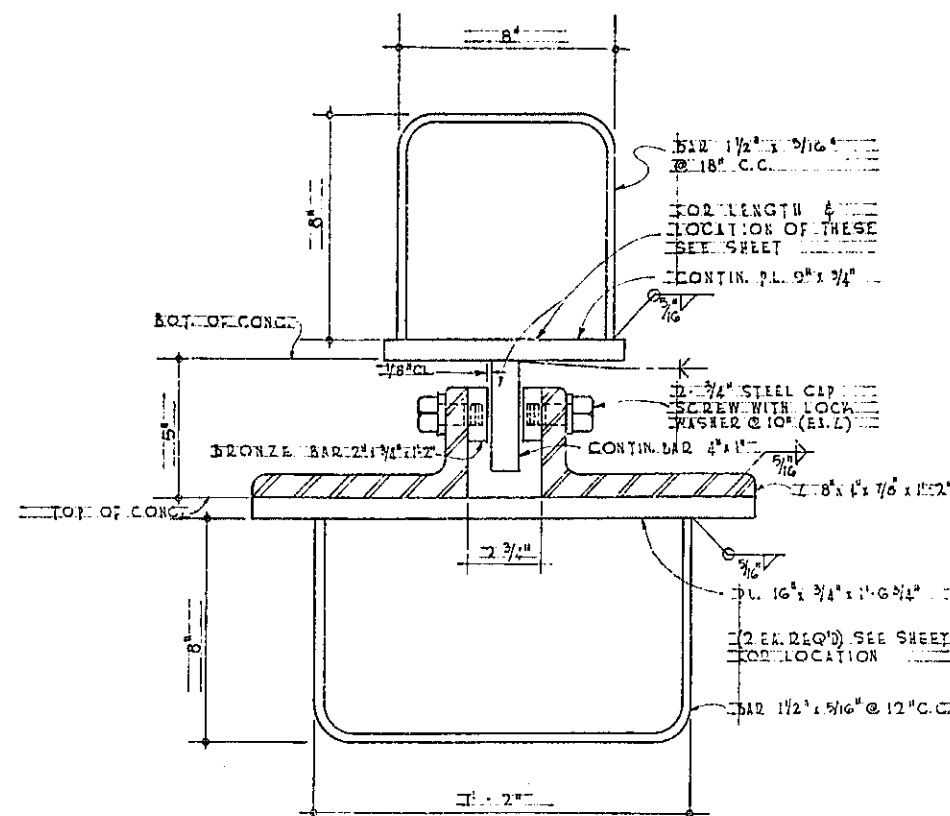


LATERAL DOOR SUPPORT
SCALE: 1/2" = 1'-0"

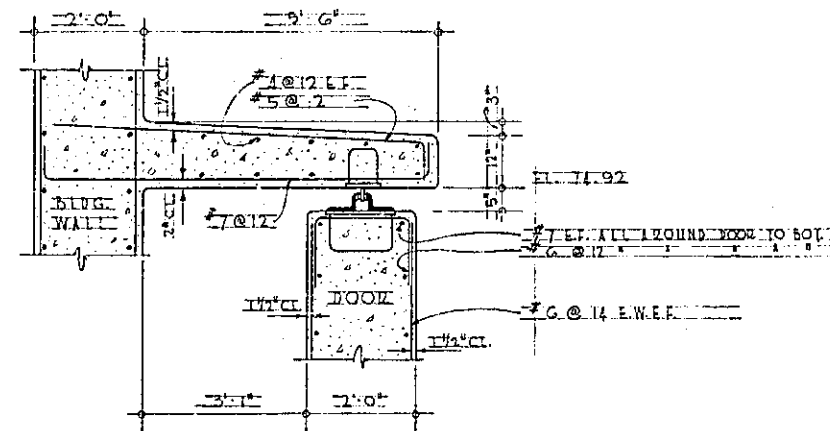


AT WALL
SCALE: 1/2" = 1'-0"

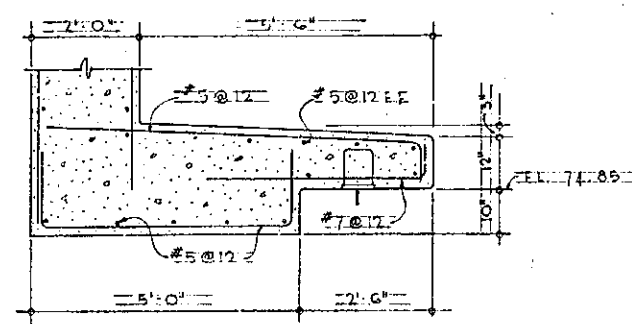


AT DOOR OPENING
SCALE: 1/2" = 1'-0"

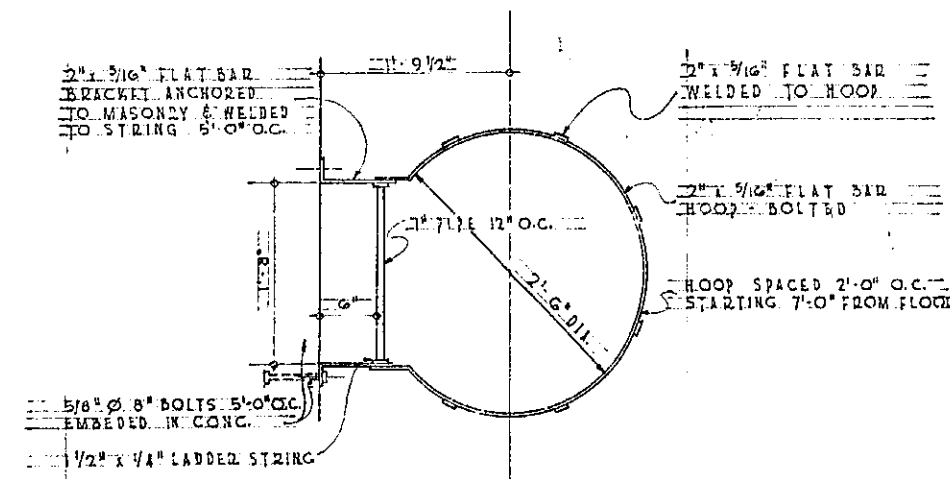

GUARD RAILING FOR ESCAPE LADDER
SCALE: 1/2" = 1'-0"

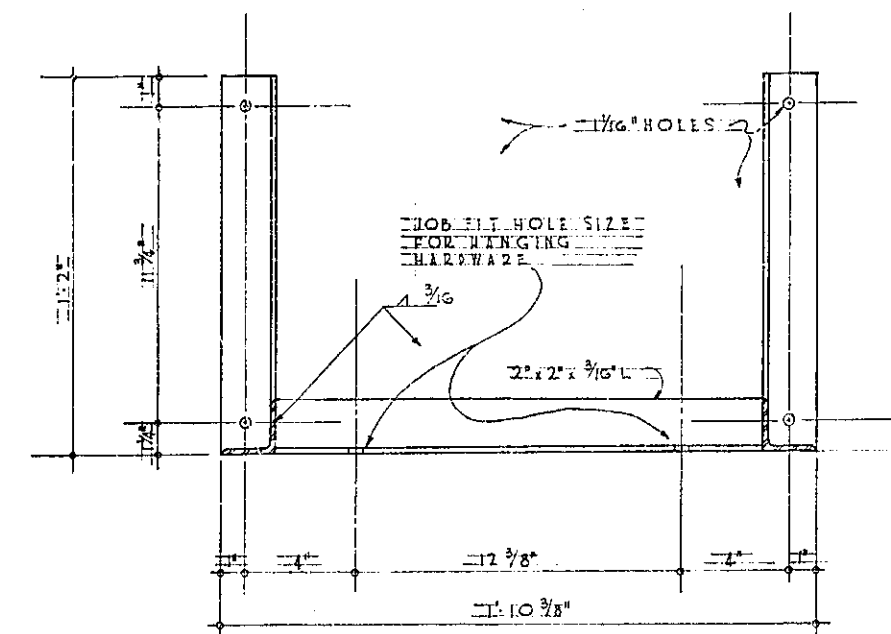


FRONT VIEW
SCALE: 1/2" = 1'-0"

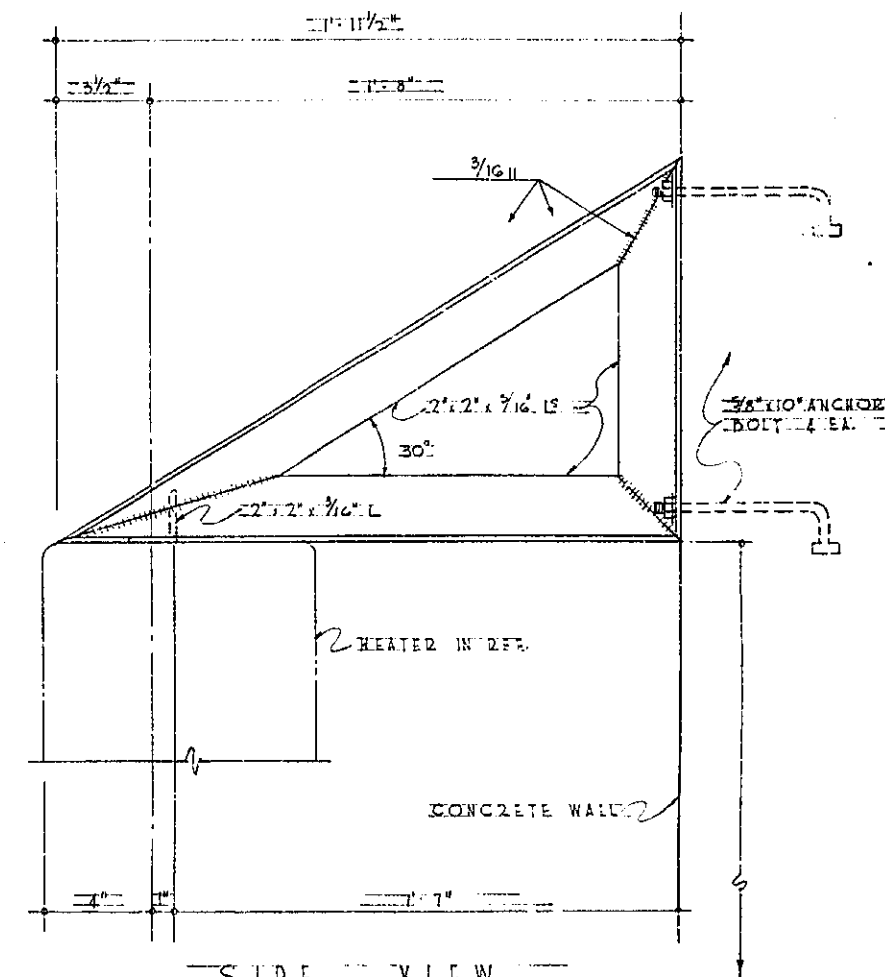

SIDE VIEW
SCALE: 1/2" = 1'-0"


HEATED BRACKET DETAIL
SCALE: 1/2" = 1'-0"

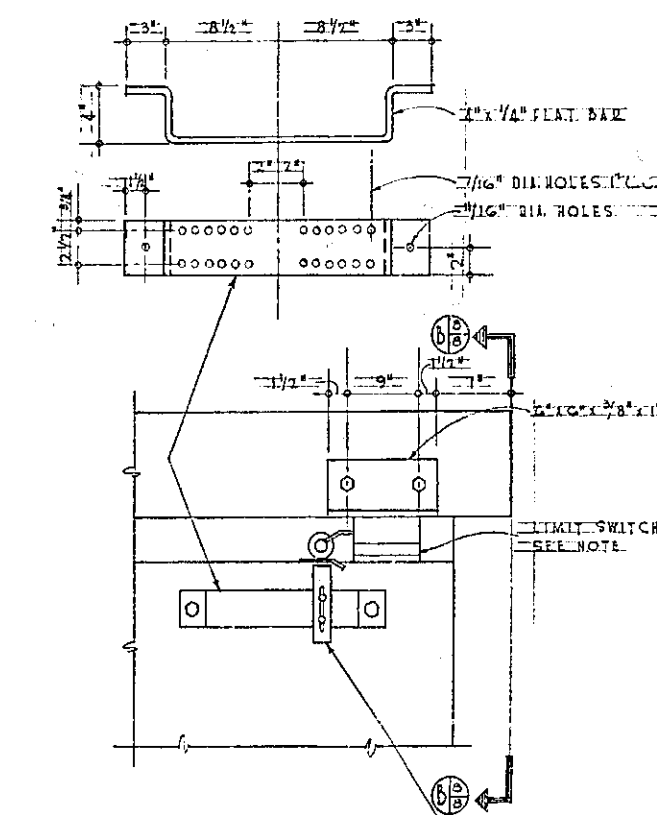

DETAIL DOOR FULLY CLOSED
SCALE: 1/2" = 1'-0"

LIMIT SWITCH SHALL BE ADJUSTED WITH STEEL ROLLER AND R.N.O. AND R.G. CONTACTS ADJUSTED TO CARRY 5A CONTINUOUSLY AND INTERRUPT 10A AT 120 V.M.P. C.F. ENCLOSURE

2\"/>

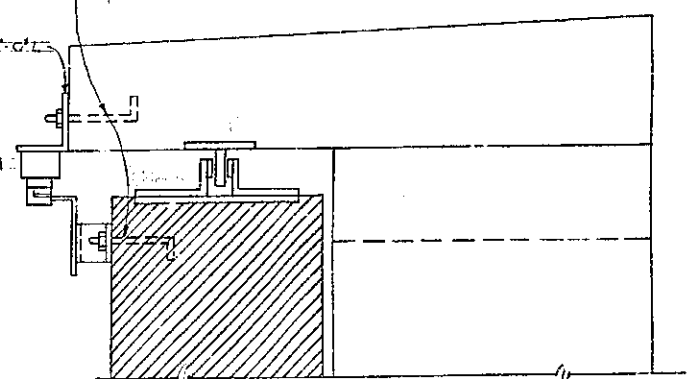


ELEVATION 16
SCALE: 1/2" = 1'-0"


REVISION	DATE	DESCRIPTION	BY
DEPARTMENT OF THE AIR FORCE OGDEN AIR MATERIAL AREA OFFICE OF INSTALLATIONS			
HILL AIR FORCE BASE			
DESIGNED BY: G. J. JONES DRAWN BY: G. J. JONES CHECKED BY: G. J. JONES APPROVED BY: G. J. JONES			
MODIFICATION OF BUILDING NO. 2113 FOR X-RAY FACILITIES			
MISCELLANEOUS DETAILS			
APPROVED: [Signature] DATE: 12/15/58			
PROJECT NO. 4811-29-8			
DRAWING NUMBER 58-3866			
SHEET 10 OF 11 SCALE: 1/2" = 1'-0"			

49-90

2113-58-A

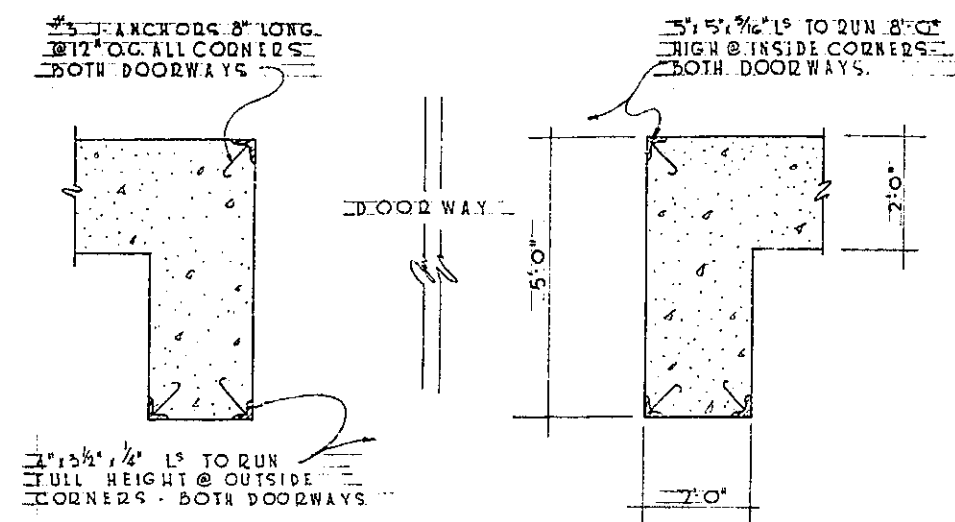


PLAN OF DOORWAY GUARDS
SCALE 1/2\"/>

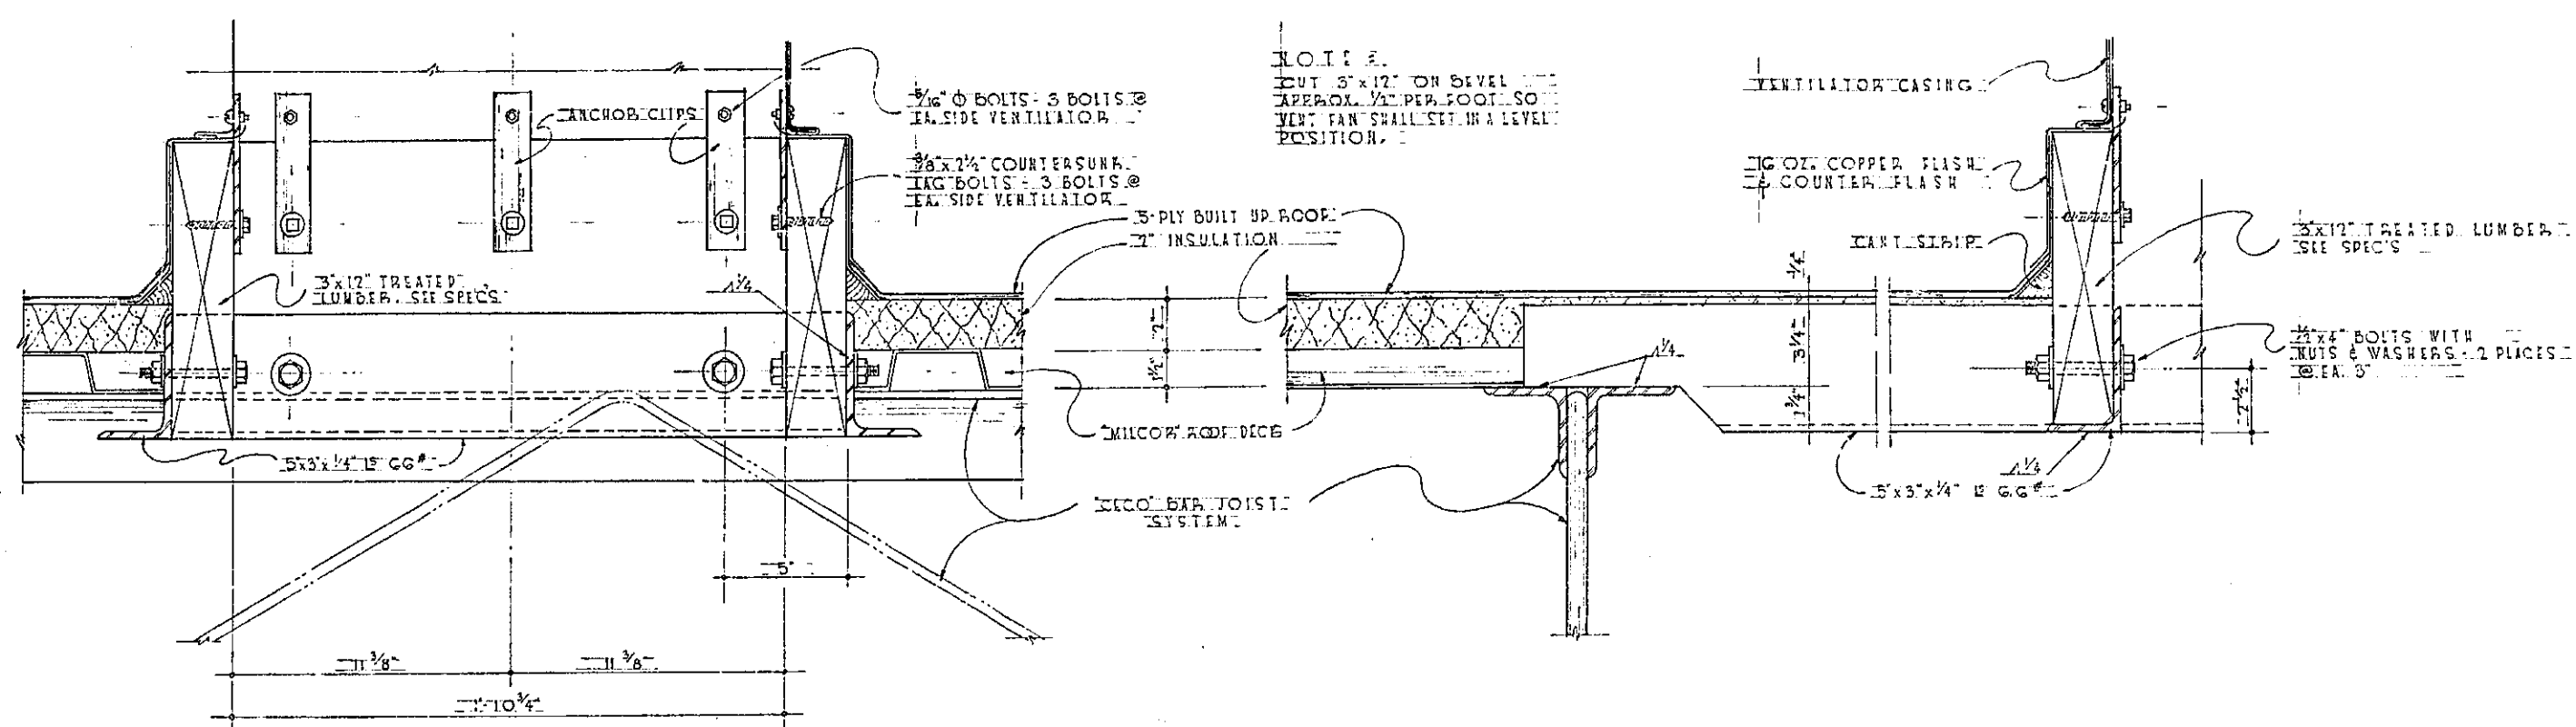


SECTION 67
SCALE 3/4\"/>


SECTION 68
SCALE 3/4\"/>

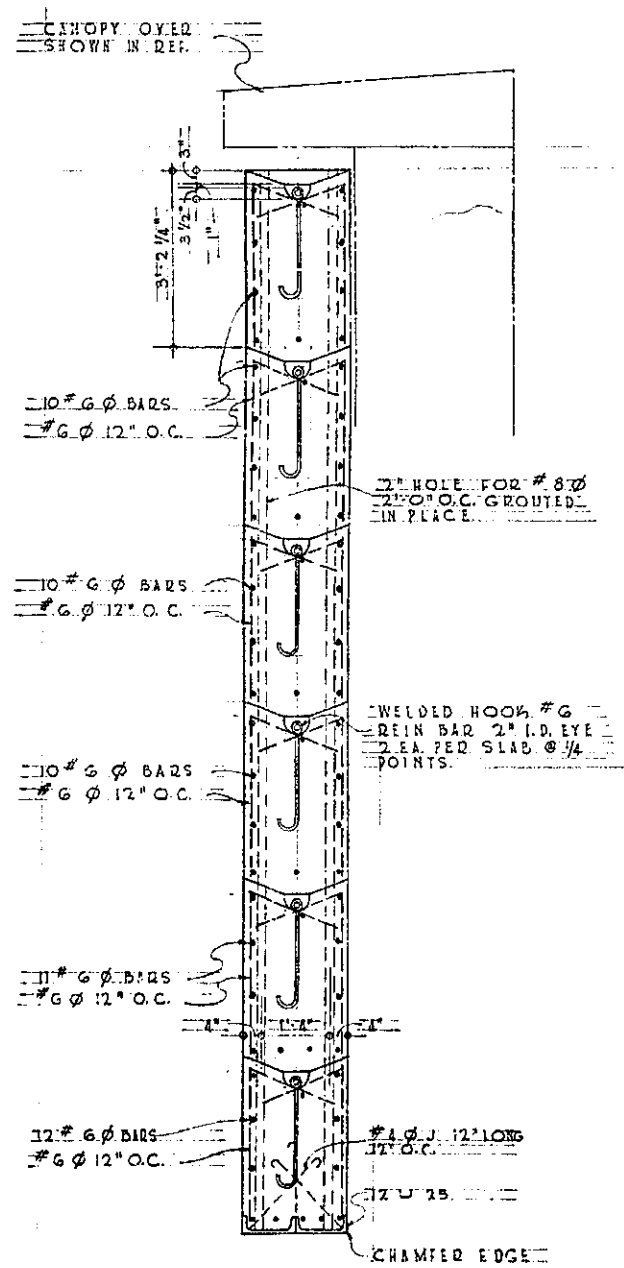

SECTION 69
SCALE 1/2\"/>

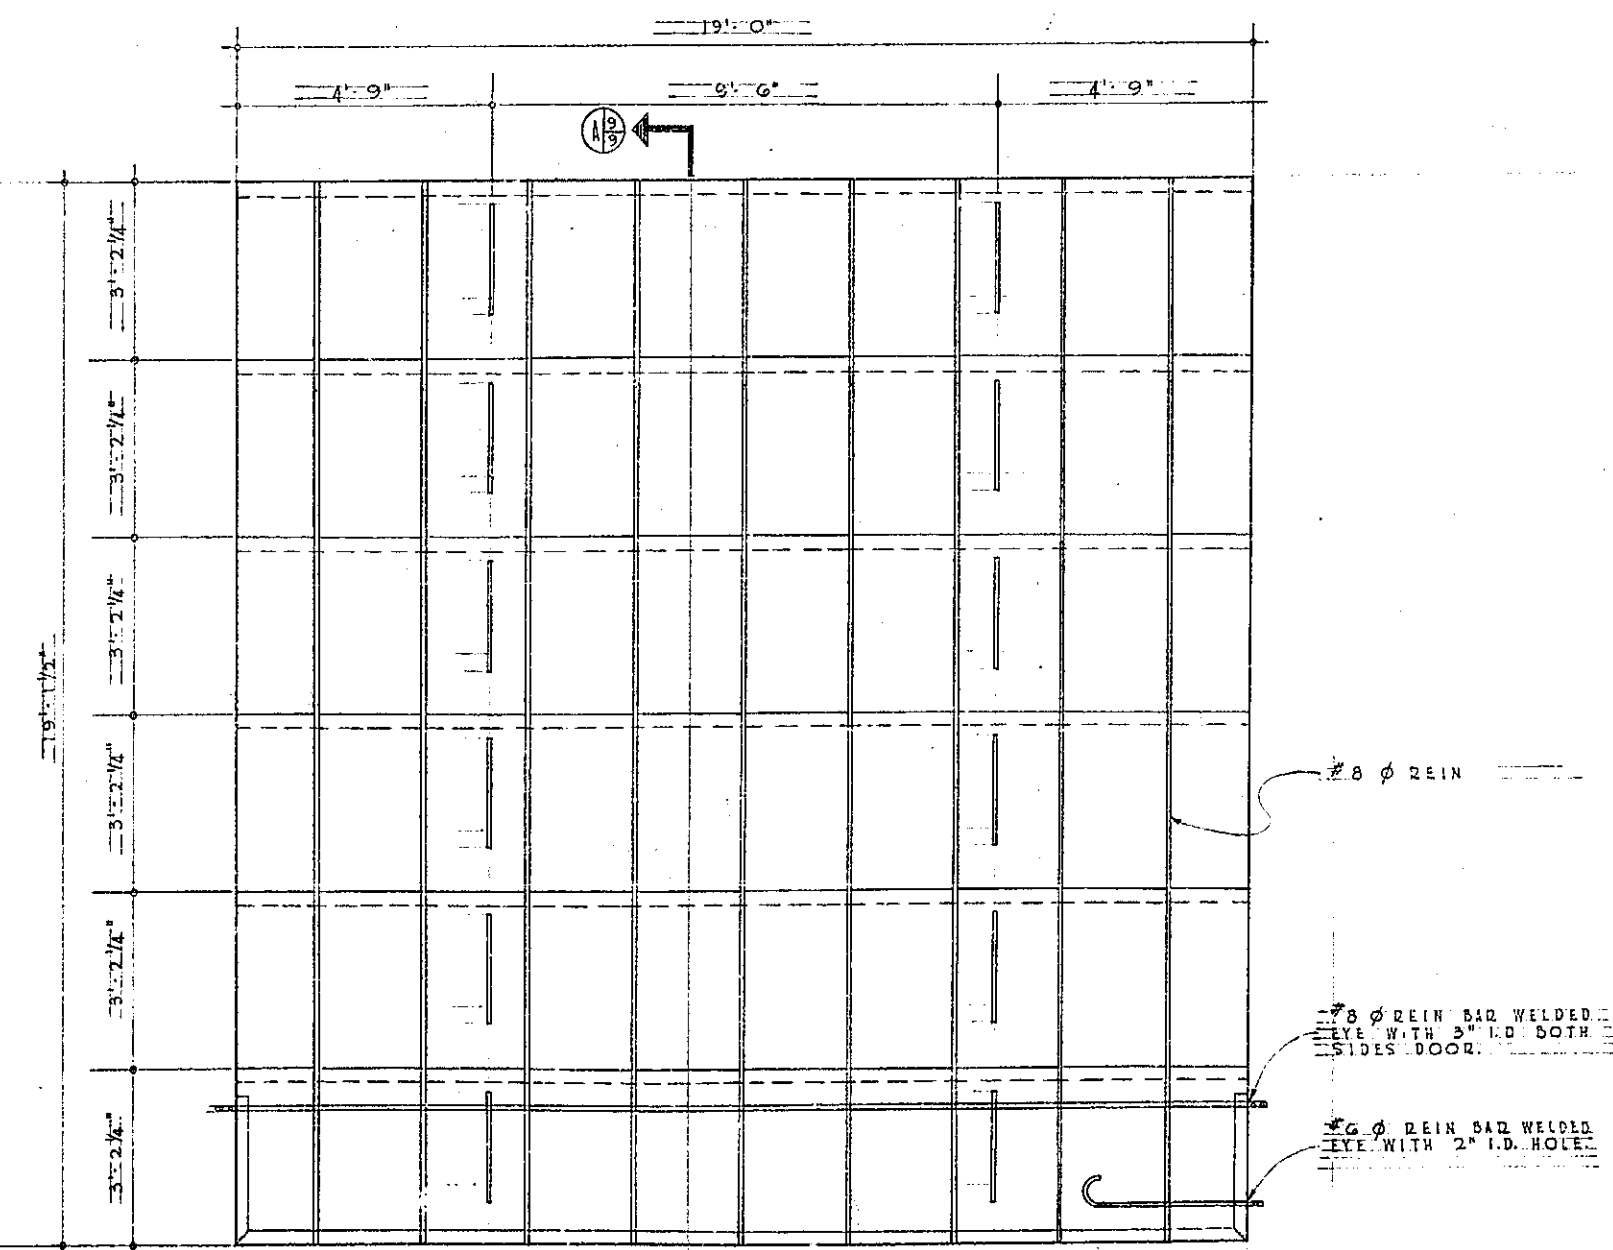

CONC. SLIDING DOOR
SCALE 1/2\"/>

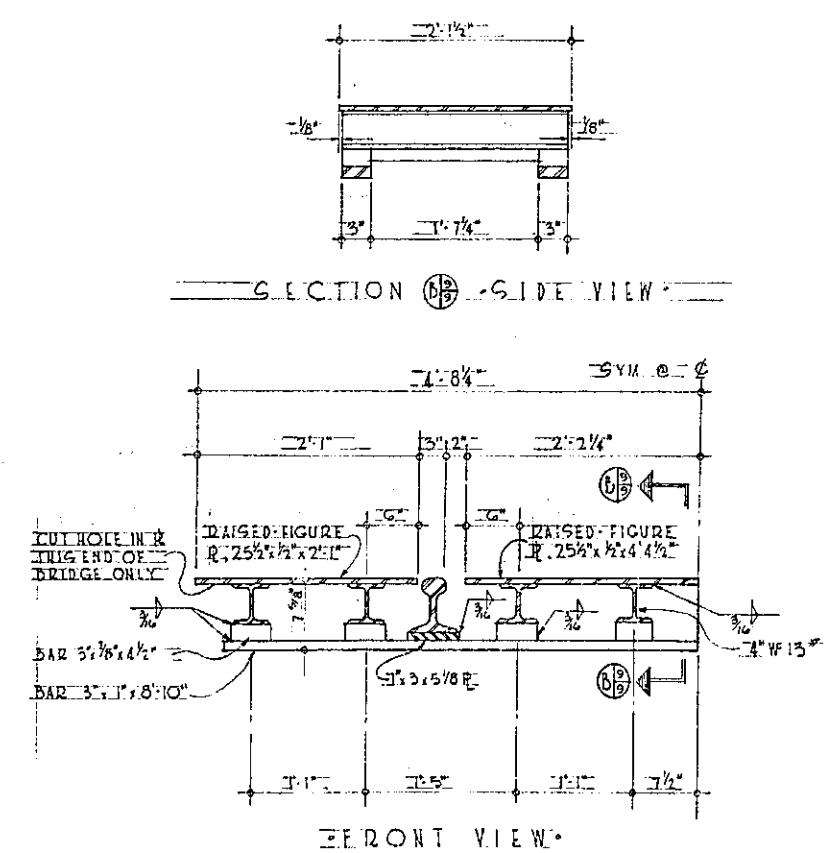


SECTION 68 - SIDE VIEW
SCALE 1/2\"/>

REVISION	DATE	DESCRIPTION	BY
DEPARTMENT OF THE AIR FORCE OGDEN AIR MATERIAL AREA OFFICE OF INSTALLATIONS OGDEN, UTAH			
HILL AIR FORCE BASE			
DESIGNED BY: G. JONES DRAWN BY: [Signature] CHECKED BY: [Signature] APPROVED BY: [Signature]			
PROJECT NO. HILL-29-8			
DRAWING NUMBER: 58-3866			
SHEET 1 OF 11 SCALE: 1/2\"/>			

49-91

2113-58-A

250

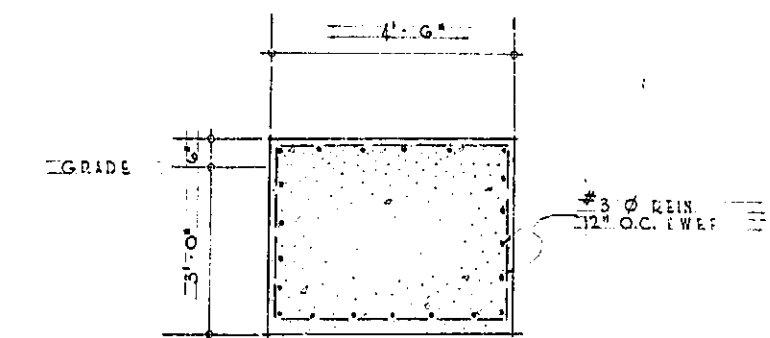

Architectural drawing of a door and window assembly. The drawing includes dimensions for the door and window opening, and annotations for the assembly details.

Dimensions:

- Top door opening: 6'-0" (center), 1'-0" (left), 1'-0" (right), 6'-0" (total)
- Window opening: 6'-0" (center), 1'-0" (left), 1'-0" (right), 6'-0" (total)
- Door height: 7'-0" (center), 1'-0" (left), 1'-0" (right), 7'-0" (total)
- Window height: 7'-0" (center), 1'-0" (left), 1'-0" (right), 7'-0" (total)

Annotations:

- WELD W/STAY: 2011S
- FRAME & GUSSETS TO
- IRON.
- DOOR
- 1" @ 12" SW
- 1" IN. FLOOR
- 1" @ 12" ANCHOR BOLTS
- 1" IN. C. NORMAL 1 EA
- AROUND STAY-ROLLED FRAME
- 1" @ 12
- 1" @ 12 EW
- 1" @ 12


12'-0" LF WITH
 3/4" x 1/2" REBAR
 LONG 12' O.C.
 12'-0"
 12'-0"
 2'-0" x 2'-0"
 3/4" x 1/2" REIN. CONT.
 3/4" x 1/2" REIN. 3' SWP
 BOTTOM & SIDES

[illegible]

DOOR ROLLED DETAIL
SCALE 1/2" = 1'-0"



REVISION	DATE	DESCRIPTION	BY
		DEPARTMENT OF THE AIR FORCE ODDEN AIR MATERIAL AREA OFFICE OF INSTALLATIONS	
HILL AIR FORCE BASE		ODDEN, UTAH	
DESIGNED BY <u>C. G. LONIS</u>		MODIFICATION OF BUILDING N° 2113 FOR X-RAY FACILITIES CONC. DOOR & TRACK DETAILS	
DRAWN BY <u>J. C. SHIELDS</u>			
TRACED BY <u>J. B. 1958</u>			
CHECKED BY	DATE		
APPROVED BY	DATE		
SUBMITTED <u>S. J. Jones</u>		APPROVED <u>J. B. 1958</u>	APPROVED <u>J. B. 1958</u>
APPROVED <u>J. B. 1958</u>	DATE <u>12/10/58</u>	PROJECT NO.	<u>HIL 29-8</u>
APPROVED <u>J. B. 1958</u>	DATE <u>12/10/58</u>	DRAWING NUMBER 58-386C	
APPROVED <u>J. B. 1958</u>	DATE <u>12/10/58</u>	SHEET <u>1</u> OF <u>11</u> SCALE <u>N.T.D.</u>	

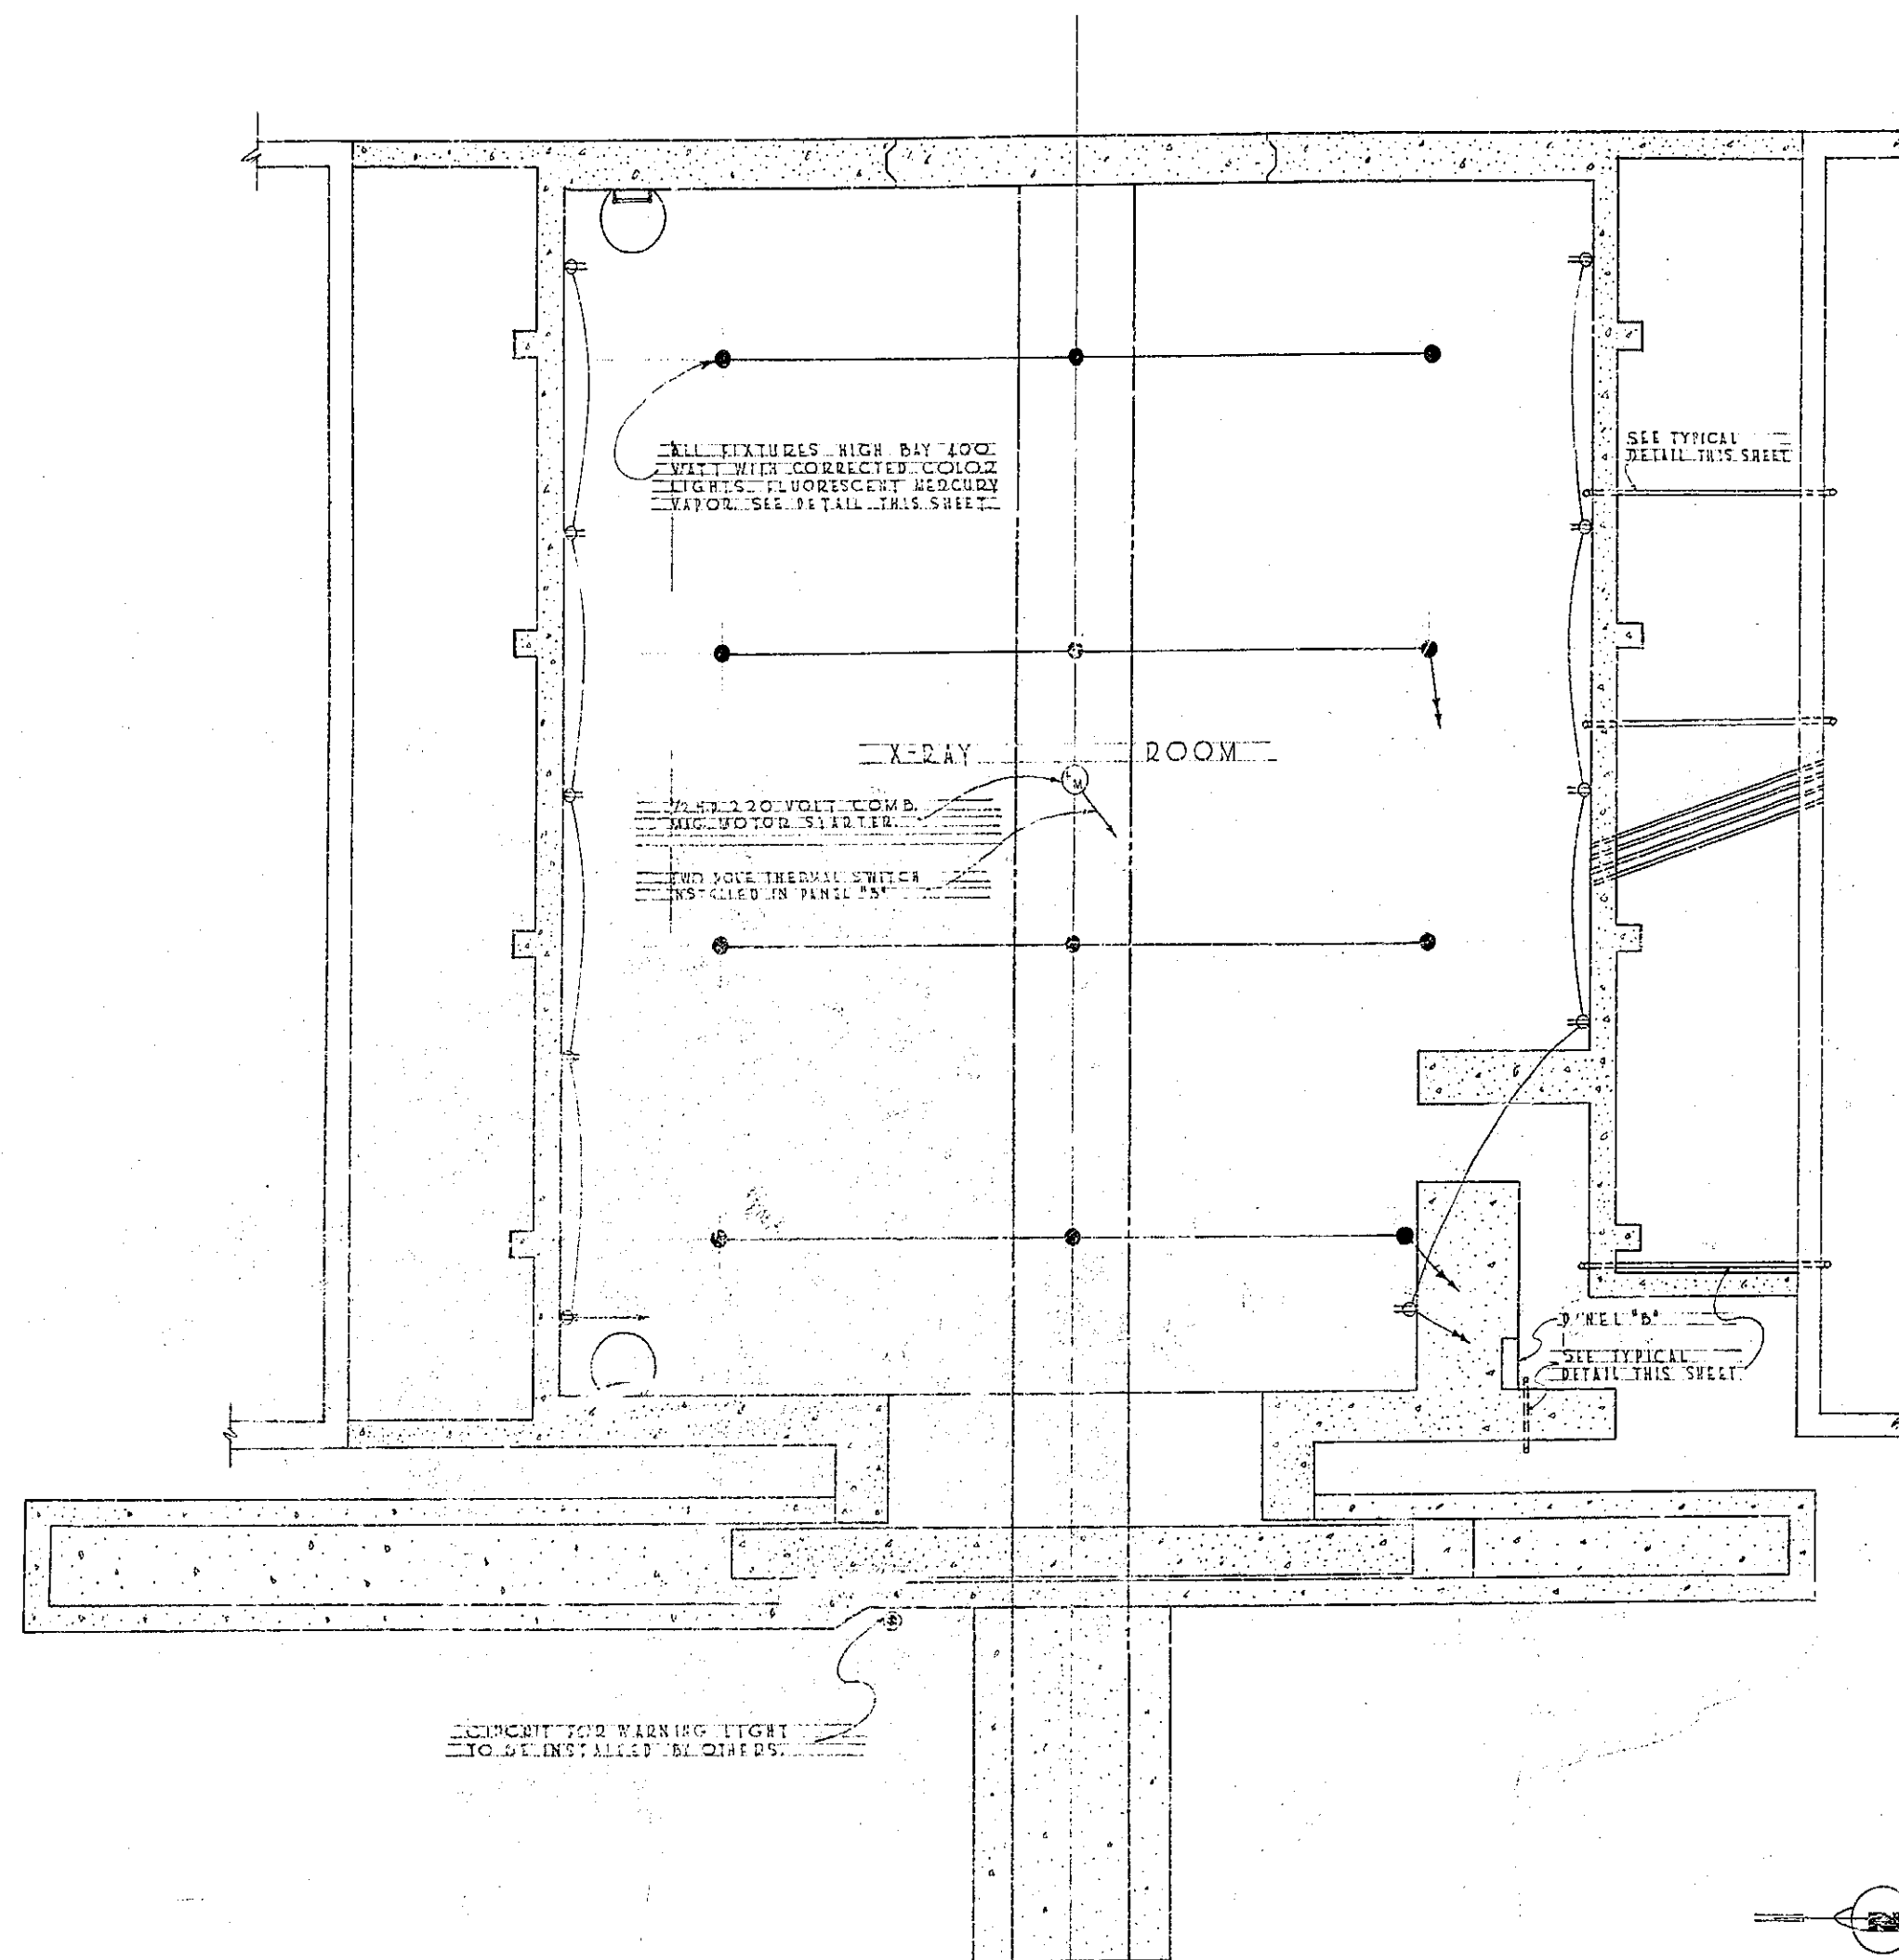


COMPART FOR WARNING LIGHT
TO BE INSTALLED BY OTHERS.

FLOOR PLAN
SCALE: 1/4" = 1'-0"

NOTES



1. DOOR SWITCH SHALL BE CLOSED ONLY WHEN DOOR IS IN THE CLOSED POSITION.
2. DUPLEX RECEPTACLES IN X-RAY ROOM SHALL BE MOUNTED 12" ABOVE FLOOR.
3. CONDUIT FITTINGS SHALL NOT BE RECESSED IN 2" OR 12" WALLS NOR SHALL CONDUIT PASS THRU THESE WALLS UNLESS BELOW THE FLOOR LINE 18".
4. ALL WIRE TO BE STD. STRANDED COPPER.

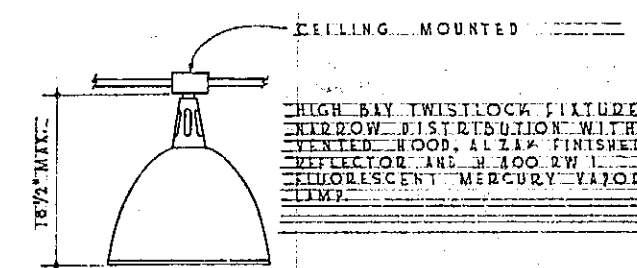

DETAIL HIGH BAY FIXTURE
SCALE

- CONDUIT EXPOSED
- CONDUIT CONCEALED IN CEILING OR WALL
- CONDUIT CONCEALED IN FLOOR
- FIXTURE #28 915 200 WATT LAMP RED GLOBE AND GUARD (WARNING LIGHT)
- UNIVERSAL #5262 DUPLEX RECEPTACLE 2 POLE GROUNDING
- TRACTIONAL W.P. H.D. FAN MOTOR AND SOLENOID OPER. VALVE
- FLUORESCENT MERCURY VAPOR (SEE DETAIL THIS SHEET)

IP-6 PANEL (B) G.E. CAT. 102 W.P. NLAB21616.

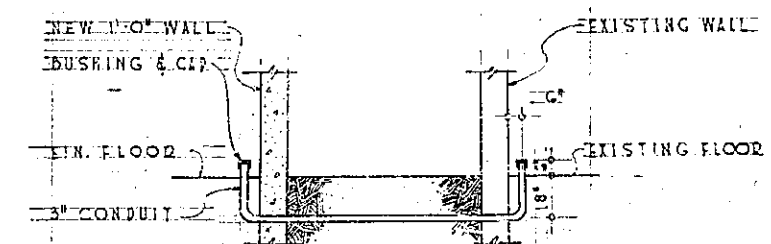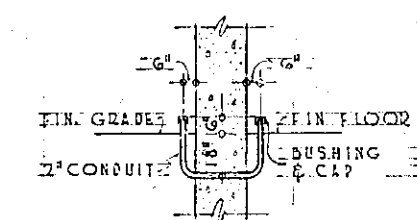


TYPICAL ELECTRICAL SERVICE
ENTRANCE DETAIL
SCALE: 1/4" = 1'-0"

REVISION	DATE	DESCRIPTION	BY
DEPARTMENT OF THE AIR FORCE OGDEN AIR MATERIAL AREA OFFICE OF INSTALLATIONS OGDEN, UTAH			
DESIGNED BY: J. K. KENNEDY DRAWN BY: J. G. SHILLERS TRACED BY: J. G. SHILLERS CHECKED BY: J. G. SHILLERS		MODIFICATION OF BUILDING N°2113 FOR X-RAY FACILITIES ELECTRICAL	
APPROVED BY: J. K. KENNEDY DATE: 18 FEB 58		APPROVED BY: J. G. SHILLERS DATE: 18 FEB 58	
APPROVED BY: J. K. KENNEDY DATE: 18 FEB 58		APPROVED BY: J. G. SHILLERS DATE: 18 FEB 58	
PROJECT NO. HIL-29-8		DRAWING NUMBER 58-3866	
SHEET 11 OF 11 SCALE NOTED		49-92	

MODIFICATION OF BUILDING N° 2113 FOR X-RAY FACILITIES

HILL AIR FORCE BASE - OGDEN, UTAH

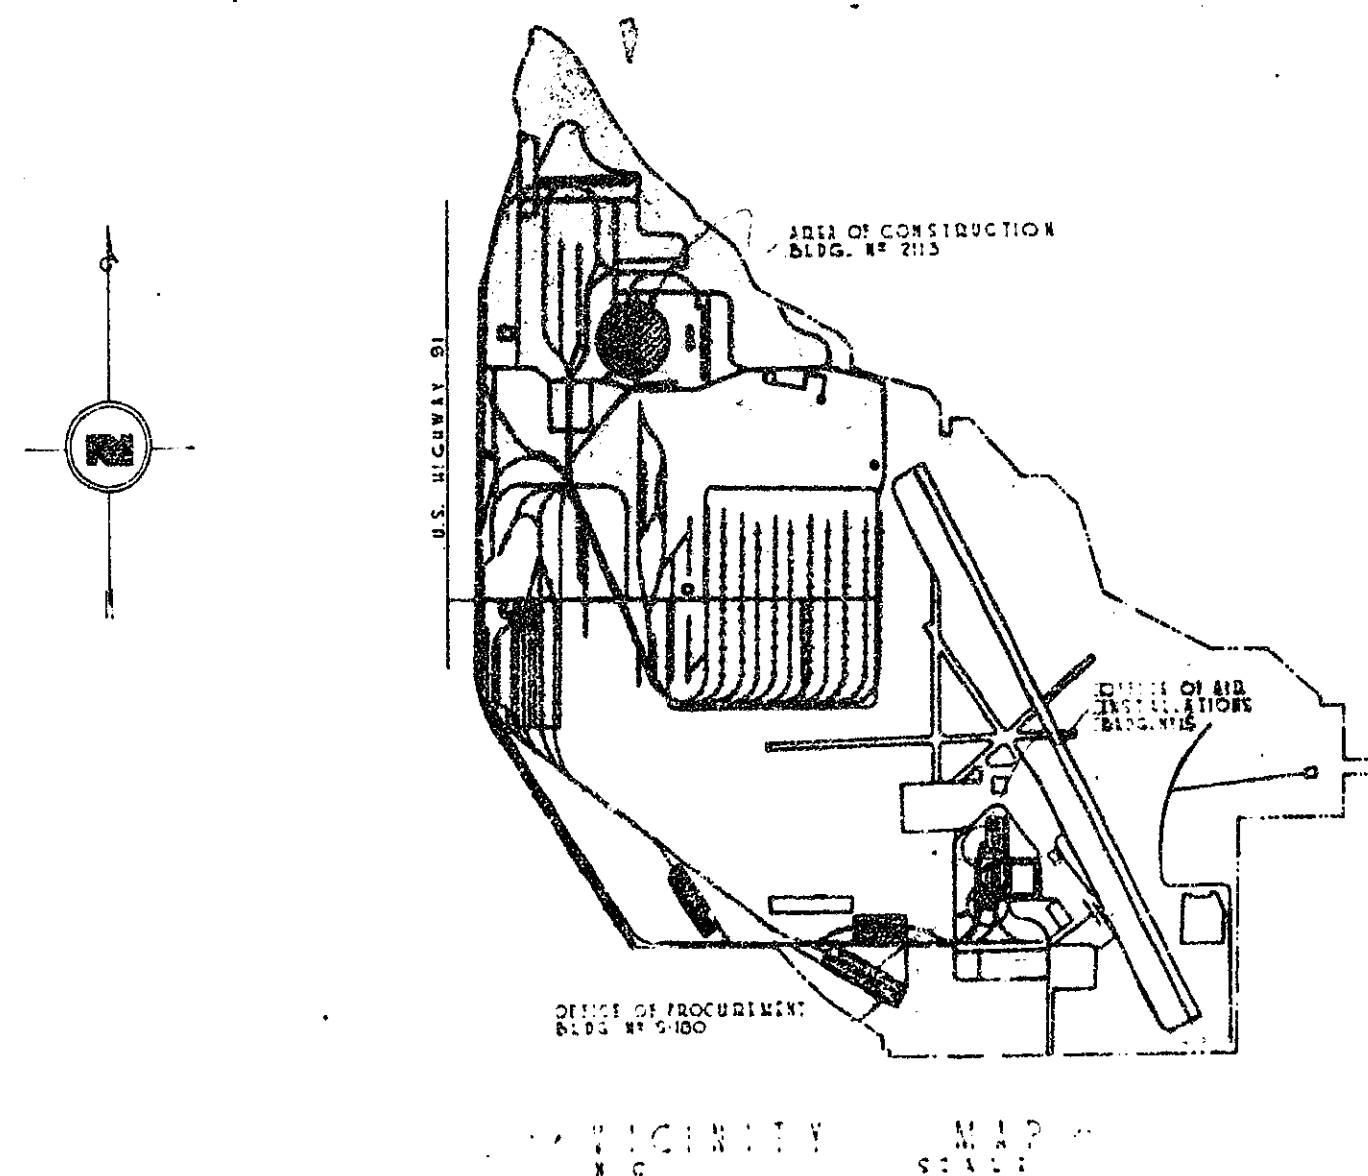


INDEX OF SHEETS



1. COVER SHEET & VICINITY MAP
2. PLOT PLAN & UNIT LAYOUT
3. FLOOR PLAN
4. EAST ELEVATION
5. WEST & SOUTH ELEVATIONS
6. TYPICAL SECTIONS THRU BUILDING
7. FOOTING FOUNDATION PLAN & DETAILS
8. WALL REINFORCING & CEILING FRAMING PLAN
9. MISCELLANEOUS STRUCTURAL DETAILS
10. MISCELLANEOUS & FENCE DETAILS
11. CONCRETE DOOR & TRACK DETAILS
12. MECHANICAL DETAILS OF SLIDING DOORS
13. PLUMBING & ROOF DETAILS
14. ELECTRICAL LIGHTING
15. ELECTRICAL POWER
16. ELECTRICAL DETAILS
17. ELECTRICAL DETAILS, GATE SWITCHES & MISCELLANEOUS
18. HEATING & VENTILATING

PREPARED BY INSTALLATIONS DIVISION
HILL AIR FORCE BASE - OGDEN, UTAH

PROJECT N° HIL-39-8
DRAWING N° 58-3724
SHEET ① OF 18

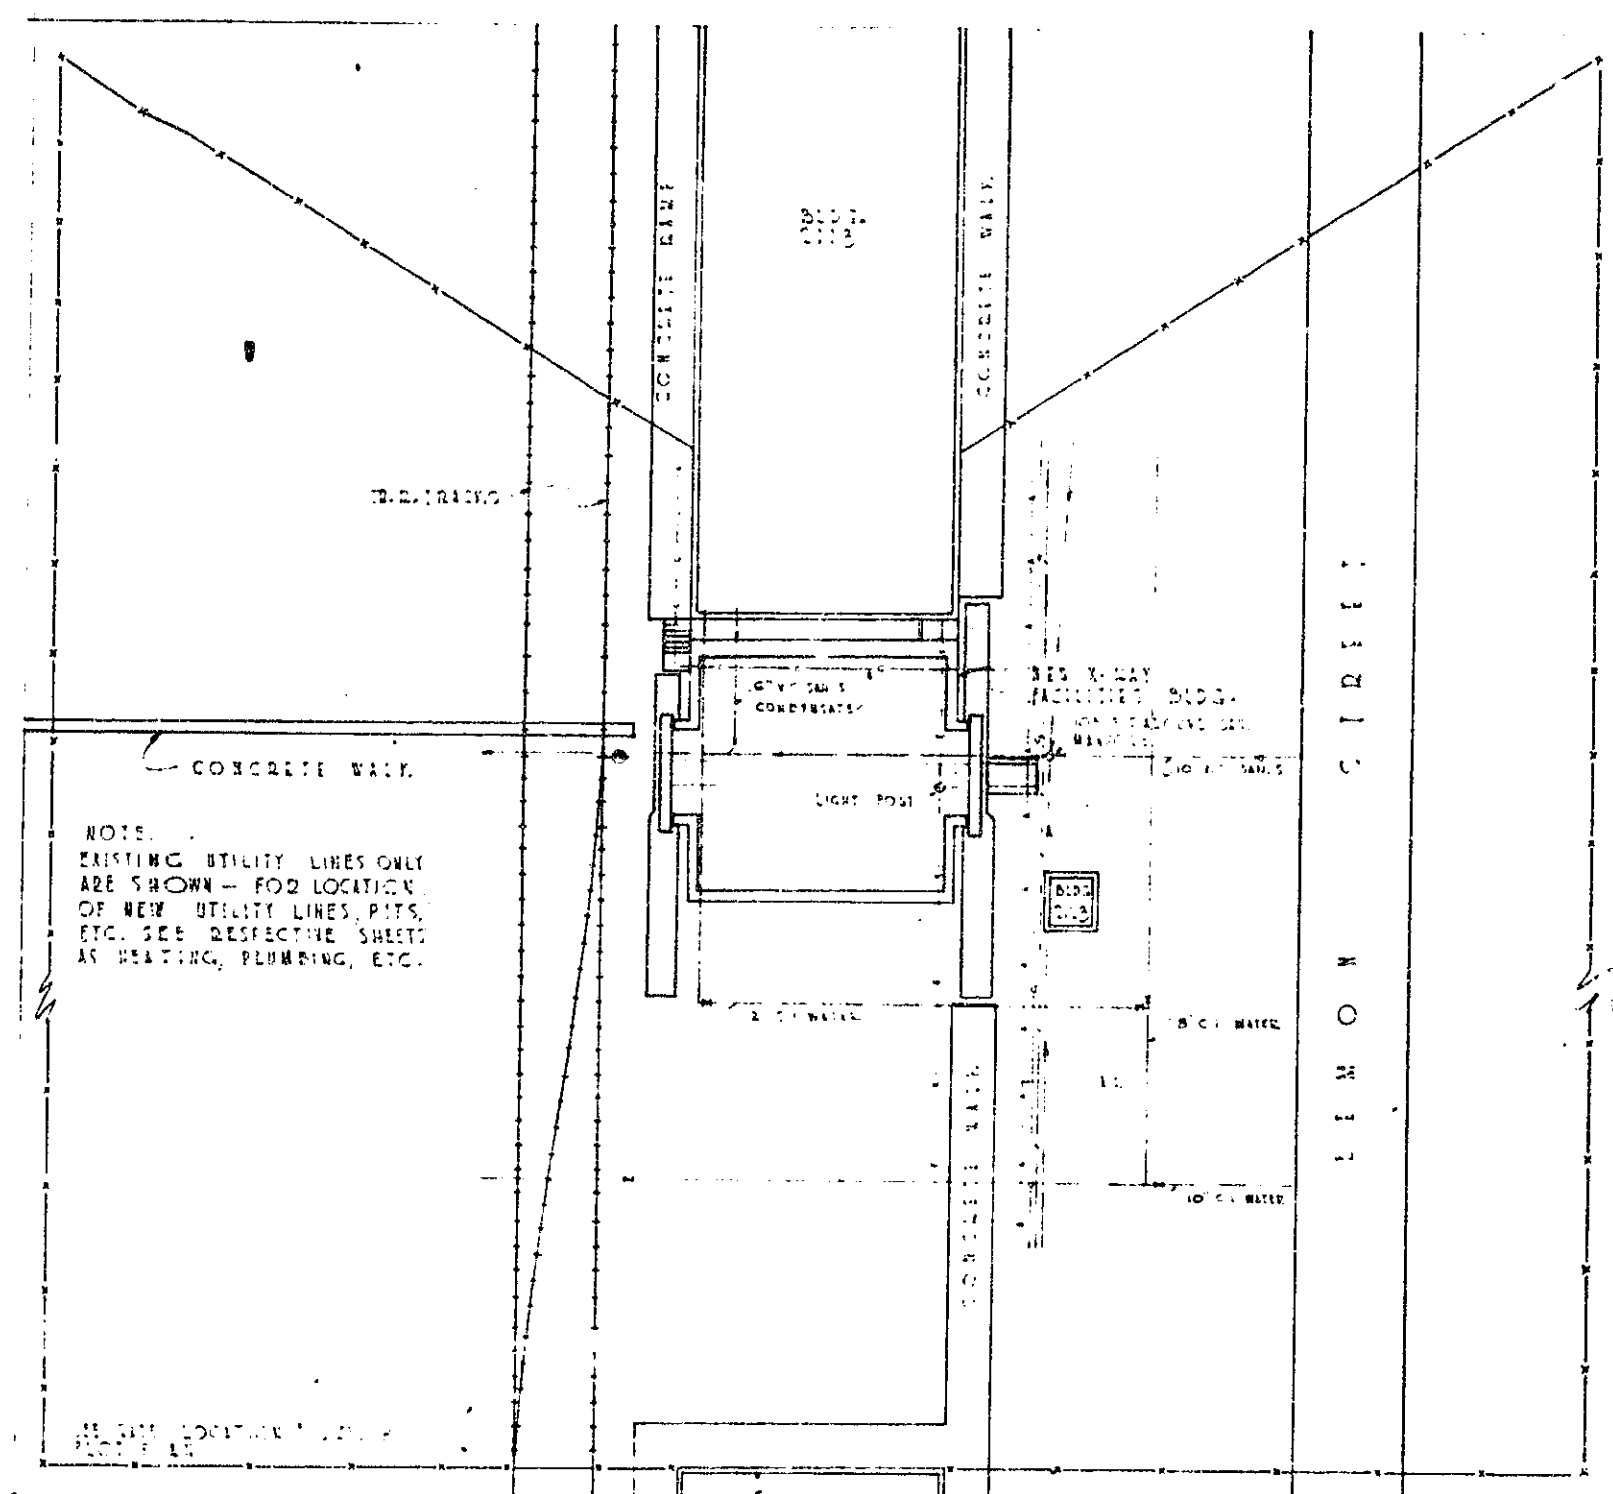

UTILITY LINES
 LEGEND:
 --- EXISTING UTILITY LINES
 --- NEW UTILITY LINES
 --- EXISTING CONTOUR
 --- NEW CONTOUR

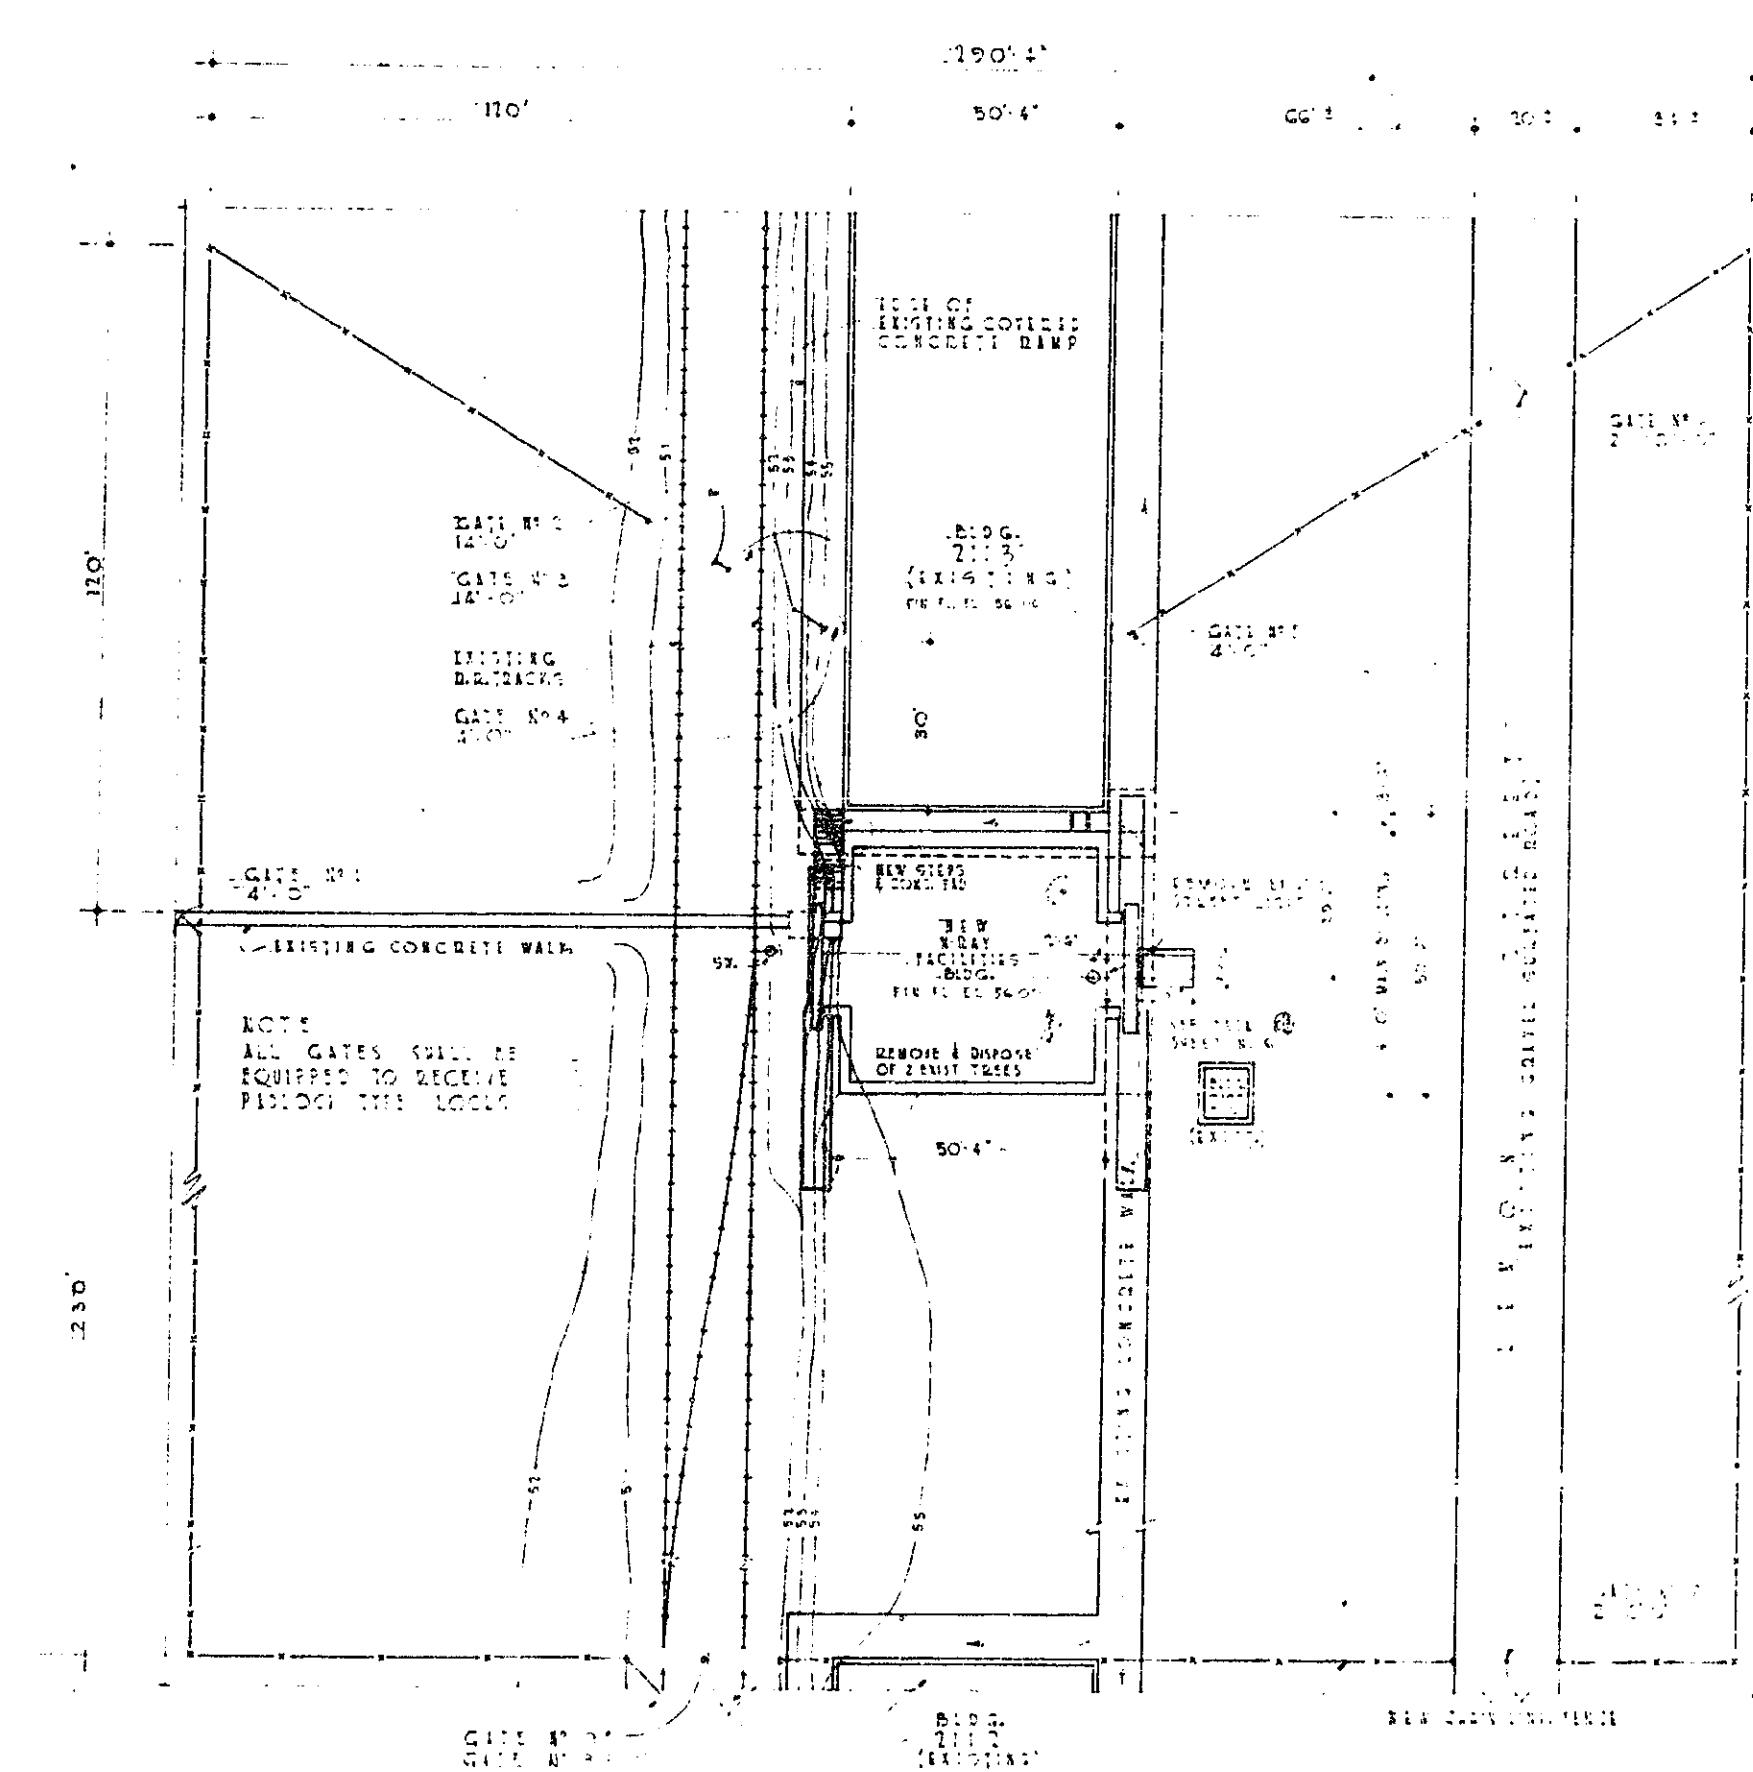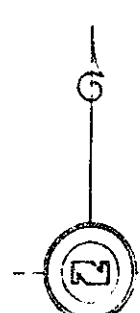


LEGEND:
 --- EXISTING (UNLESS NOTED)
 --- EXISTING TO BE REMOVED
 --- NEW CONSTRUCTION
 --- EXISTING CONTOUR
 --- NEW CONTOUR

DESIGN CHECK

CIVIL	DATE
MECHANICAL	DATE
STRUCTURAL	DATE
ELECTRICAL	DATE
ARCHITECTURAL	DATE
DESIGN CHECK	DATE

REVISION		DATE	DESCRIPTION	BY
DEPARTMENT OF THE AIR FORCE OGDEN AIR MATERIAL AREA OFFICE OF INSTALLATIONS OGDEN, UTAH				
DESIGNED BY: J. M. WALKER DRAWN BY: J. M. WALKER CHECKED BY: J. M. WALKER		PROJECT NO. 58-3724 DRAWING NUMBER 58-3724		
APPROVED BY: J. M. WALKER DATE: 10/24/54		APPROVAL RECOMMENDED: J. M. WALKER APPROVED: J. M. WALKER		

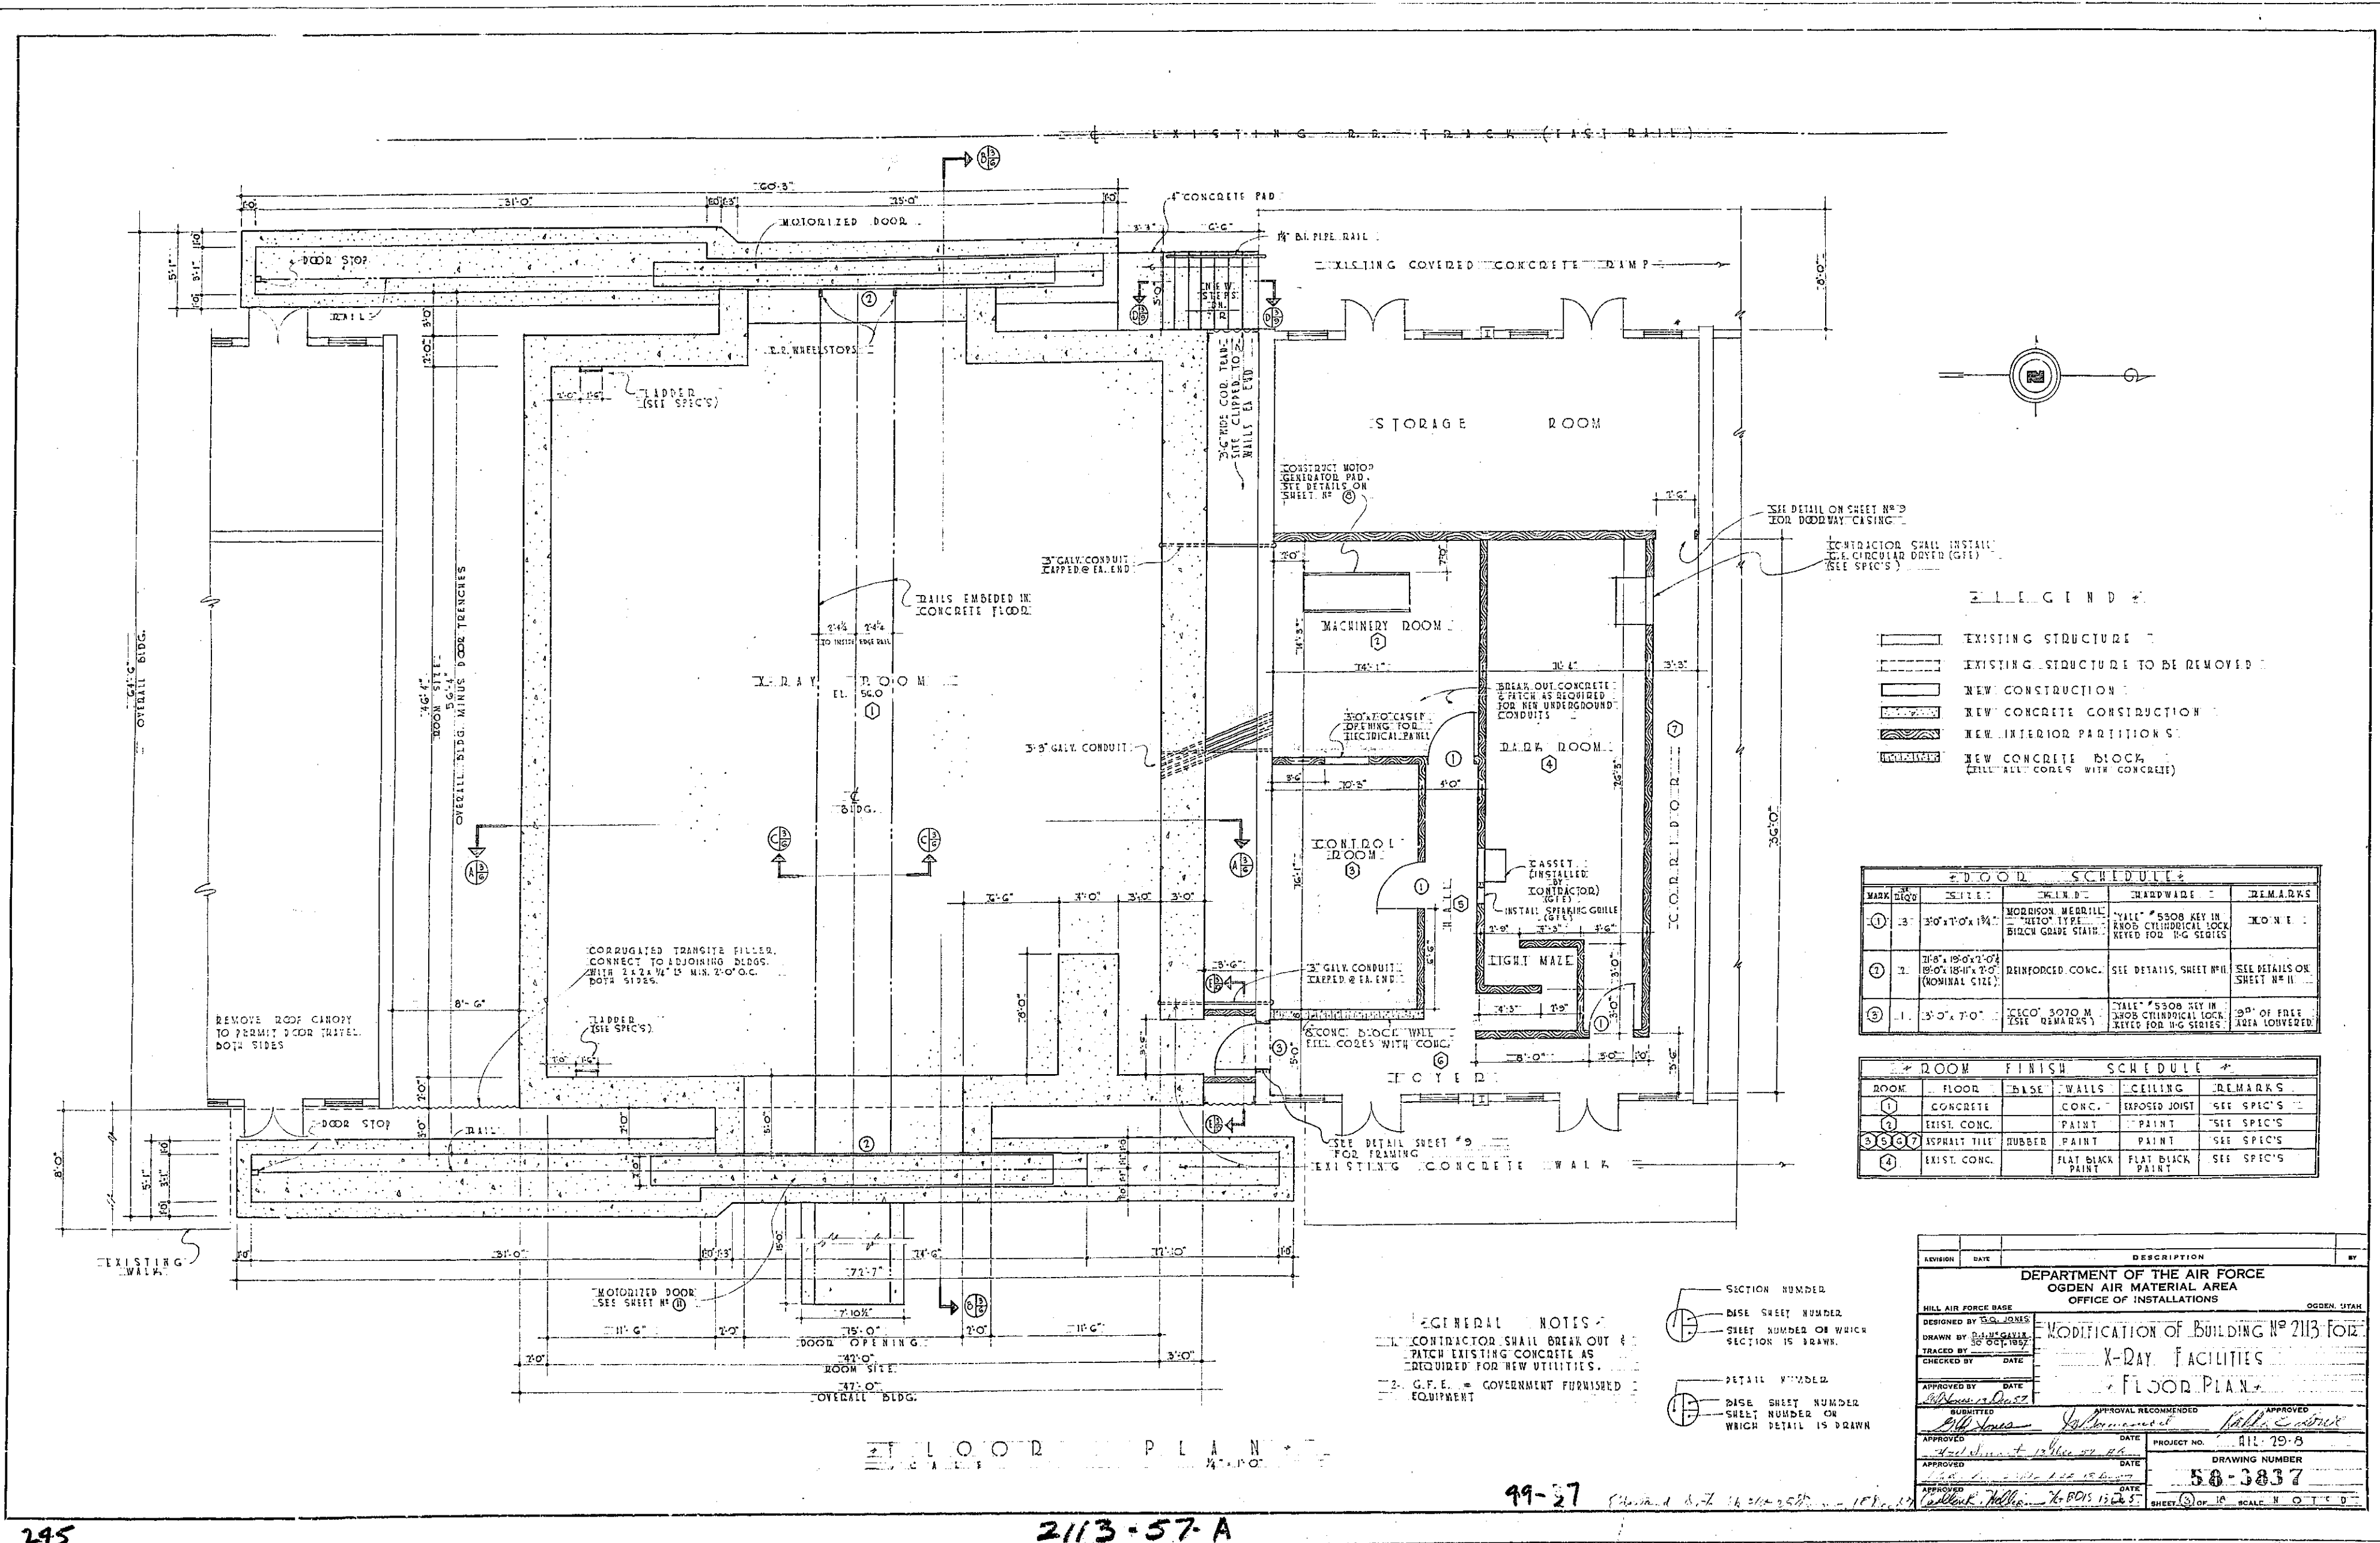

- LEGEND**
- EXISTING STRUCTURE
 - EXISTING STRUCTURE TO BE REMOVED
 - NEW CONSTRUCTION
 - NEW CONCRETE CONSTRUCTION
 - NEW INTERIOR PARTITIONS
 - NEW CONCRETE BLOCK (FILL ALL CORES WITH CONCRETE)

DOOR SCHEDULE				
MARK	NO.	SIZE	FINISH	REMARKS
1	1	3'-0" x 7'-0"	WOODWORK, MERRILL, BRUSH GRADE STAIN	CONCRETE
2	2	3'-0" x 7'-0"	REINFORCED CONC.	SEE DETAILS, SHEET #11
3	3	3'-0" x 7'-0"	REINFORCED CONC.	SEE DETAILS, SHEET #11

ROOM FINISH SCHEDULE				
ROOM	FLOOR	BASE	WALLS	CEILING
1	CONCRETE	CONC.	CONC.	EXPOSED JOIST
2	EXIST. CONC.	PAINT	PAINT	PAINT
3	ASPHALT TILE	RUBBER	PAINT	PAINT
4	EXIST. CONC.	FLAT BLACK PAINT	FLAT BLACK PAINT	FLAT BLACK PAINT


GENERAL NOTES

1. CONTRACTOR SHALL BREAK OUT & PATCH EXISTING CONCRETE AS REQUIRED FOR NEW UTILITIES.

2. G.F.E. = GOVERNMENT FURNISHED EQUIPMENT

- SECTION NUMBER
- BASE SHEET NUMBER
- SHEET NUMBER ON WHICH SECTION IS DRAWN
- DETAIL NUMBER
- BASE SHEET NUMBER
- SHEET NUMBER ON WHICH DETAIL IS DRAWN

DESIGNED BY	DATE	DESCRIPTION	BY
HILL AIR FORCE BASE			
DEPARTMENT OF THE AIR FORCE			
OGDEN AIR MATERIAL AREA			
OFFICE OF INSTALLATIONS			
OGDEN, UTAH			
MODIFICATION OF BUILDING NO. 2113 FOR X-RAY FACILITIES			
FLOOR PLAN			
APPROVED BY	DATE	APPROVAL RECOMMENDED	APPROVED
SUBMITTED			
APPROVED	DATE	PROJECT NO.	411-79-8
APPROVED	DATE	DRAWING NUMBER	58-3837
APPROVED	DATE	SHEET	1 OF 15

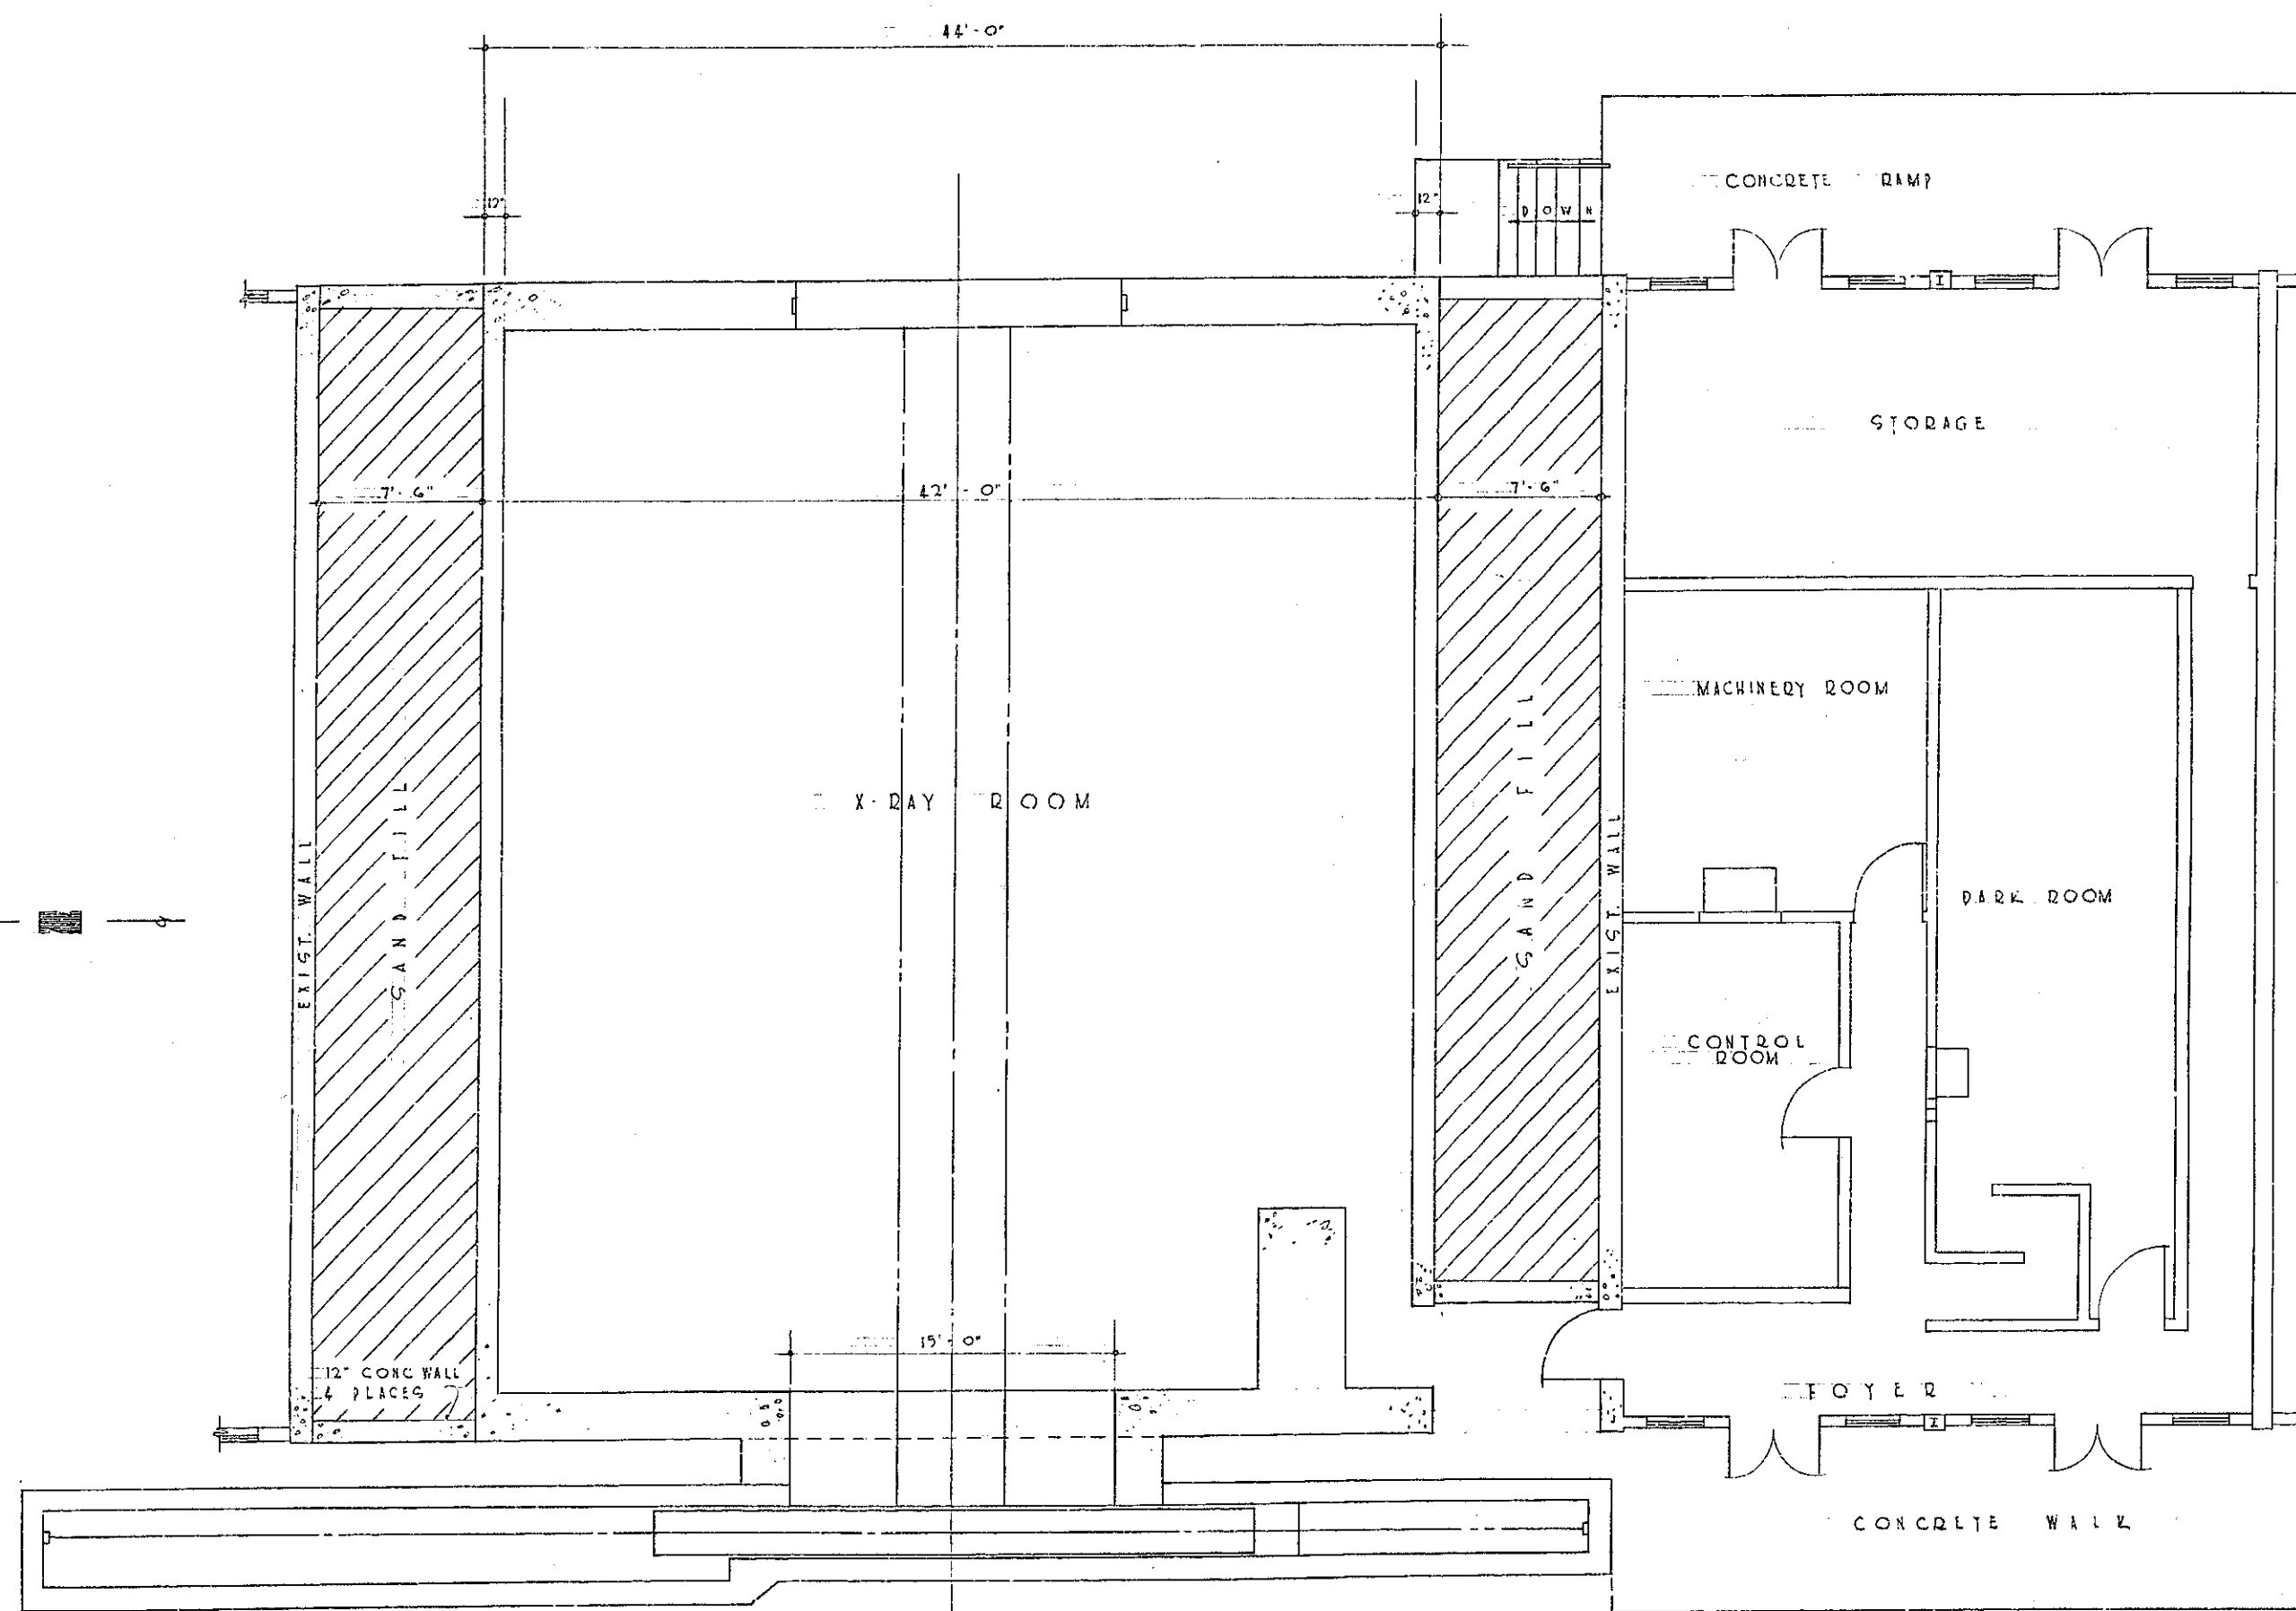

FLOOR
SCALE


PLAN
1/4" = 1'-0"

221

2113-58-A

49-38

DESIGNED BY	DATE	DESCRIPTION	BY
DEPARTMENT OF THE AIR FORCE OGDEN AIR MATERIAL AREA OFFICE OF INSTALLATIONS OGDEN, UTAH			
DESIGNED BY	DATE	MODIFICATION OF BUILDING #2113 FOR	
DRAWN BY	DATE	X-RAY FACILITIES	
CHECKED BY	DATE	FLOOR PLAN	
APPROVED BY	DATE		
SUBMITTED	DATE	APPROVAL RECOMMENDED	APPROVED
APPROVED	DATE	PROJECT NO.	WIL-29-8
APPROVED	DATE	DRAWING NUMBER	58-3837
APPROVED	DATE	SHEET	1 OF 12 SCALE 5/8" = 1'-0"

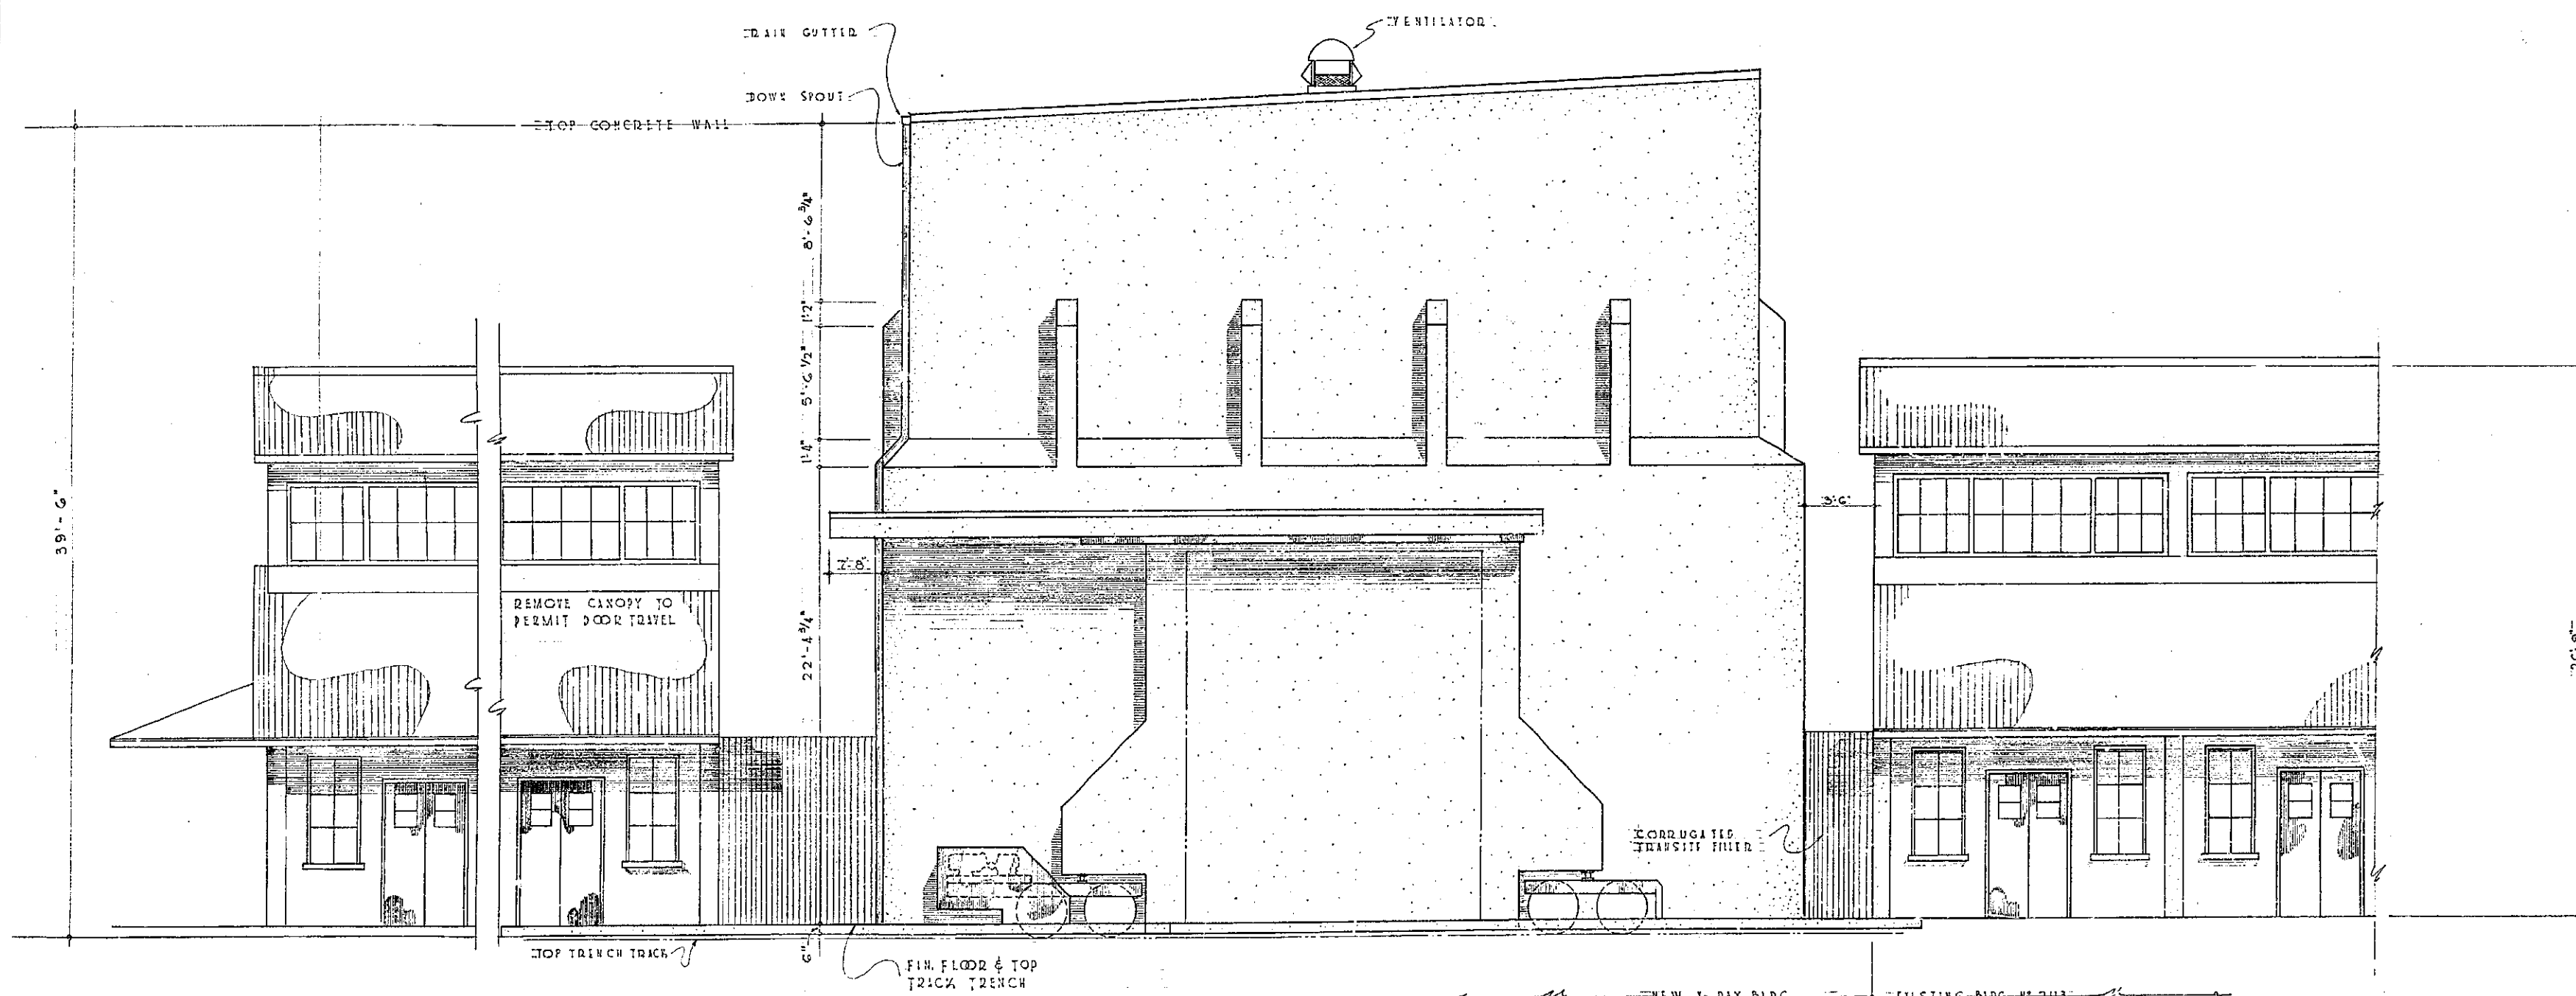






EAST ELEVATION
1/4" = 1'-0"

222

49-39

2113-57-A




REVISION	DATE	DESCRIPTION	BY
DEPARTMENT OF THE AIR FORCE OGDEN AIR MATERIAL AREA OFFICE OF INSTALLATIONS OGDEN, UTAH			
HILL AIR FORCE BASE		MODIFICATION OF BUILDING NO. 2113 FOR X-RAY FACILITY EAST ELEVATION	
DESIGNED BY	DATE	PROJECT NO. 49-39	
DRAWN BY	DATE	DRAWING NUMBER 58-3837	
TRACED BY	DATE	SHEET 1 OF 15 SCALE 1/4" = 1'-0"	
CHECKED BY	DATE		
APPROVED BY	DATE		
SUBMITTED	DATE		
APPROVED	DATE		
APPROVED	DATE		
APPROVED	DATE		

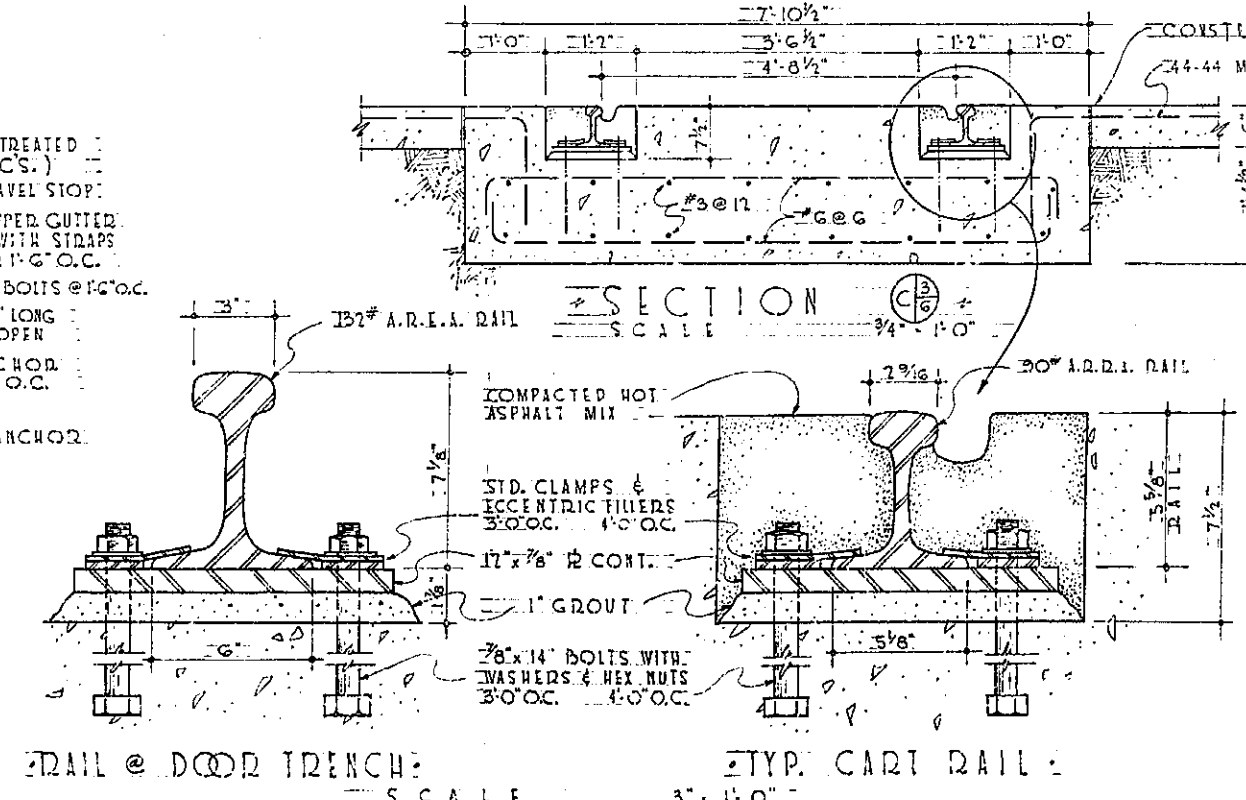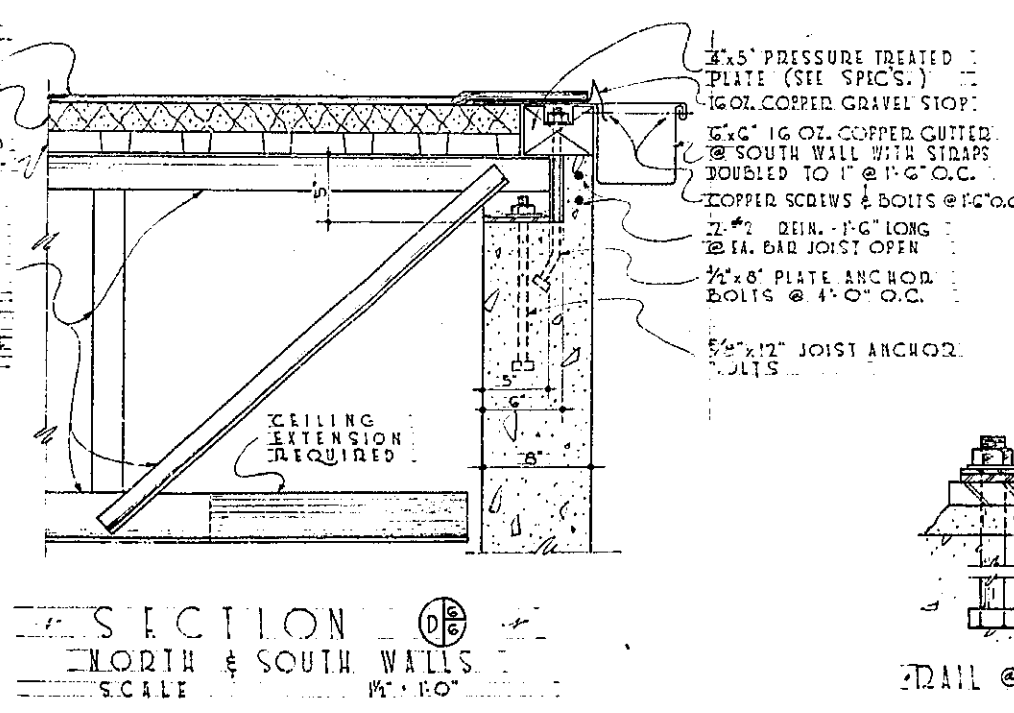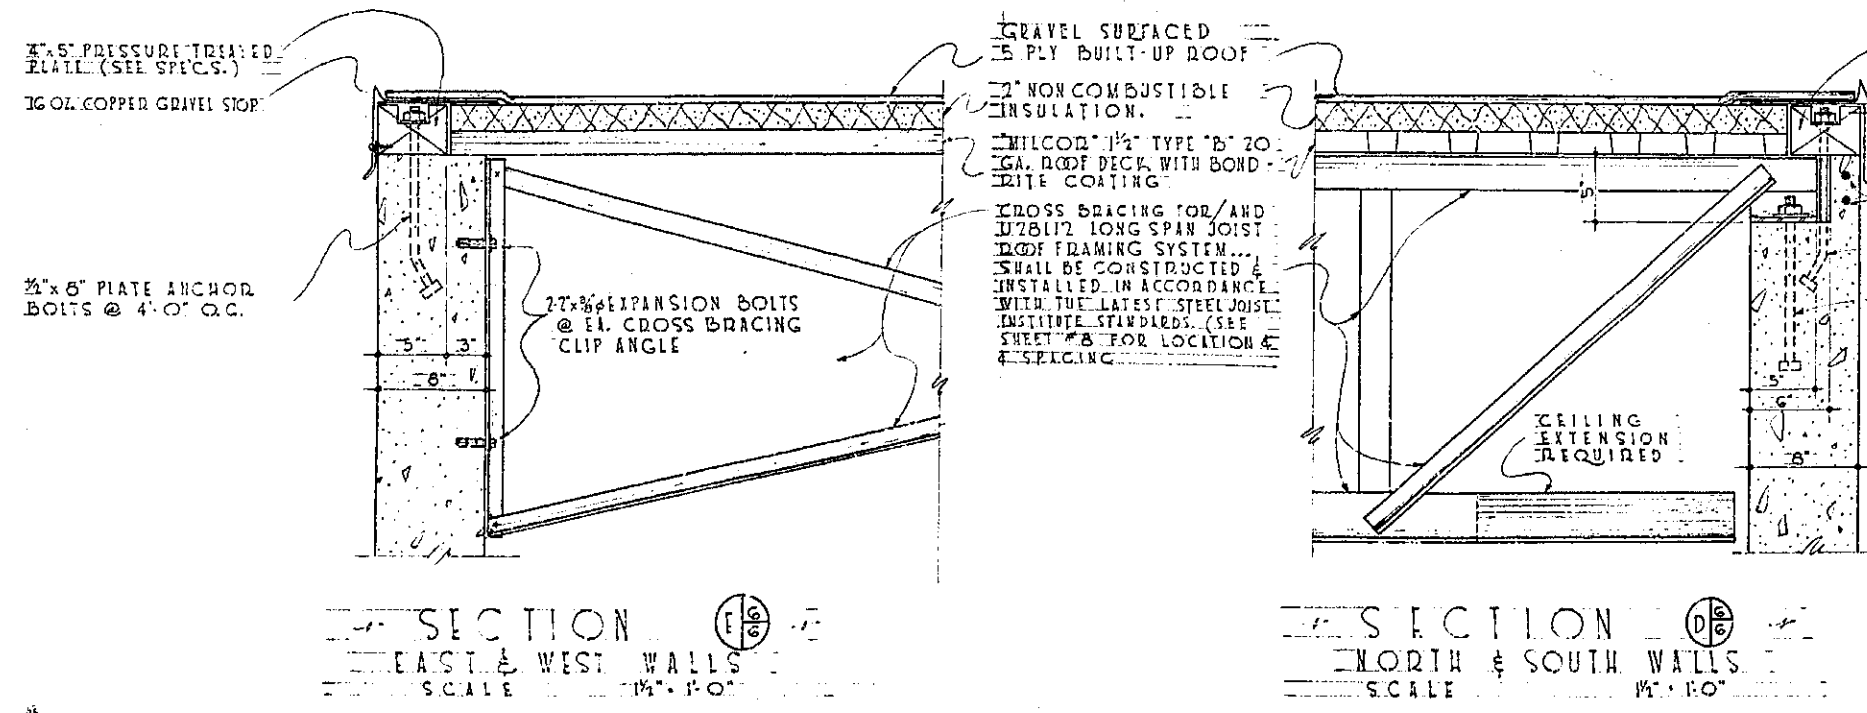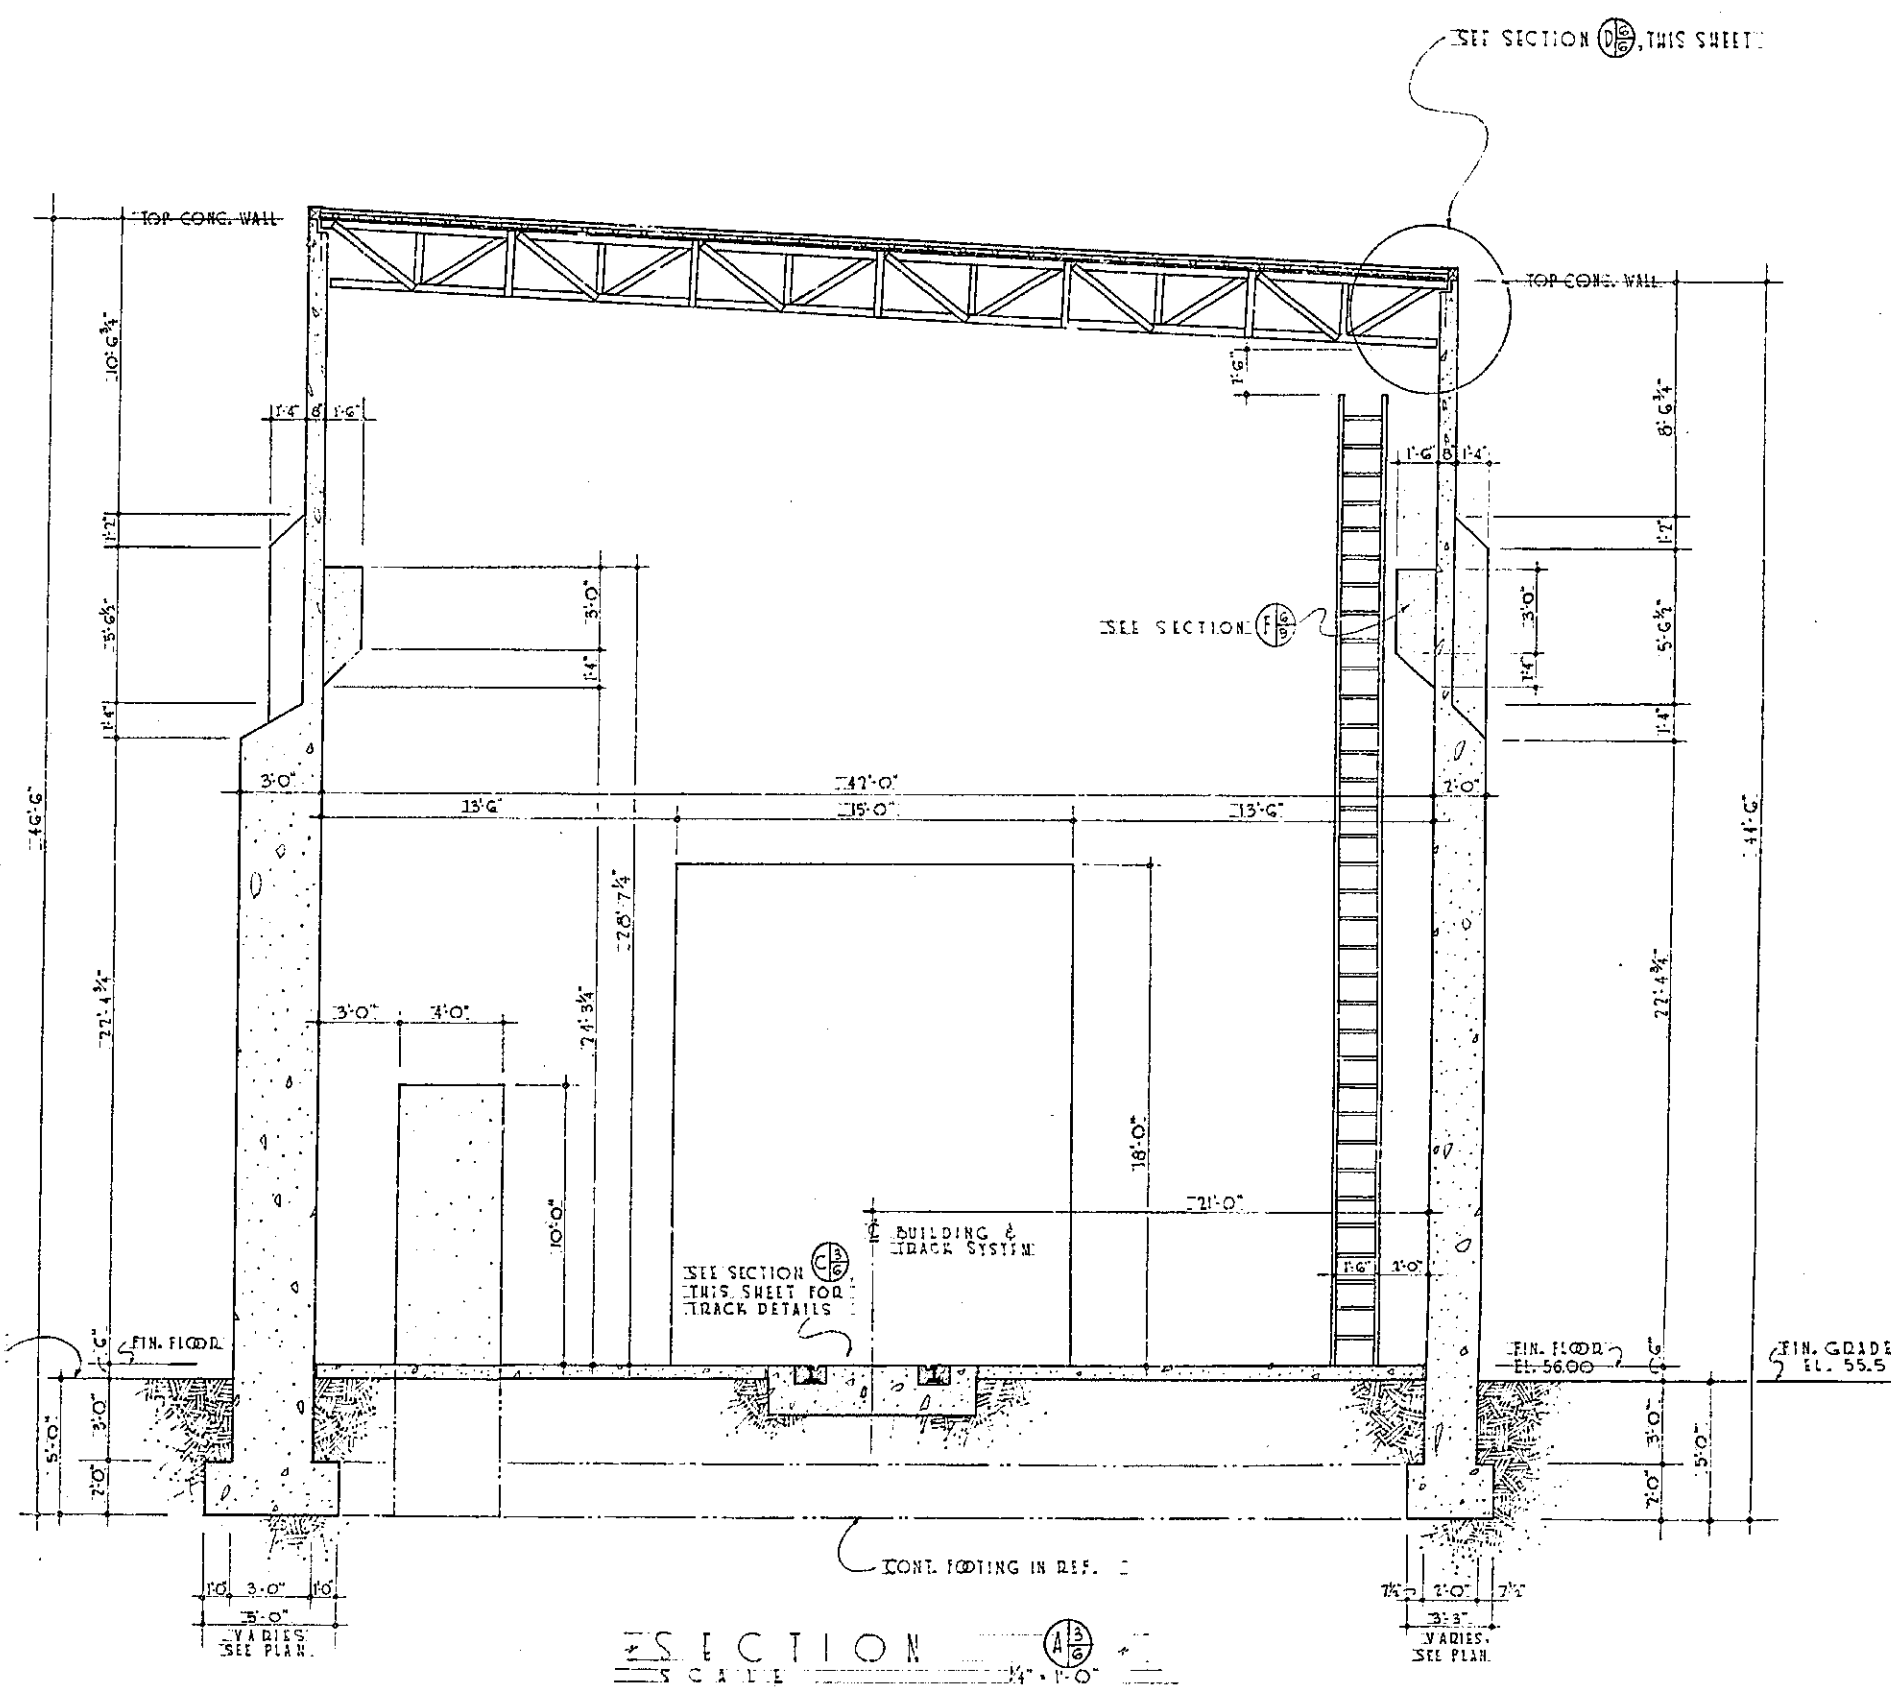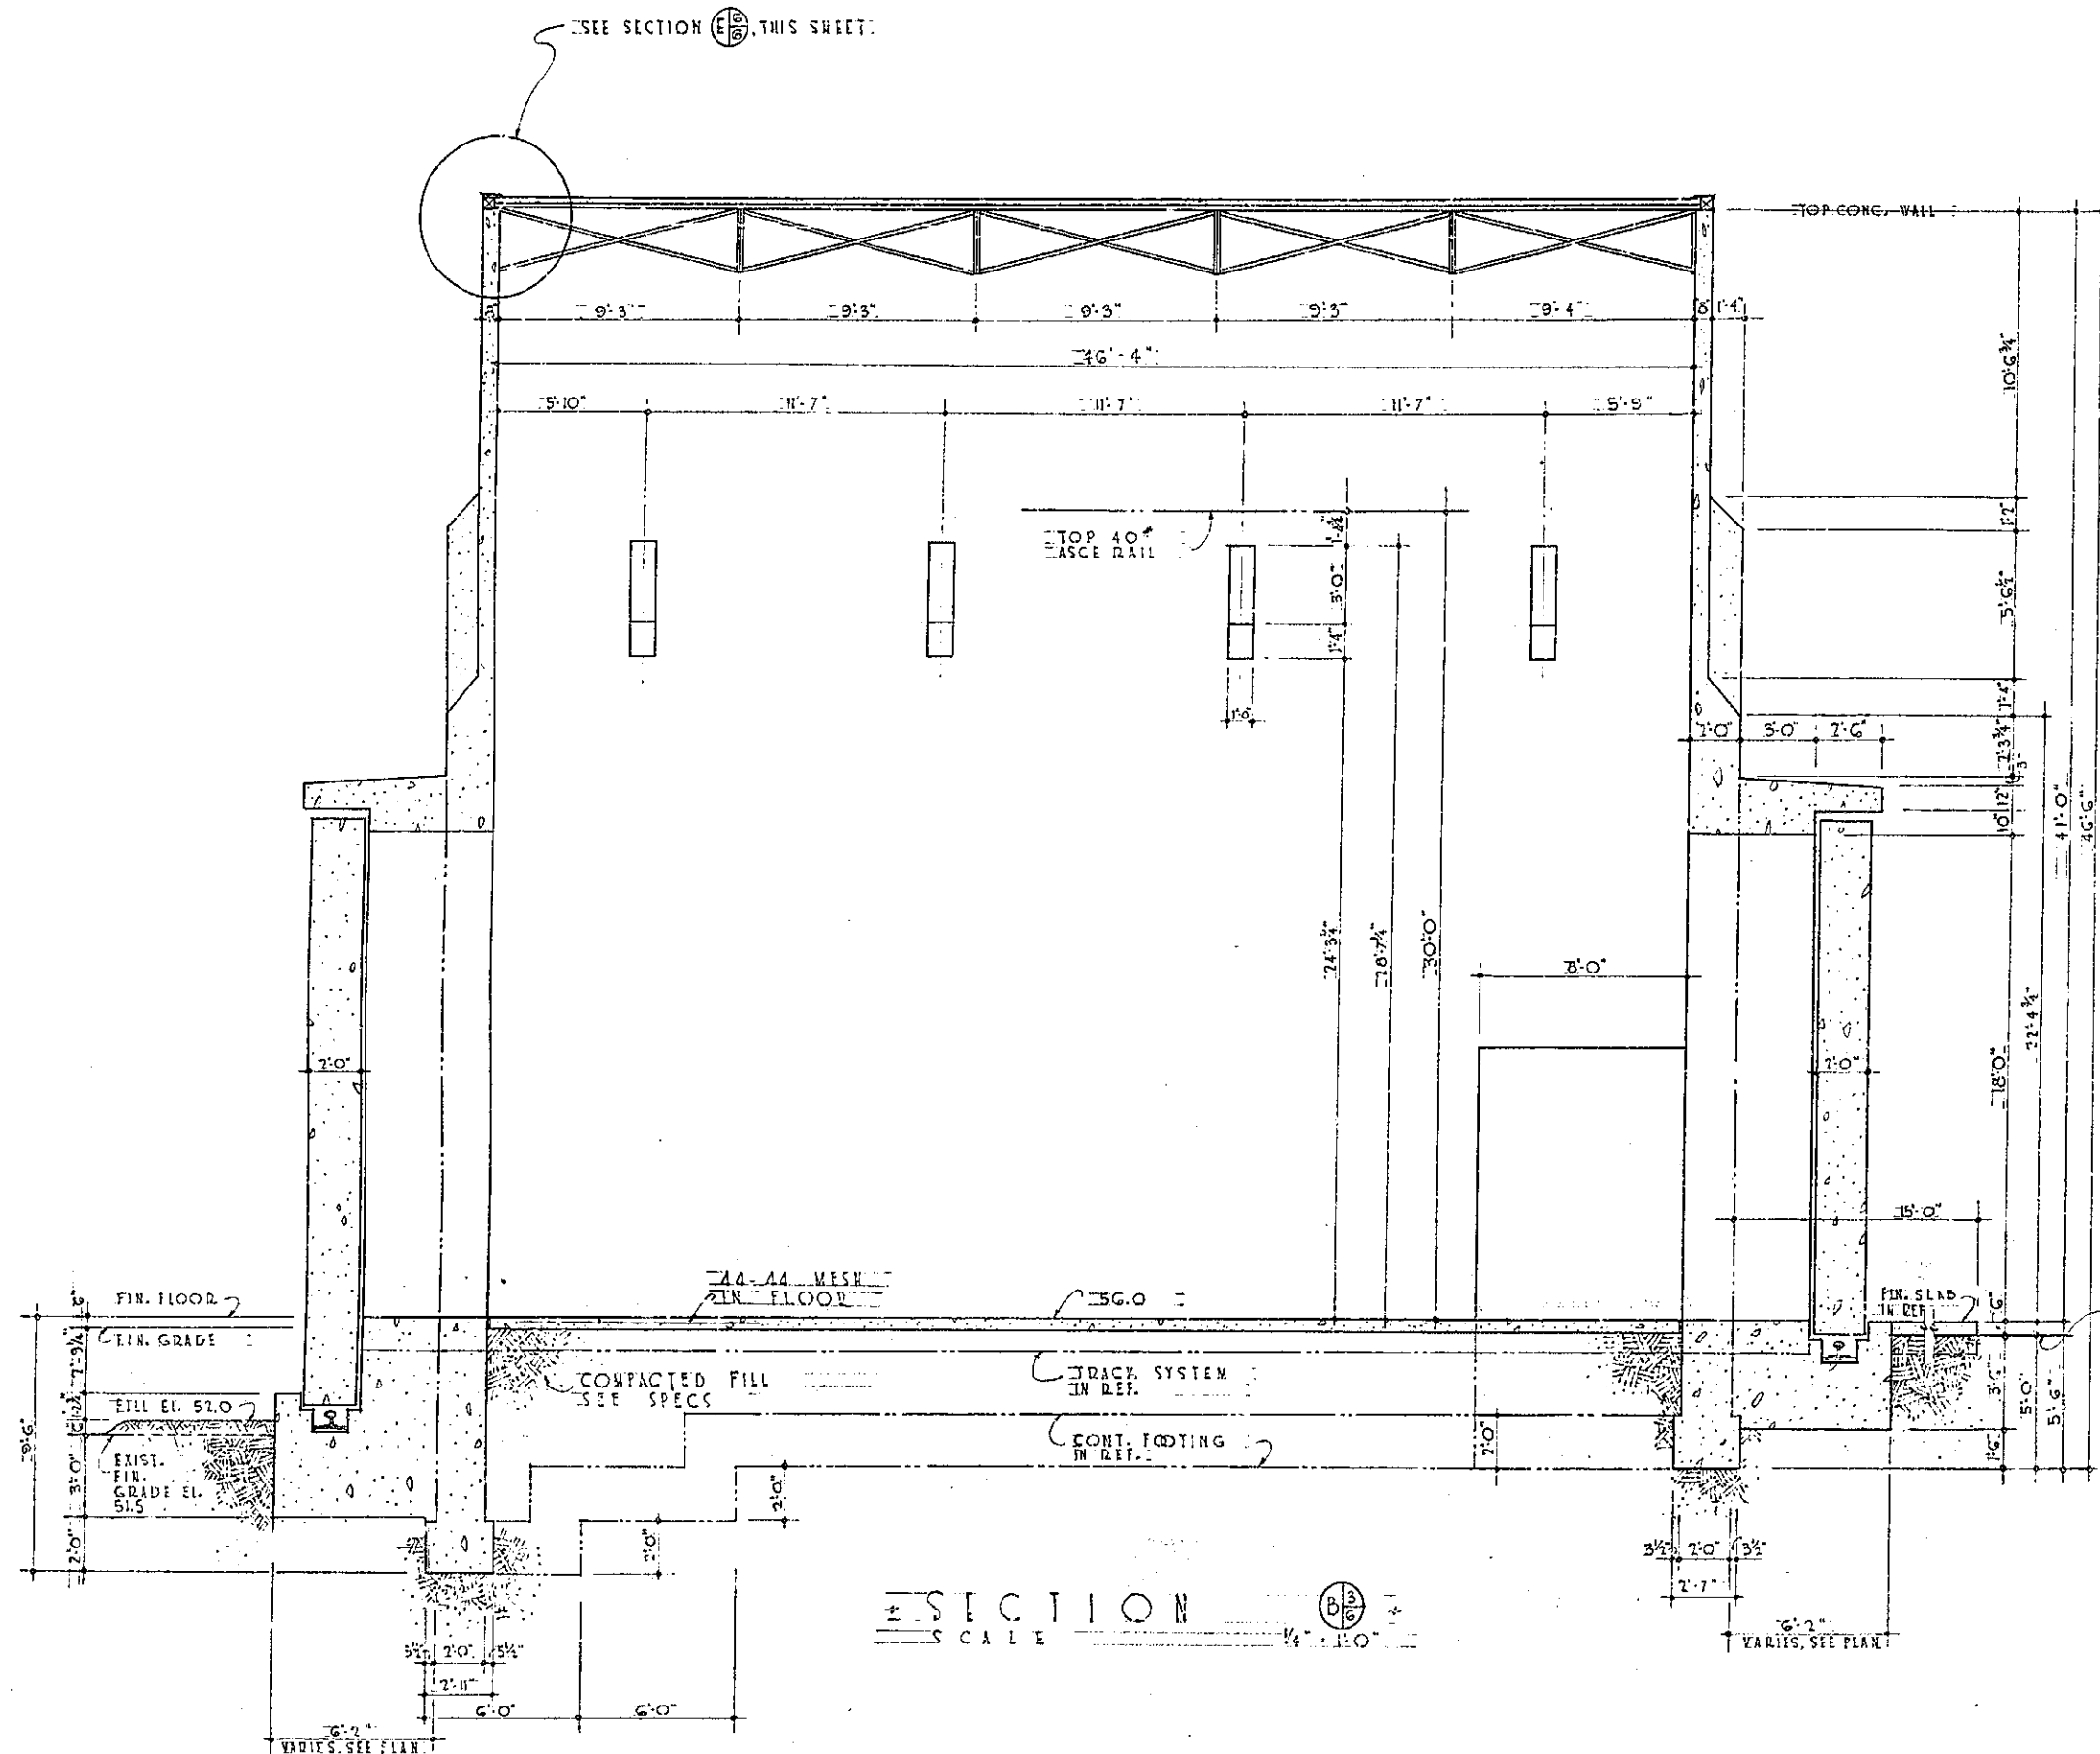

REVISION	DATE	DESCRIPTION	BY
DEPARTMENT OF THE AIR FORCE OGDEN AIR MATERIAL AREA OFFICE OF INSTALLATIONS			
HILL AIR FORCE BASE DESIGNED BY G.O. JONES DRAWN BY D.A. GIVINS TRACED BY B. KOT 1857 CHECKED BY DATE			
MODIFICATION OF BUILDING N° 213 FOR X-RAY FACILITIES			
TYPICAL SECTIONS THRU BUILDING			
APPROVED BY DATE J. H. Jones		APPROVAL RECOMMENDED J. H. Jones	
APPROVED BY DATE Paul R. Rasmussen		PROJECT NO. H-79-8	
APPROVED BY DATE C. R. Williams		DRAWING NUMBER 58-3837	
SHEET 6 OF 18 SCALE 1/4" = 1'-0"			

2113-57-A

49-41

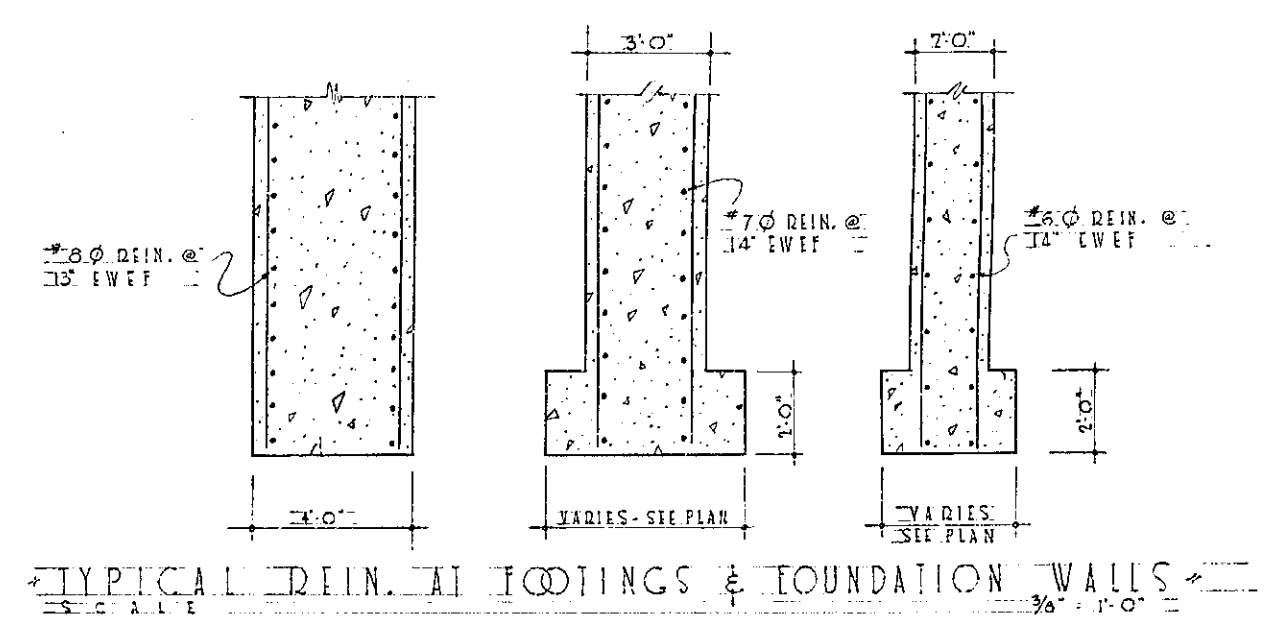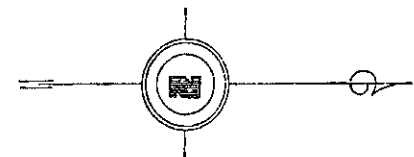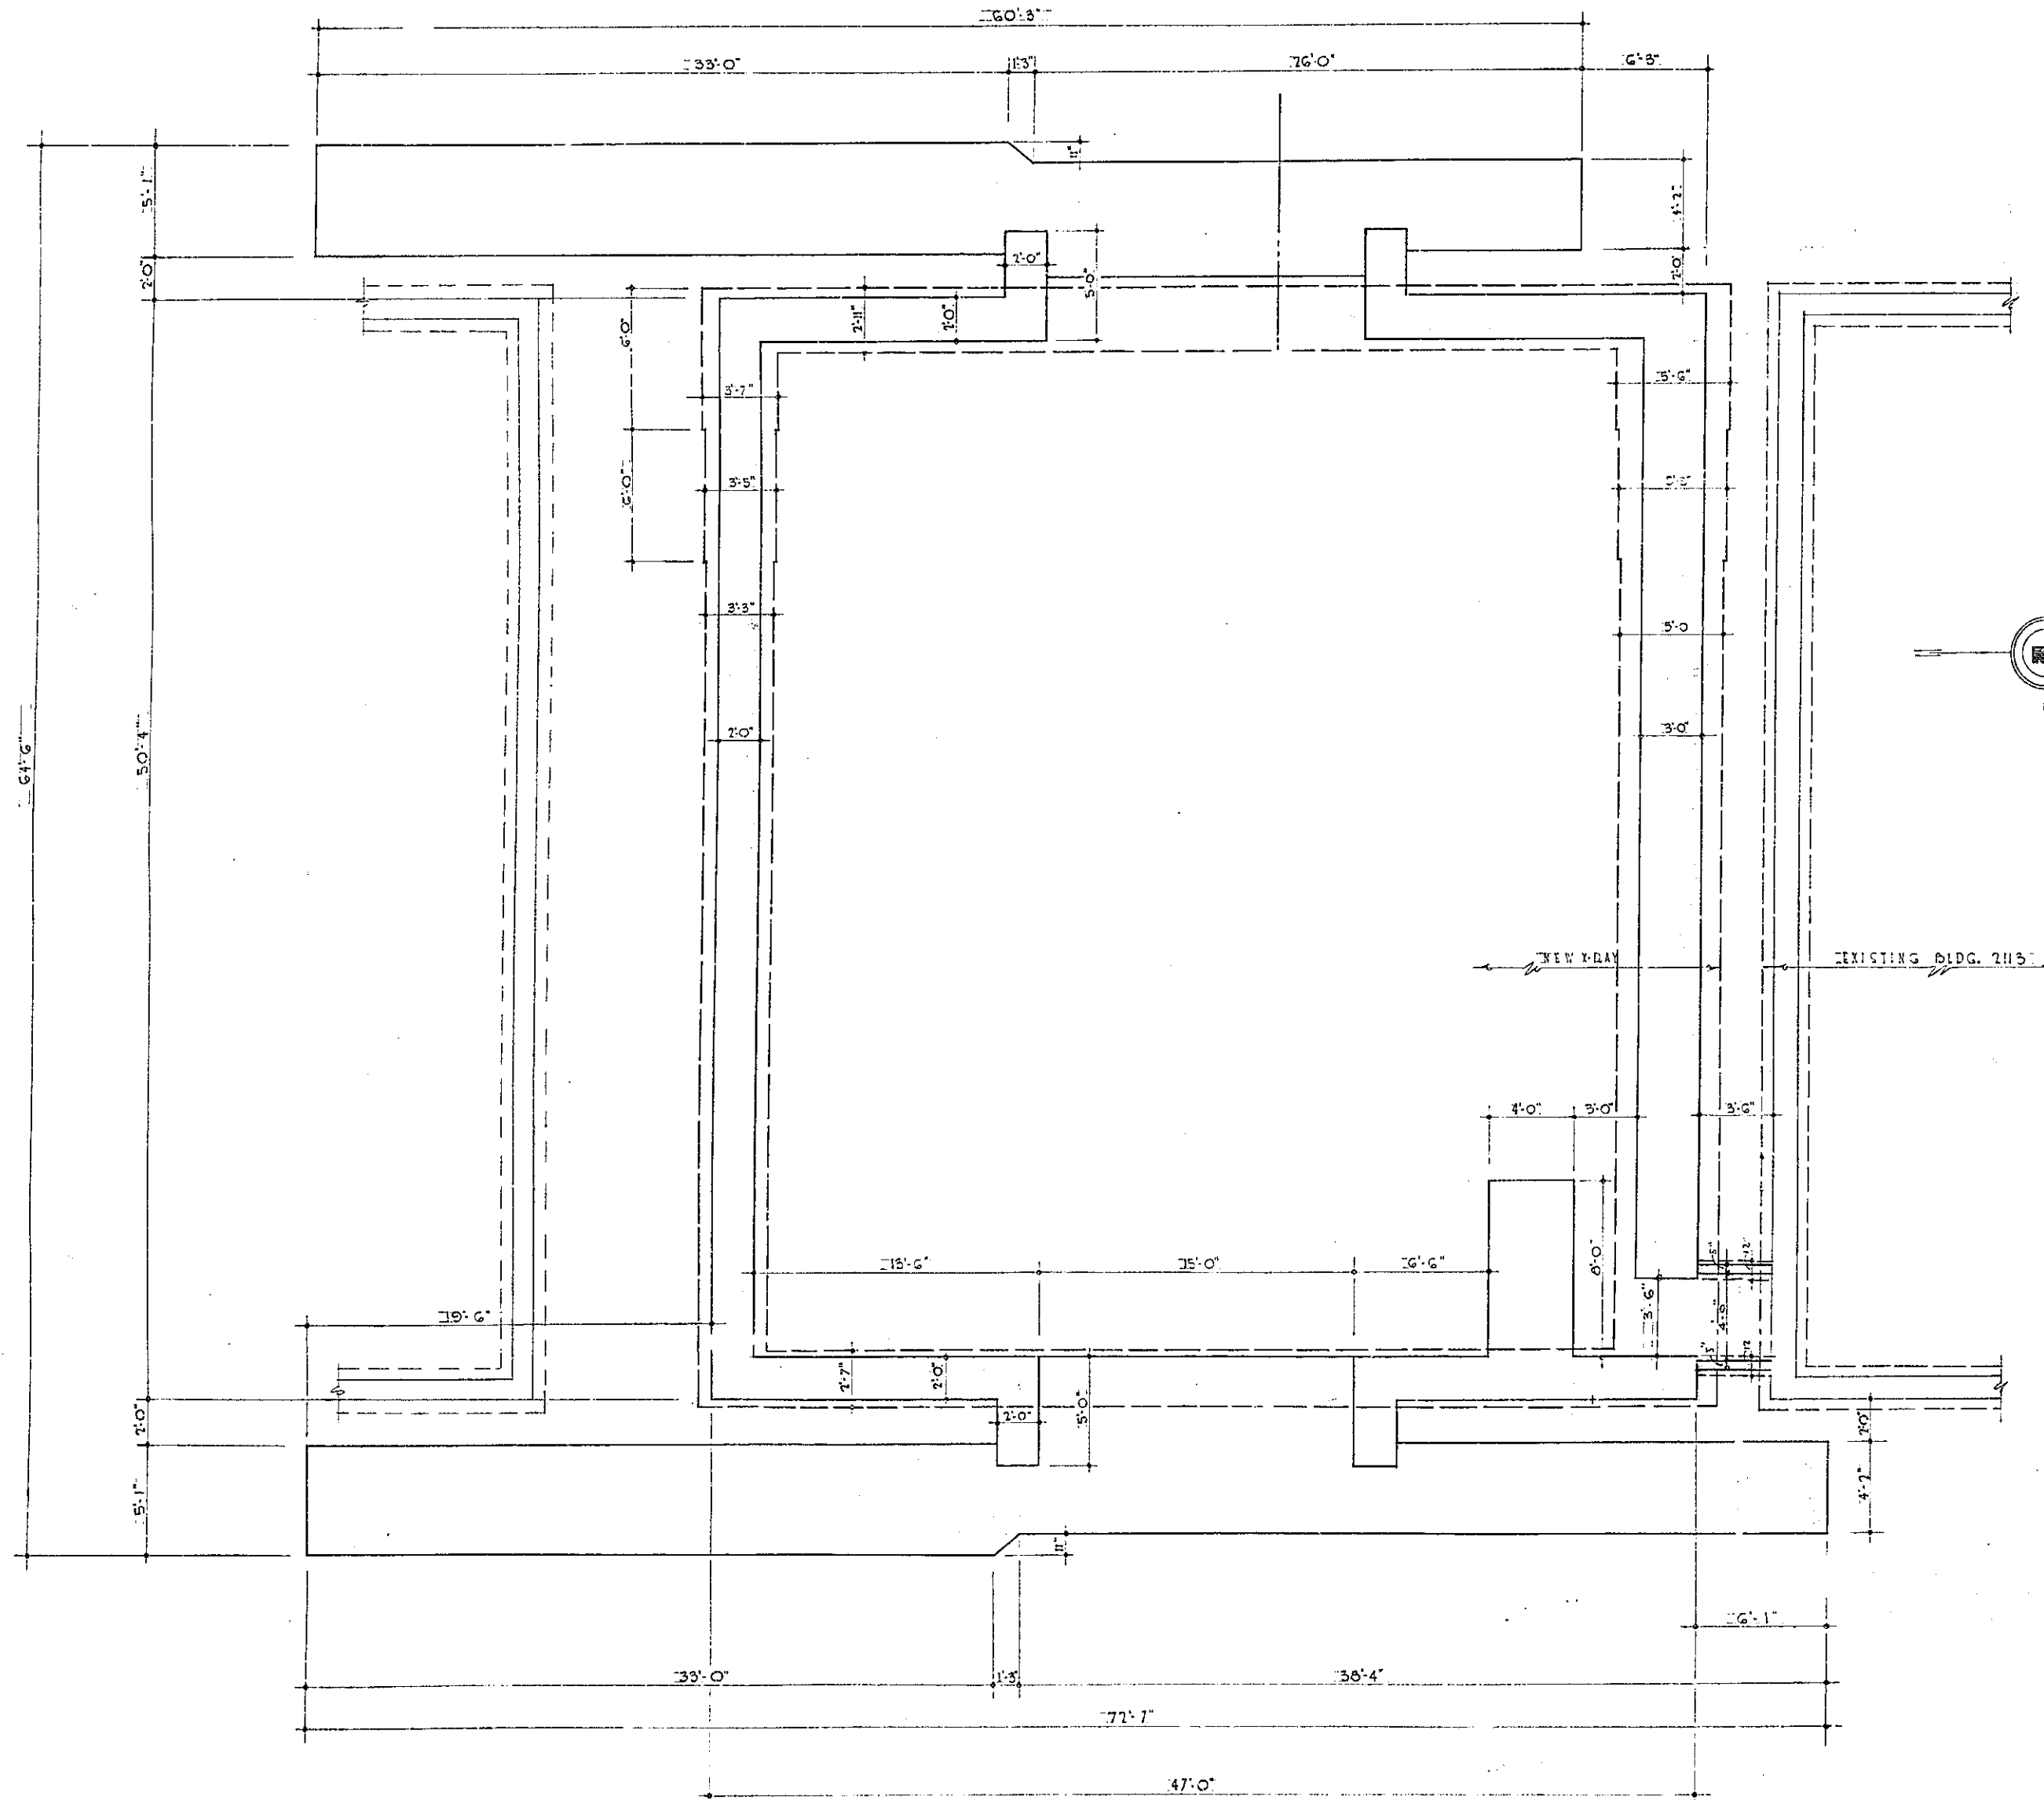

FOOTING & FOUNDATION PLAN
SCALE 1/4" = 1'-0"

REVISION	DATE	DESCRIPTION	BY
DEPARTMENT OF THE AIR FORCE ODGEN AIR MATERIAL AREA OFFICE OF INSTALLATIONS ODGEN, UTAH			
HILL AIR FORCE BASE		DESIGNED BY <u>W. L. DALLS</u> DRAWN BY <u>W. L. DALLS</u> CHECKED BY <u>W. L. DALLS</u> DATE <u>10-1-57</u>	
APPROVED BY <u>W. L. DALLS</u> DATE <u>10-1-57</u>		APPROVAL RECOMMENDED <u>W. L. DALLS</u> DATE <u>10-1-57</u>	
PROJECT NO. <u>411-29-8</u>		DRAWING NUMBER <u>58-3837</u>	
SHEET <u>1</u> OF <u>1</u>		SCALE <u>1/4" = 1'-0"</u>	

2113-57-A

99-92

225

DETAIL @ DOOR HD. #2
SCALE 1 1/2" = 1'-0"

DETAIL @ DOOR JAMB #2
SCALE 1 1/2" = 1'-0"

STAIR DETAIL SECTION 

SCALE $3/4" = 1' - 0"$

PLAN SECTION

SCALE 3/4" = 1'-0"

LATERAL DOOR SUPPORT

SCALE 3" = 1'-0"

AT WALL
SCALE 3/8" = 1'-0"

CRANE RUNWAY
SCALE 1/4" = 1'-0"

SECTION



SCALE 3/4" = 1'-0"

AT DOOR OPENING
SCALE $3/8" = 1' - 0"$


HEAD & JAMB DETAIL @ 12" CONC. WALL.
SCALE: 1 1/2" = 1' - 0"

REVISION	DATE	DESCRIPTION	BY
		DEPARTMENT OF THE AIR FORCE ODDEN AIR MATERIAL AREA OFFICE OF INSTALLATIONS	
HILL AIR FORCE BASE		ODDEN, UTAH	
DESIGNED BY <u>G. G. JOHNS</u>		MODIFICATION OF BUILDING NO 2113 FOR X-RAY FACILITIES MISC. STRUCTURAL DETAILS	
DRAWN BY <u>L. G. SALLIDY</u>			
TRACED BY			
CHECKED BY DATE			
APPROVED BY DATE			
<u>W. B. Smith 2 Dec 57</u>			
SUBMITTED	APPROVAL RECOMMENDED	APPROVAL	
<u>W. B. Smith</u>	<u>John A. Smith</u>	<u>W. B. Smith</u>	
APPROVED DATE	PROJECT NO.	DRAWING NUMBER	
<u>W. B. Smith 13 Dec 57</u>	<u>111-29-8</u>	<u>58-3837</u>	
APPROVED DATE			
<u>W. B. Smith 13 Dec 57</u>			
APPROVED DATE			
<u>W. B. Smith 13 Dec 57</u>			
SHEET <u>6</u> OF <u>18</u> SCALE <u>NOTES</u>			

GATE POST & FOOTING SCHEDULE		
GATE WIDTH	POST SIZE, STD. PIPE OR EQUIV.	CONCRETE FOOTING SIZE
10'-0" TO 14'-0"	MIN. 2.875 O.D.	2'-0" x 1'-0" x 1'-0" FTG. WITH 1'-4" SQUARE REIN. CONCRETE FIB. FOUNDED MONOLITHIC
14'-0" TO 18'-0"	MIN. 4" O.D.	2'-4" x 1'-4" x 1'-0" FTG. WITH 1'-8" SQUARE REIN. CONCRETE FIB. FOUNDED MONOLITHIC
18'-0" TO 24'-0"	MIN. 6.625 O.D.	3'-0" x 1'-8" x 1'-0" FTG. WITH 1'-8" SQUARE REIN. CONCRETE FIB. FOUNDED MONOLITHIC

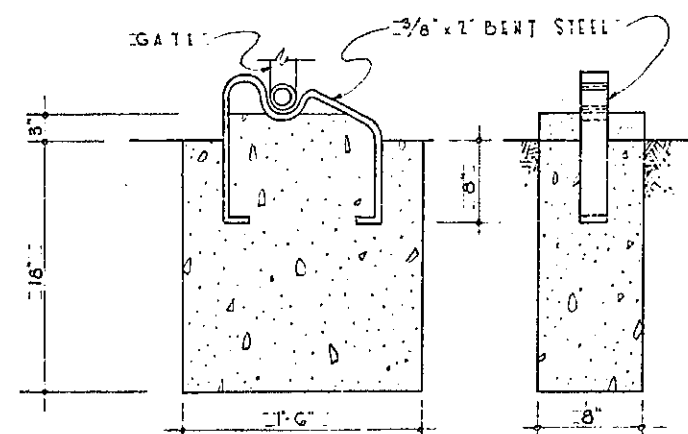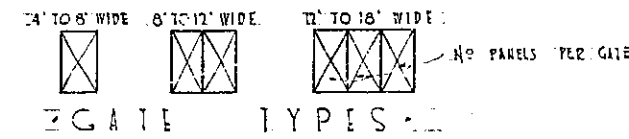


SCALE 1/4" = 1'-0"

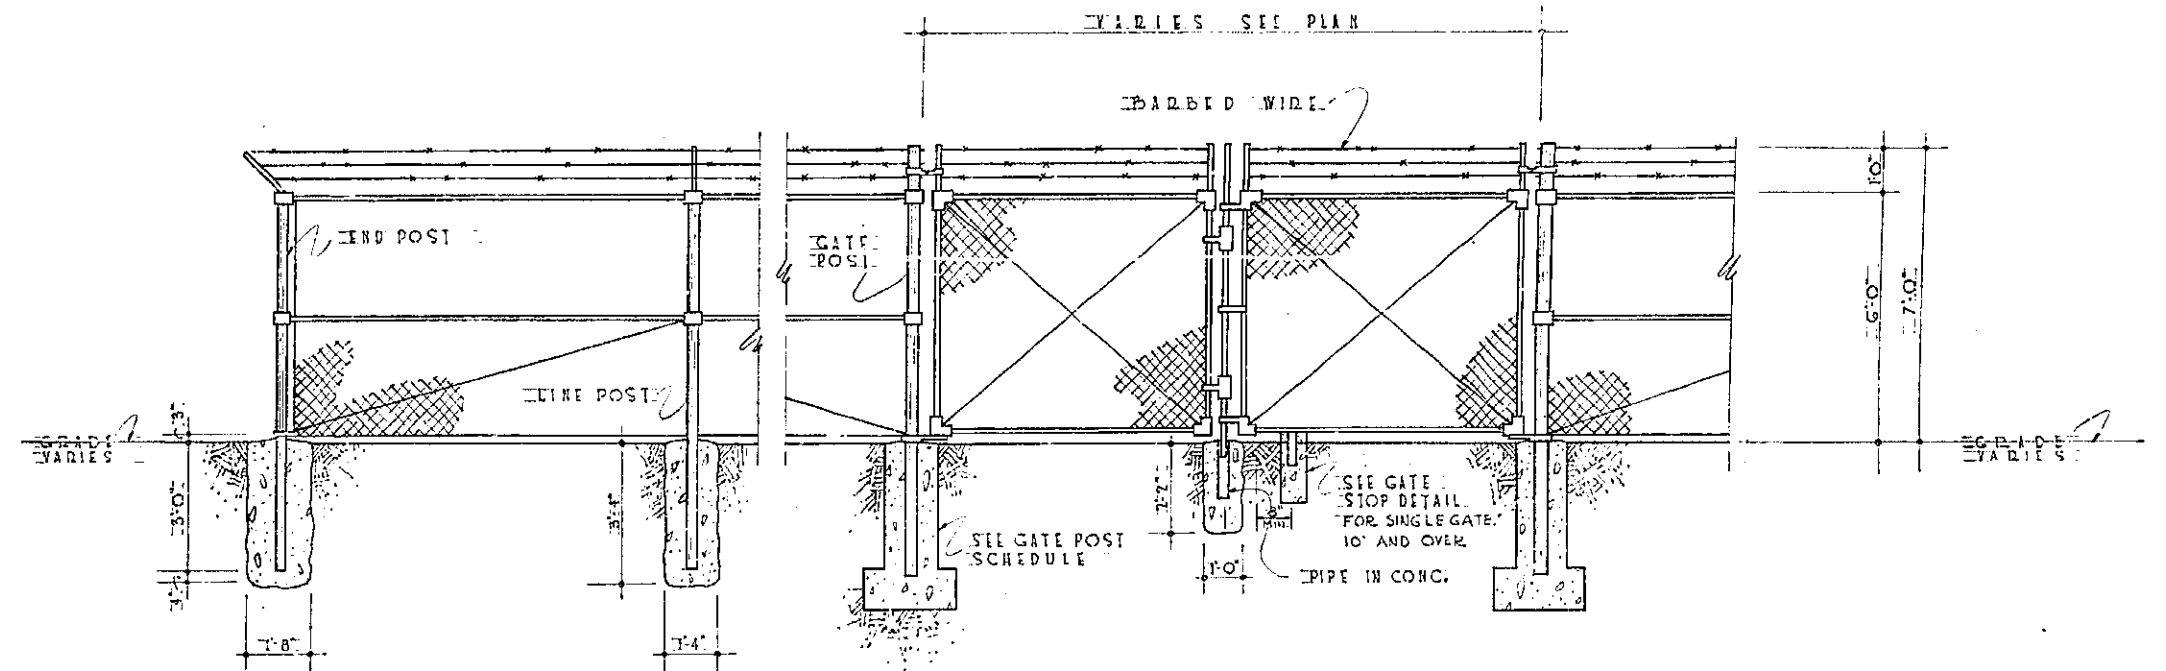


SCALE 1/8" = 1'-0"

FENCE NOTES:


- ALL GATES TO HAVE PADLOCK LATCHES (LOCKS FURNISHED BY GOVT.)
- GATES TO OPEN TO 180° WHERE POSSIBLE & TO BE EQUIPPED WITH GATE POST (AS SHOWN ON DWG.) TO HOLD GATES IN OPEN POSITION.
- ALL METAL USED ON FENCES & GATES TO BE HOT DIPPED GALVANIZED.

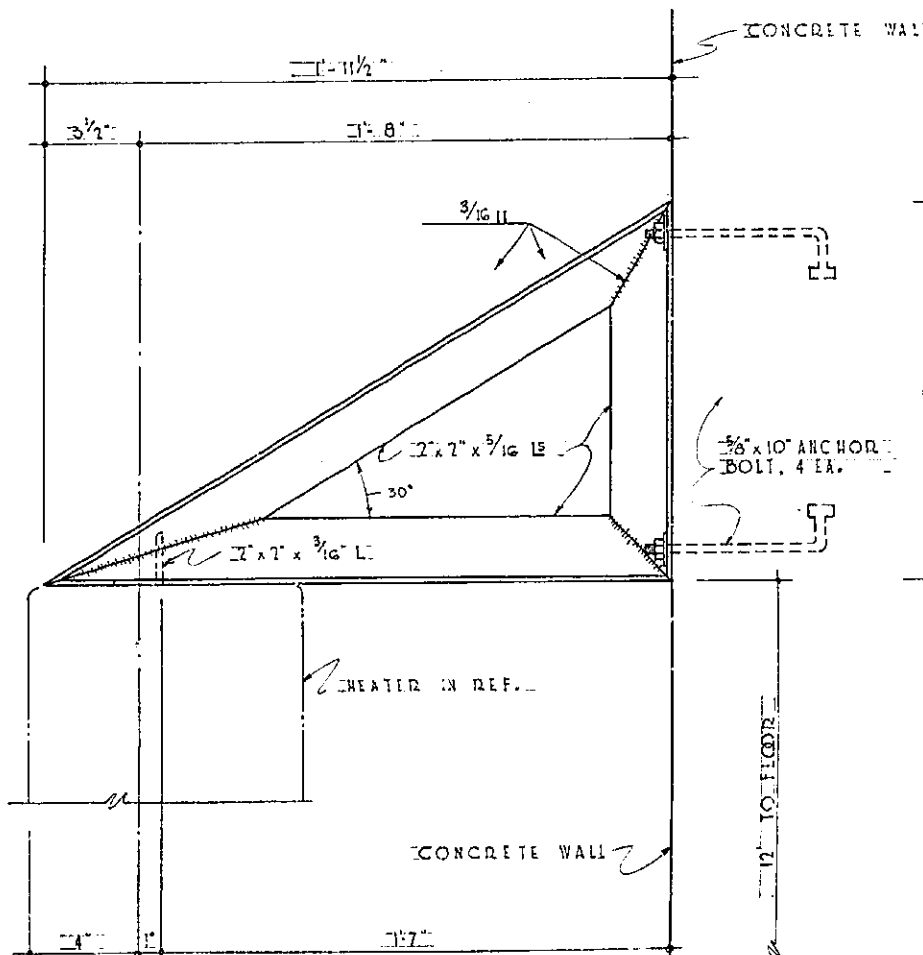


SCALE 1/4" = 1'-0"

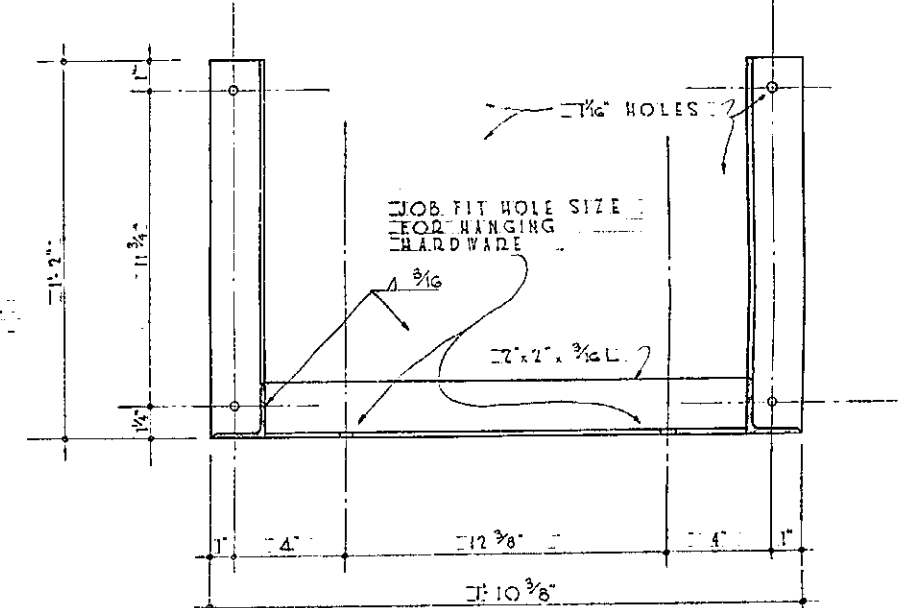


SCALE 1/4" = 1'-0"

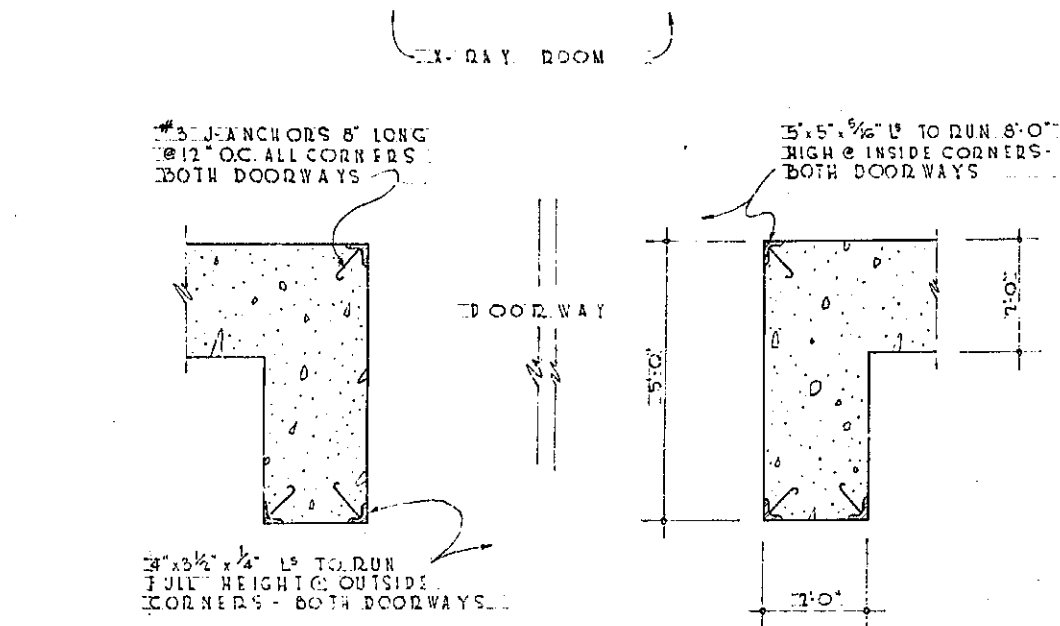


SCALE 1/4" = 1'-0"

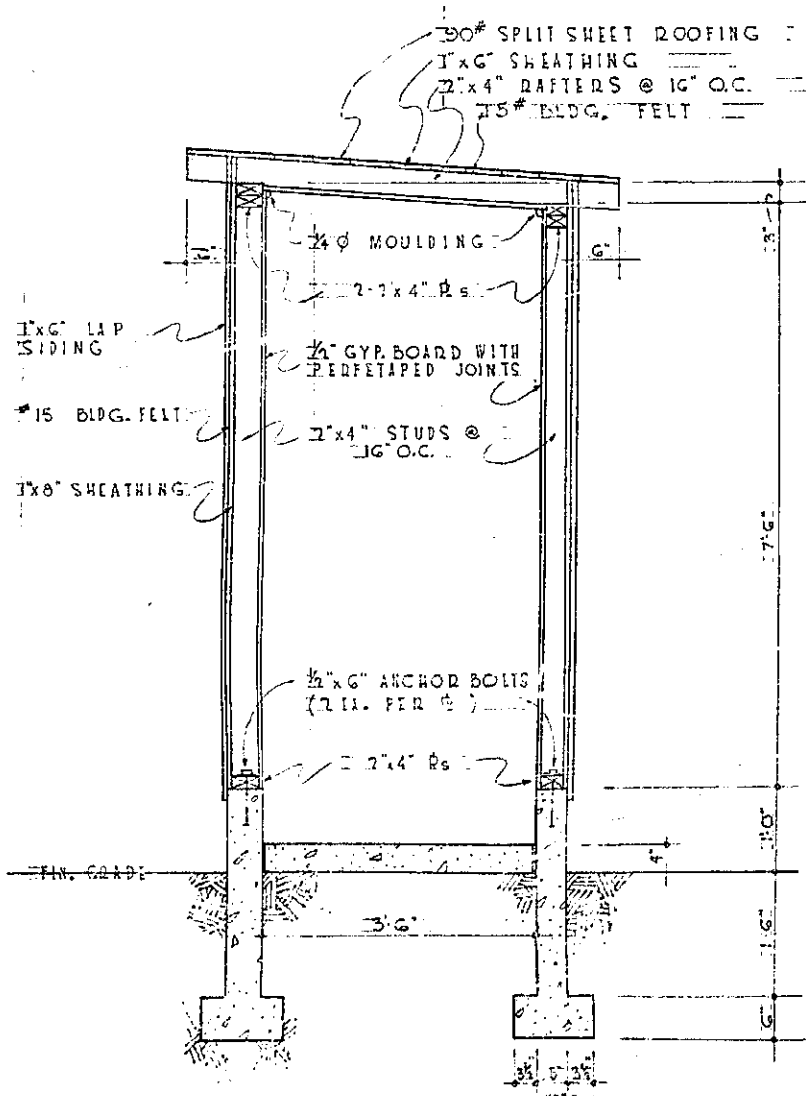

SCALE 1/4" = 1'-0"

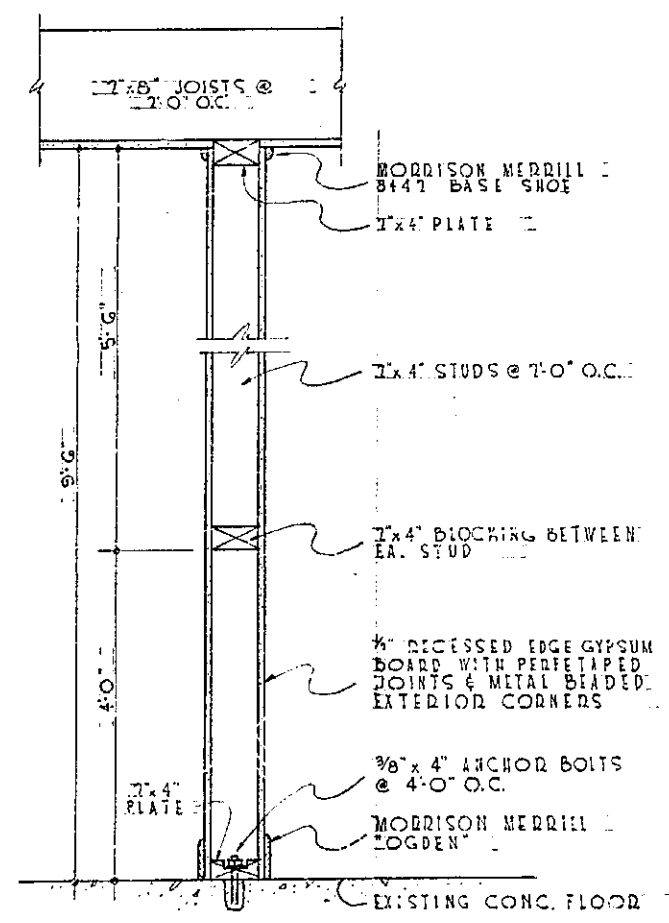

SCALE 1/4" = 1'-0"

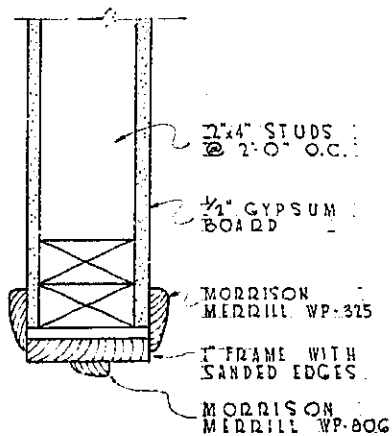



SCALE 1/4" = 1'-0"

SCALE 1/4" = 1'-0"







REVISION	DATE	DESCRIPTION	BY
DEPARTMENT OF THE AIR FORCE OGDEN AIR MATERIAL AREA OFFICE OF INSTALLATIONS OGDEN, UTAH			
HILL AIR FORCE BASE			
DESIGNED BY	DATE	MODIFICATION OF BUILDING NO. 2113 FOR	
DRAWN BY	DATE	X-RAY FACILITIES	
CHECKED BY	DATE	MISCELLANEOUS & FENCE DETAILS	
APPROVED BY	DATE	APPROVAL RECOMMENDED	
SUBMITTED	DATE	PROJECT NO. 411-79-8	
APPROVED	DATE	DRAWING NUMBER	
APPROVED	DATE	58-3837	
APPROVED	DATE	SHEET 10 OF 18 SCALE 1/4" = 1'-0"	

2113-57-A

49-44

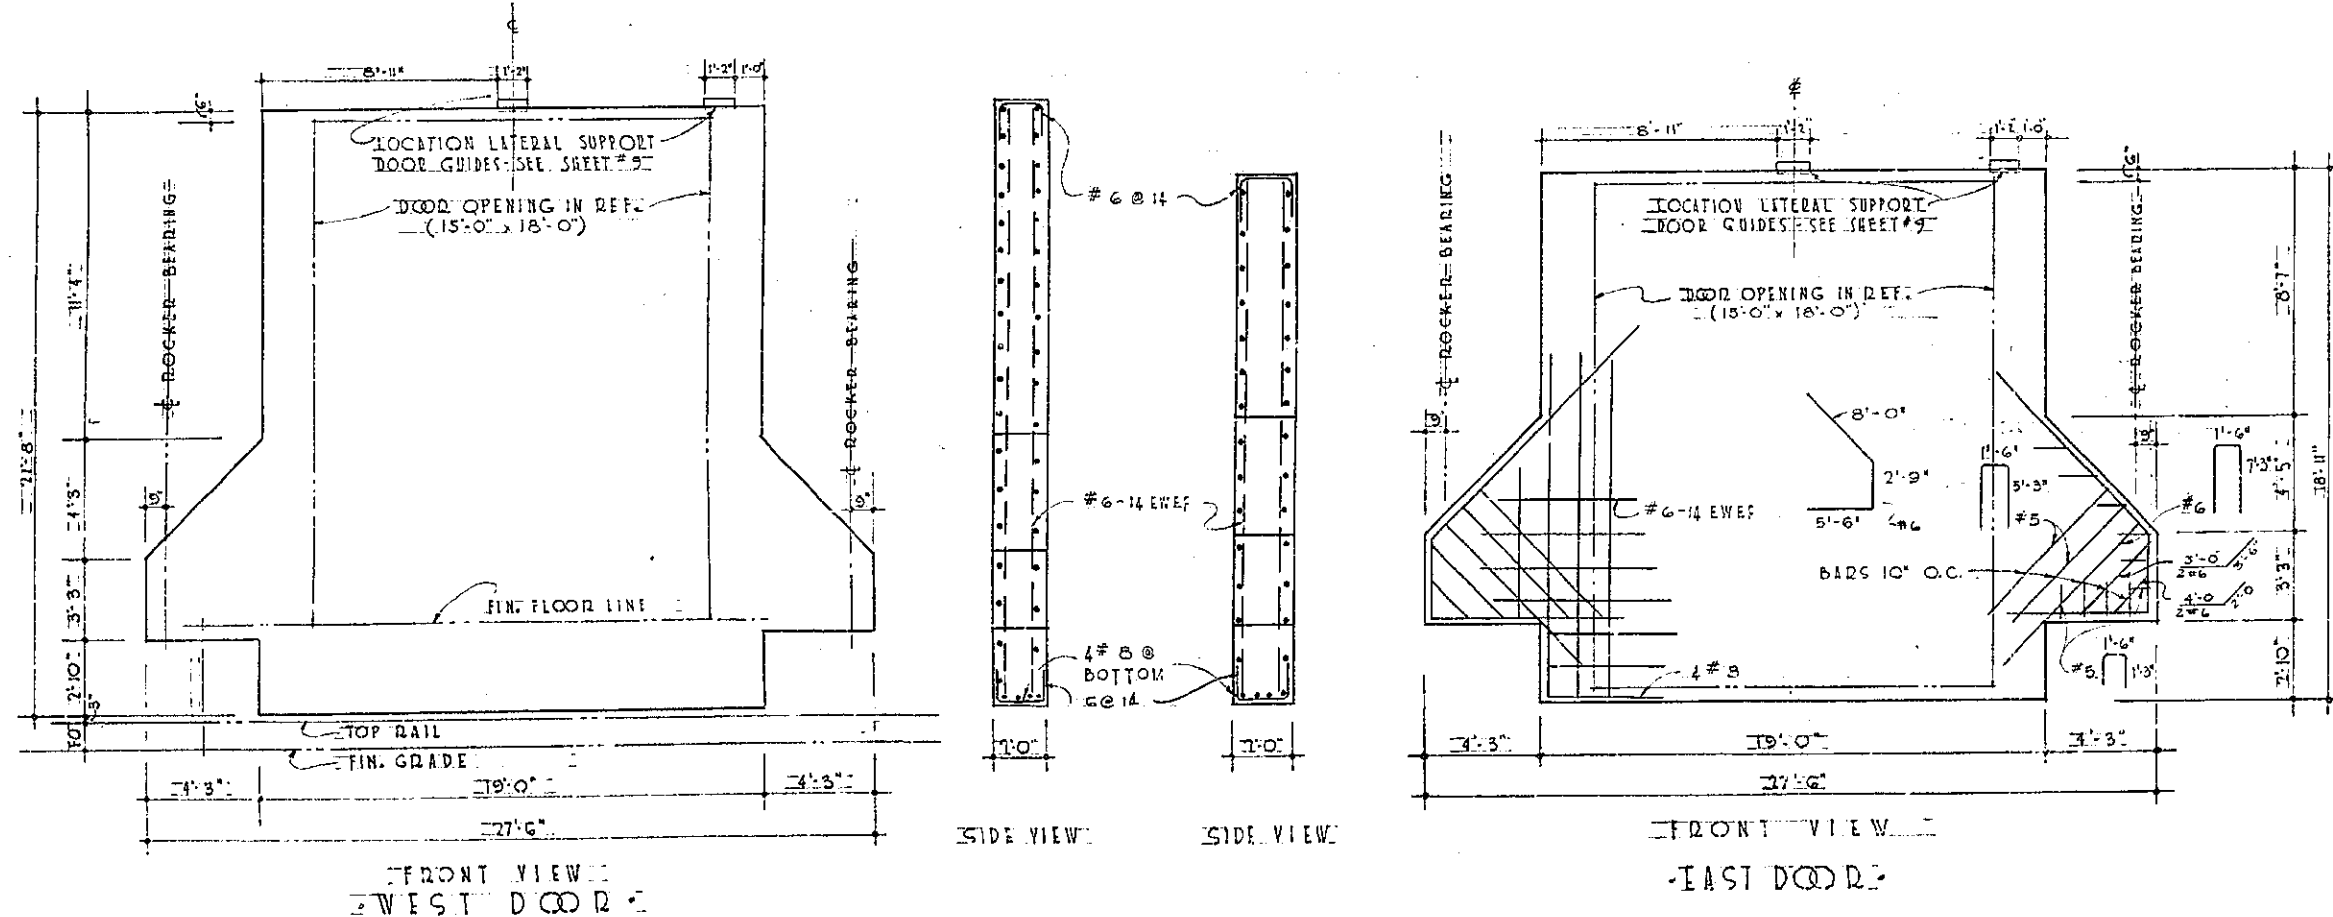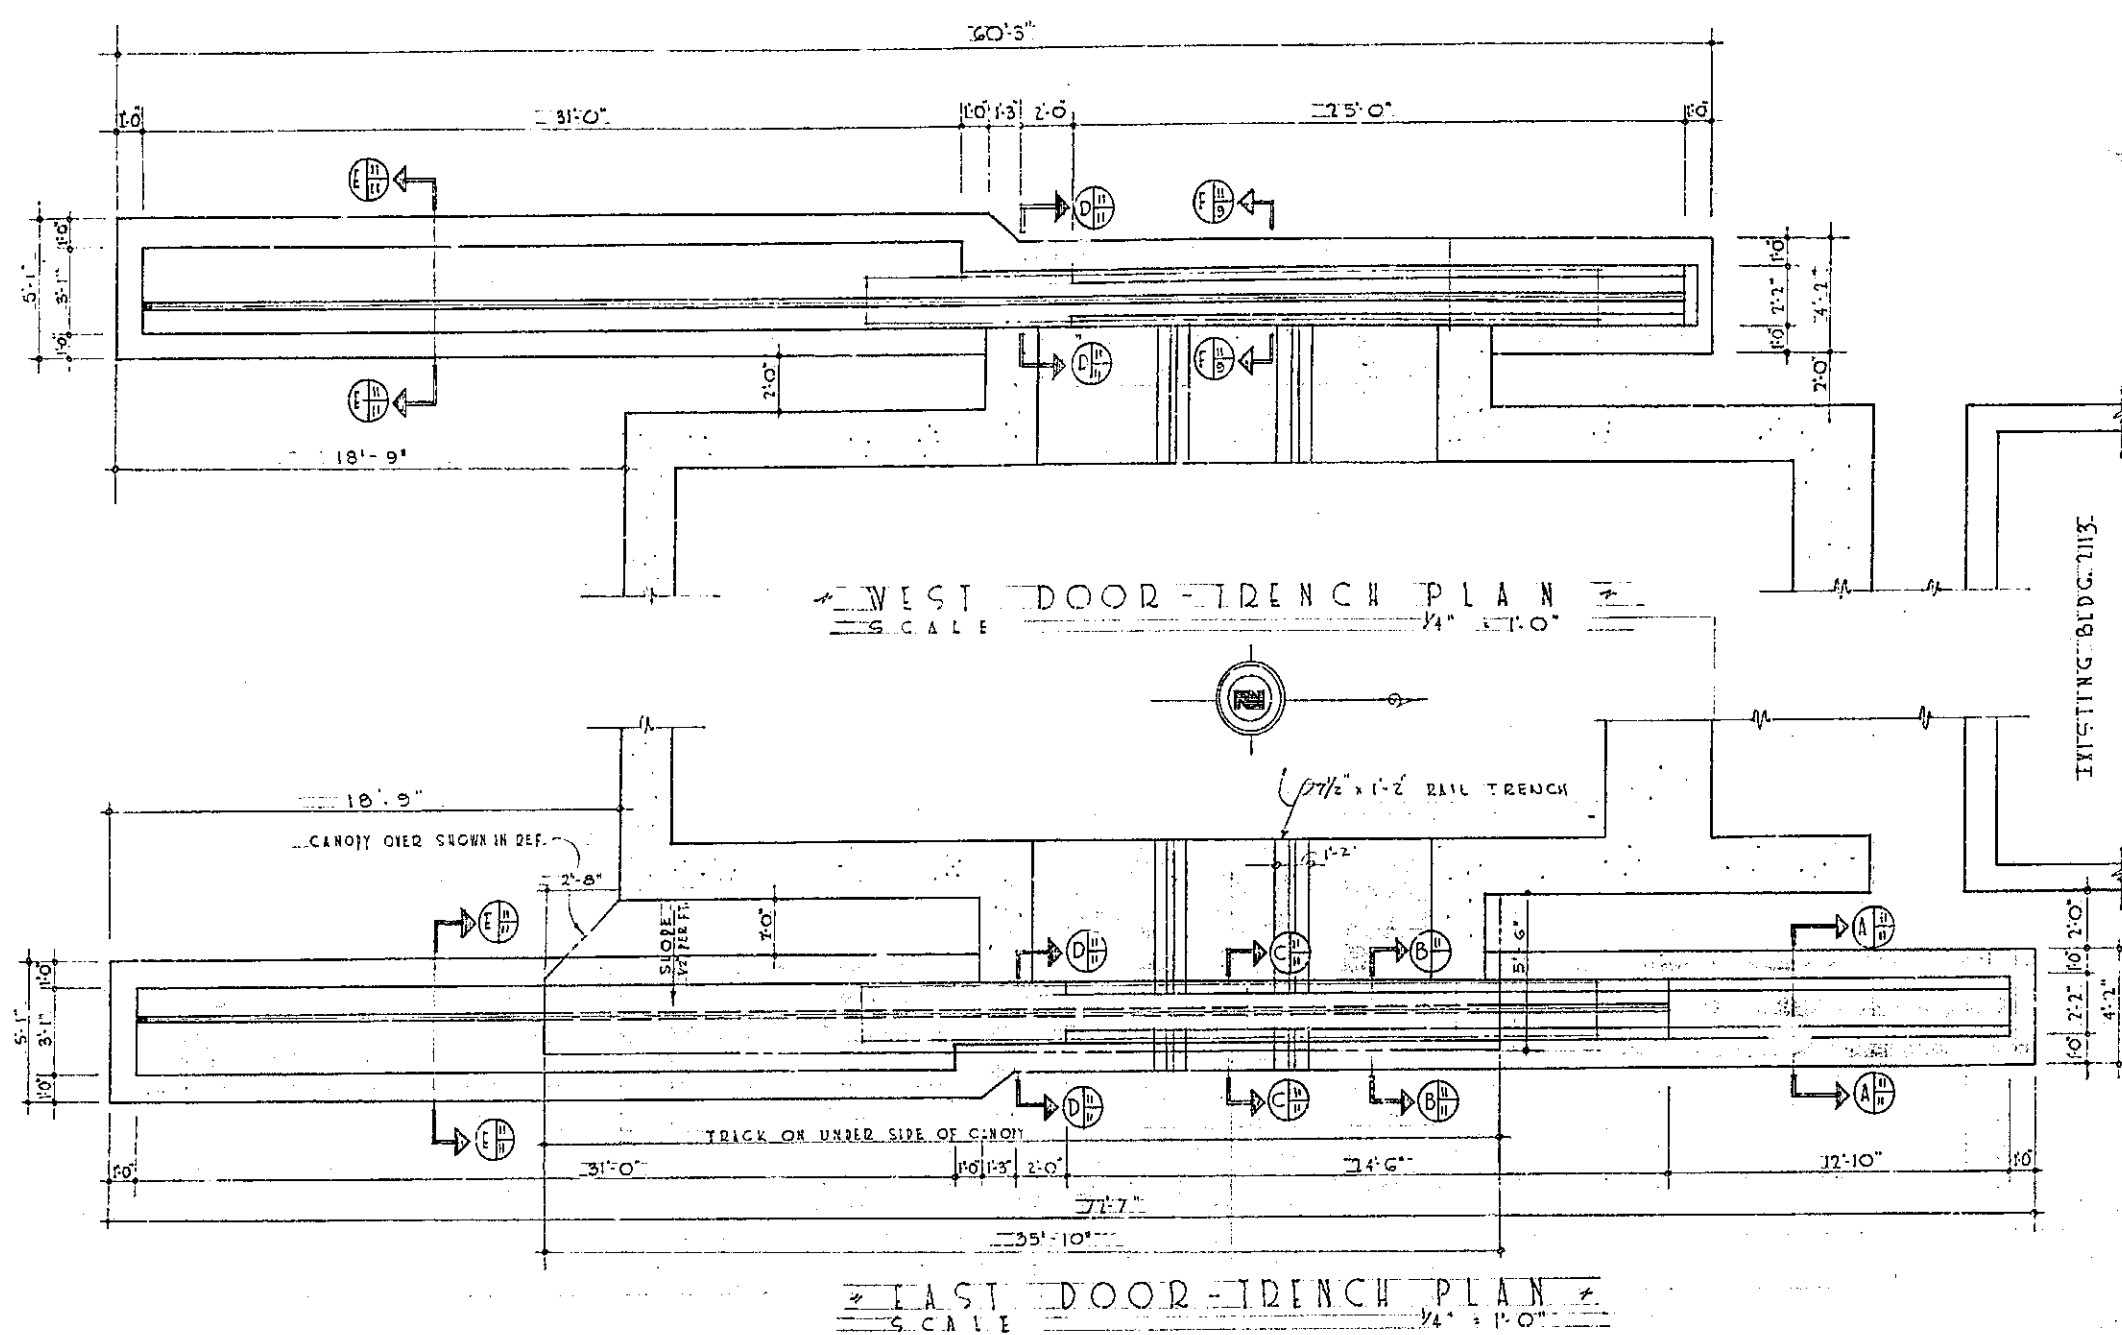


CONCRETE SLIDING DOOR DETAILS
SCALE 1/4" = 1'-0"

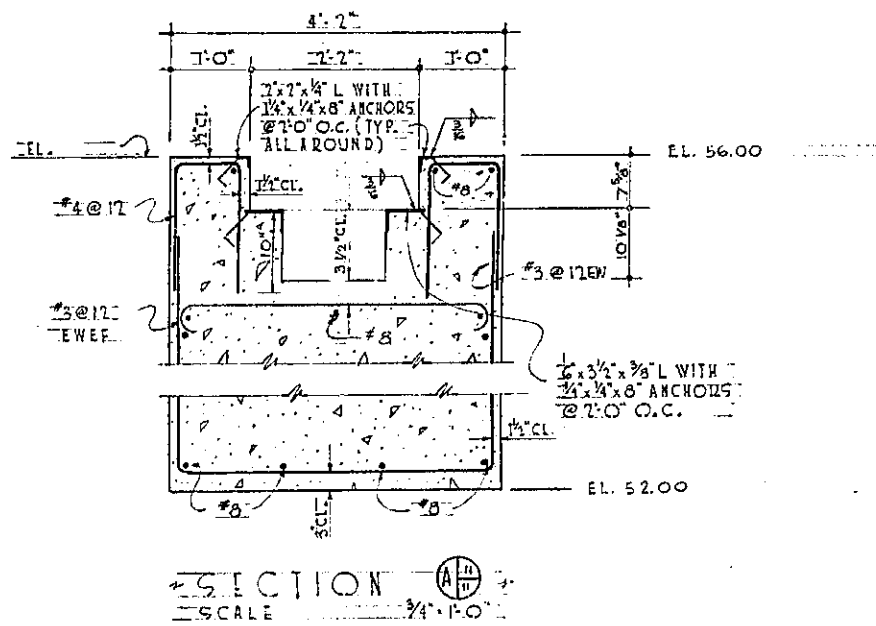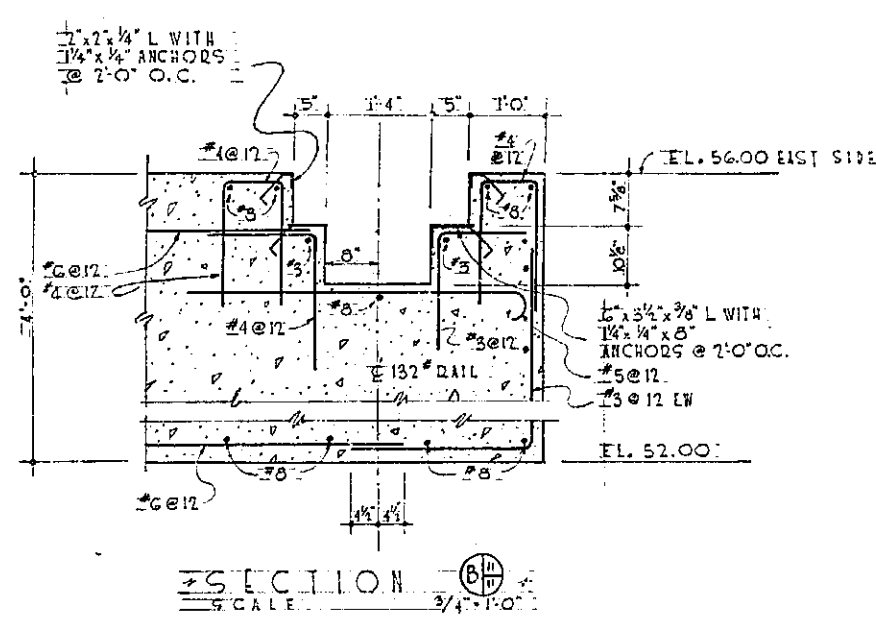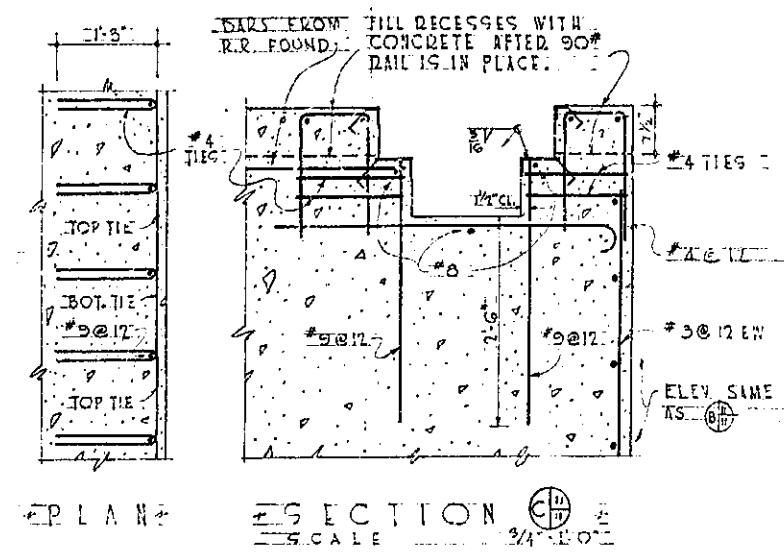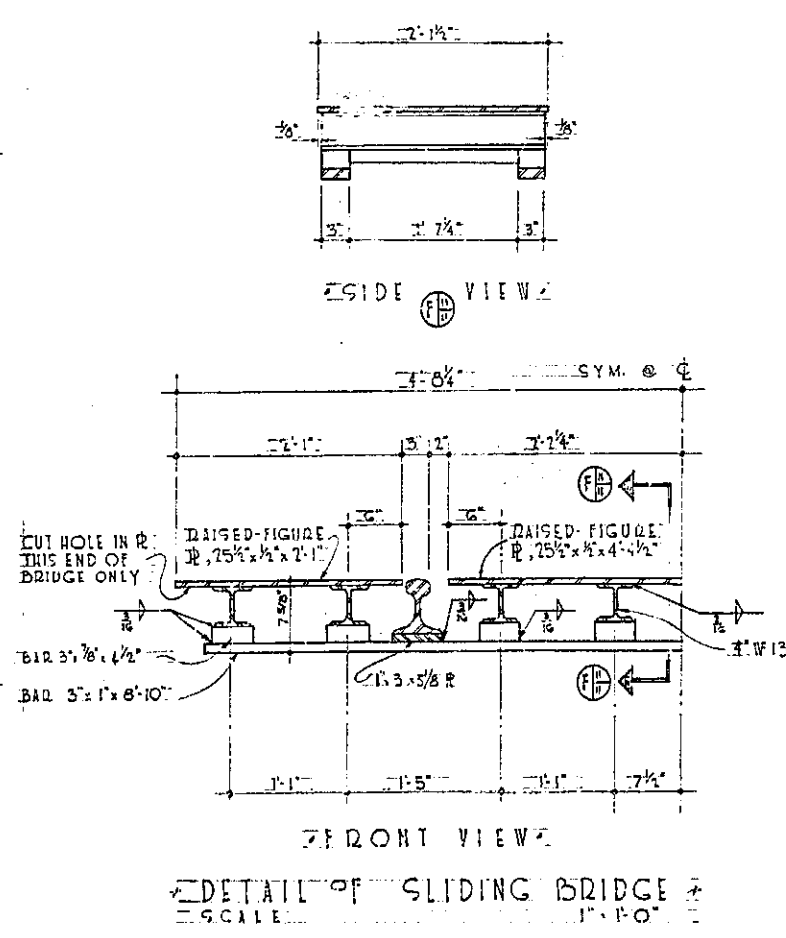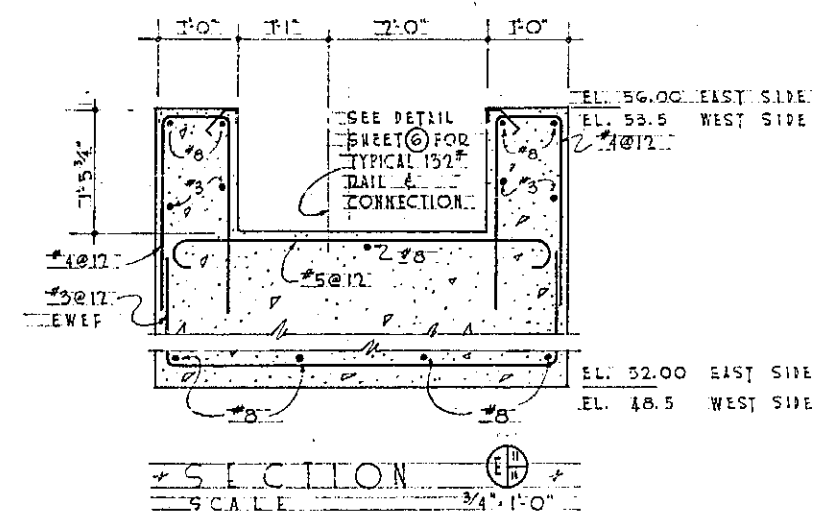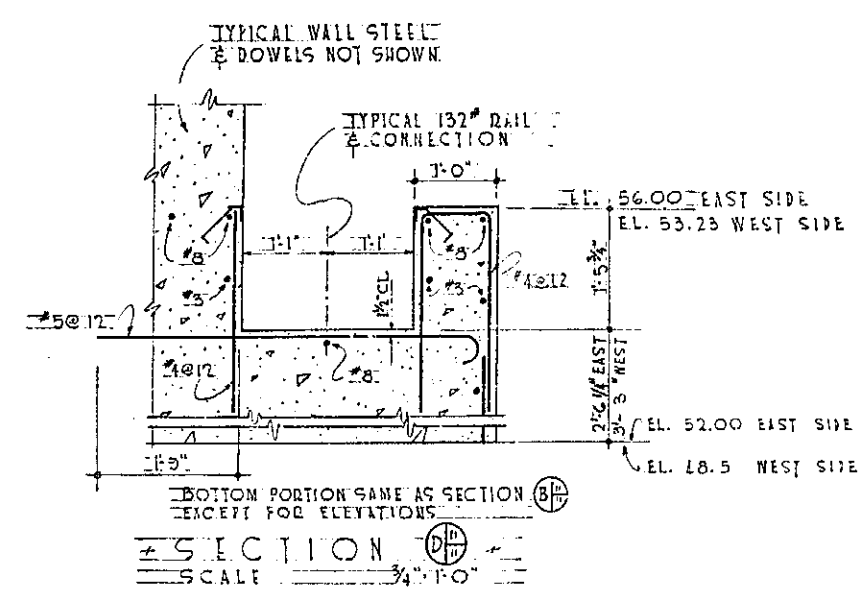

REVISION	DATE	DESCRIPTION	BY
DEPARTMENT OF THE AIR FORCE ODGEN AIR MATERIAL AREA OFFICE OF INSTALLATIONS			
MODIFICATION OF BUILDING NO 2113 FOR X-RAY FACILITIES			
CONC. DOOR & TRACK DETAILS			
DESIGNED BY	DATE	APPROVAL RECOMMENDED	APPROVED
DRAWN BY	DATE	DATE	DATE
CHECKED BY	DATE	DATE	DATE
APPROVED BY	DATE	DATE	DATE
PROJECT NO.		DRAWING NO. JER	
HHL-29-8		58-38-7	
SHEET 10 OF 15		SCALE: 1/4" = 1'-0"	

2113-57-A

49-45

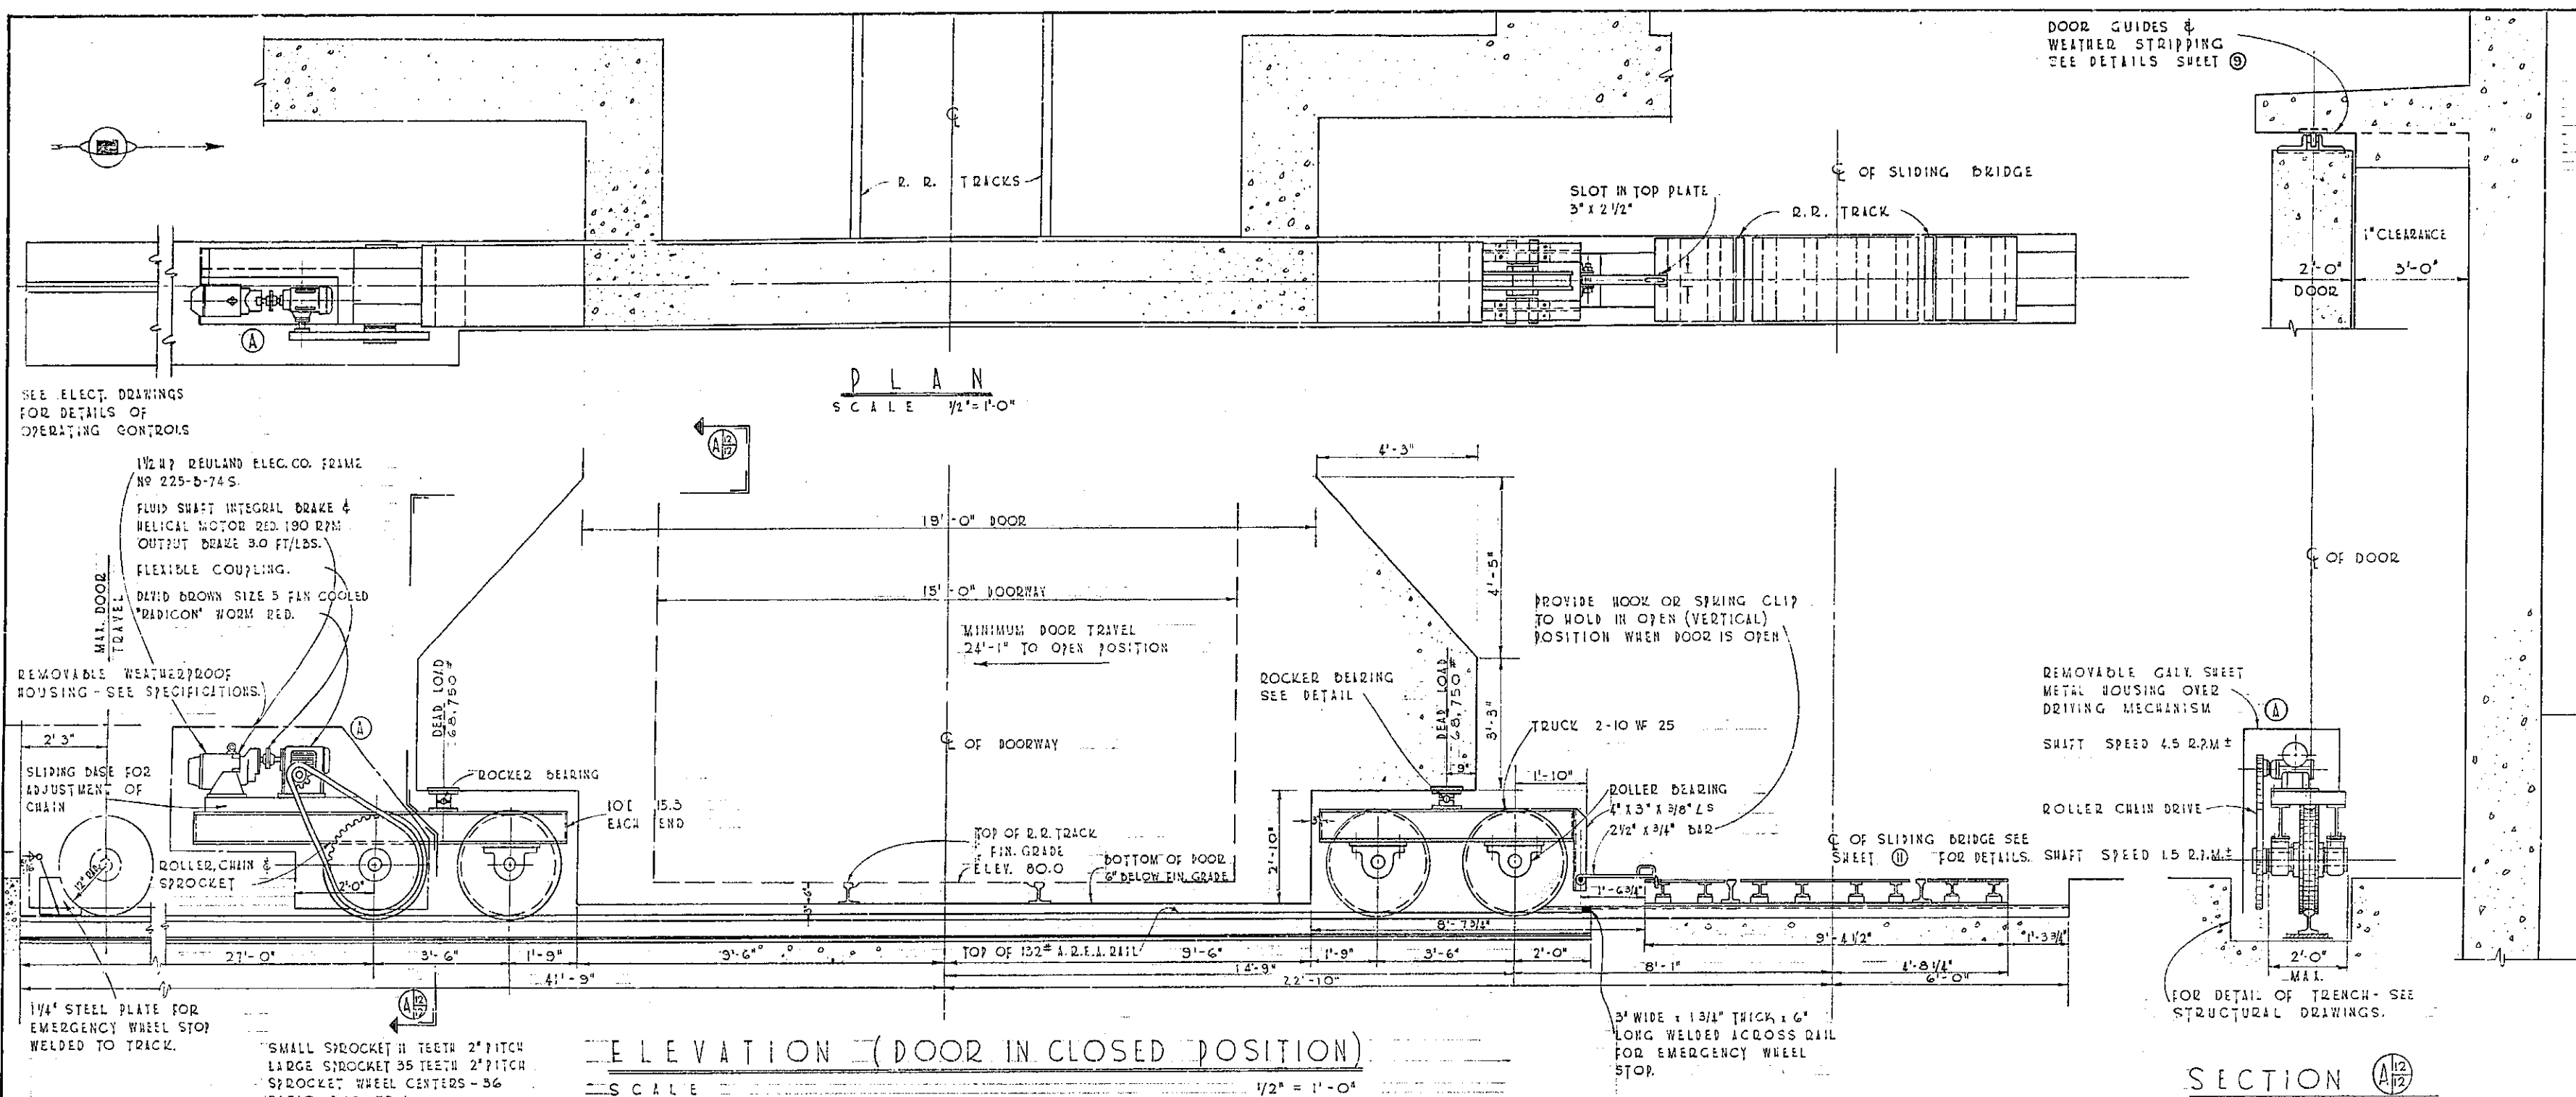

① CALCULATIONS

① MOTOR H.P. REQD. (SHAFT METHOD FOR BRIDGE DRIVES) - TRACTION = DR. WT. 1.5 TO 1 OF ROLLERS 1 ROLLER 500 LBS. COEFF. OF FRICTION = 0.05 TOTAL GEARING EFF. = 0.65

$$= 137,500 \times 1.5 \times 0.05 \times 0.65$$

$$= 1,368 \text{ LBS.}$$

MOTOR H.P. = TRACTION X DOOR SPEED 20,400 (FOR A.C. MOTORS)

$$= 1,368 \times 9.42$$

$$= 12,900$$

$$= 0.65 \text{ H.P.}$$

UNIT	OUTPUT TORQUE	REDUCTION	OUTPUT SPD	EFFICIENCY
FL'D DRIVE G2 MT2	497 IN-LBS		190 R.P.M.	15.8%
ANGLE GEAR 20:1	10,200 "	40:1	475 "	66.5%
2" ROLLER CHN. DR.	41,200 "	3.16:1	1.5 "	98%

② DOOR SPEED = 2 RPM = 2 X 1.5 X 1.5 = 9.42 FPM



③ AVAILABLE DRIVE WEL TRACTION = 47,200 IN-LBS = 3,500 LBS (SF 2.5)

④ COEF. OF DRIVE WHEEL FRICTION = 3,500 = 0.106

⑤ ROLLER CHAIN TENSION = 41,200 = 3,700 LBS.

⑥ CHAIN SAFETY FACTOR = 54,000 = 14.6


* THE ABOVE COMPUTATIONS ARE BASED ON THE HEAVIER WEST DOOR.

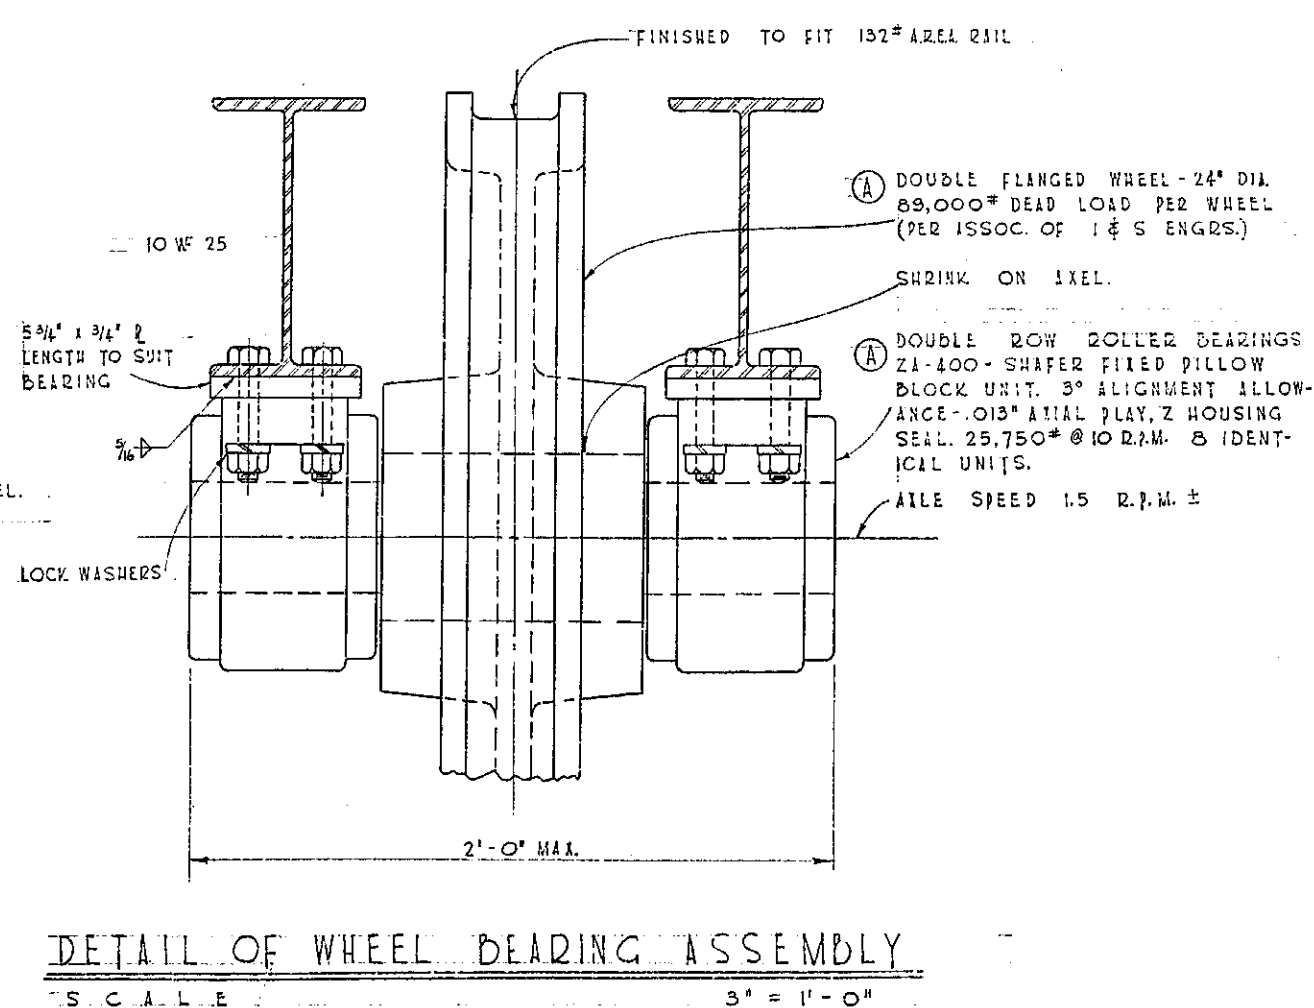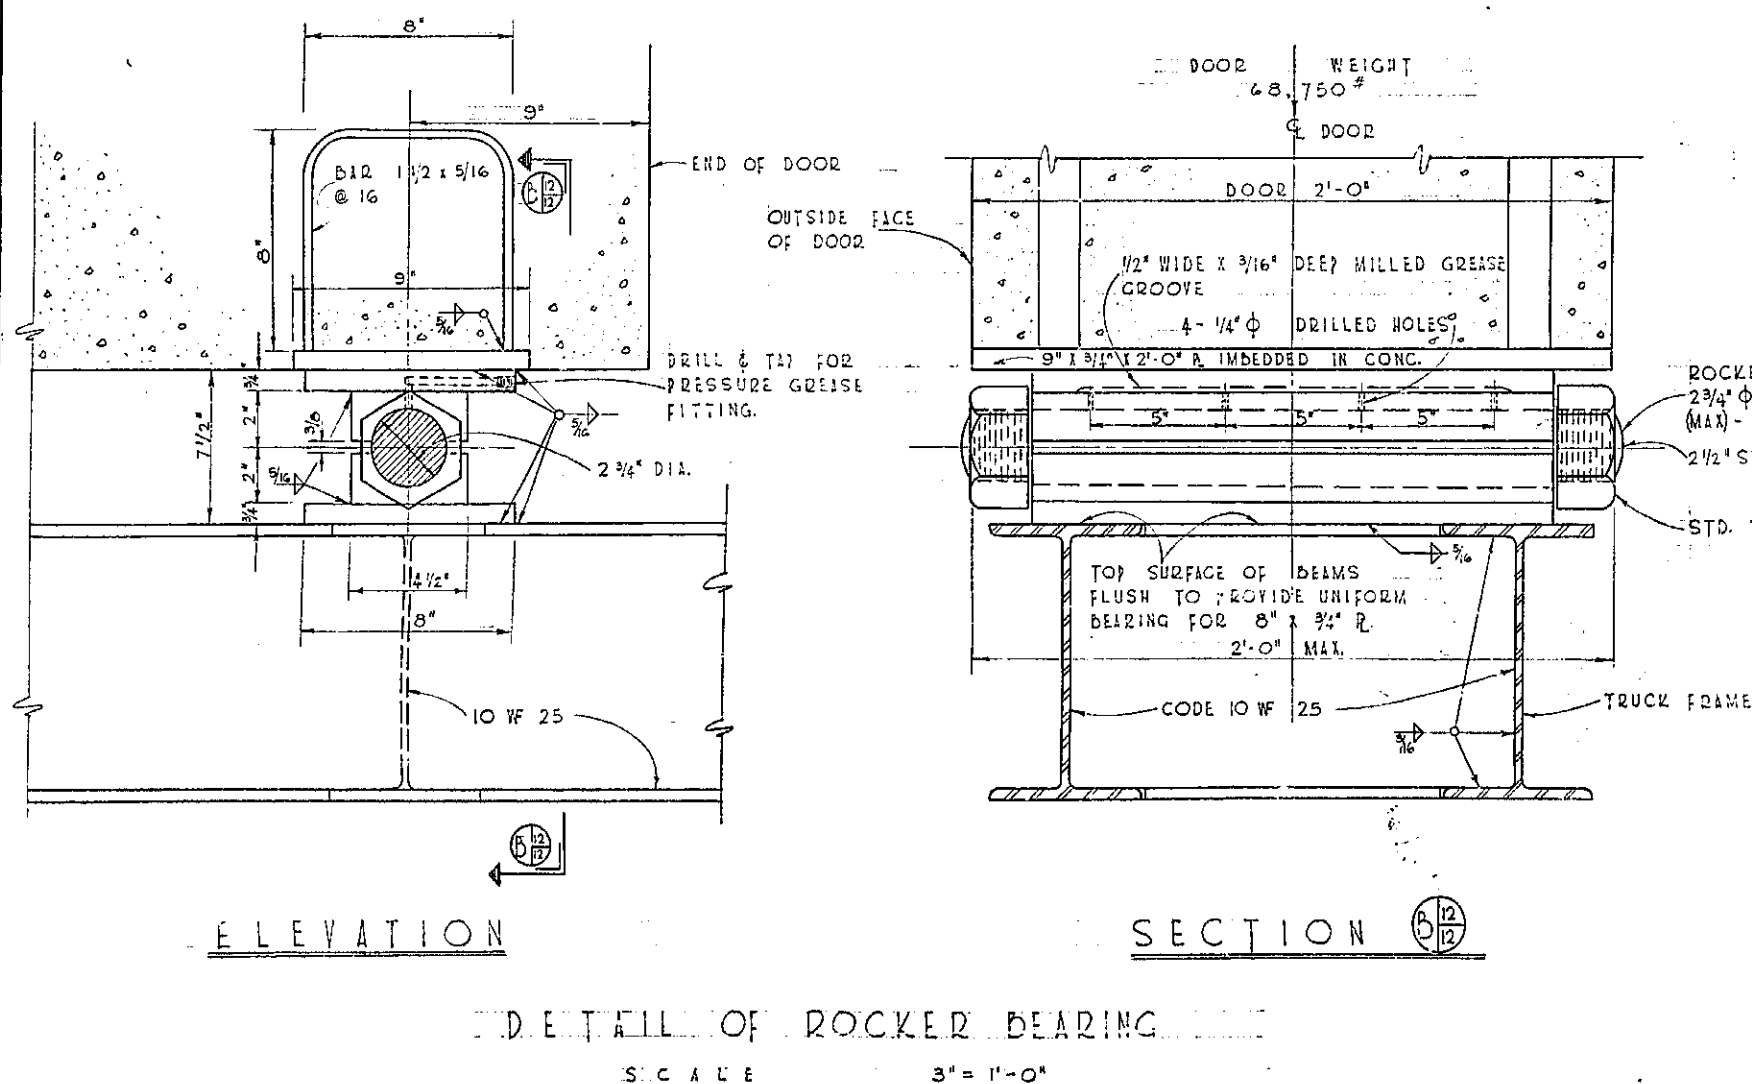

REVISION	DATE	DESCRIPTION	BY
DEPARTMENT OF THE AIR FORCE OGDEN AIR MATERIAL AREA OFFICE OF INSTALLATIONS OGDEN, UTAH			
HILL AIR FORCE BASE			
DESIGNED BY C. O. JONES			
DRAWN BY L. G. SHIELDS			
TRACED BY NOV. 1957			
CHECKED BY			
APPROVED BY DATE			
SUBMITTED			
APPROVAL RECOMMENDED			
APPROVED			
PROJECT NO. HIL-79-8			
DRAWING NUMBER			
58-3837			
SHEET 22 OF 15 SCALE NOTED			

2113-57-M

49-96

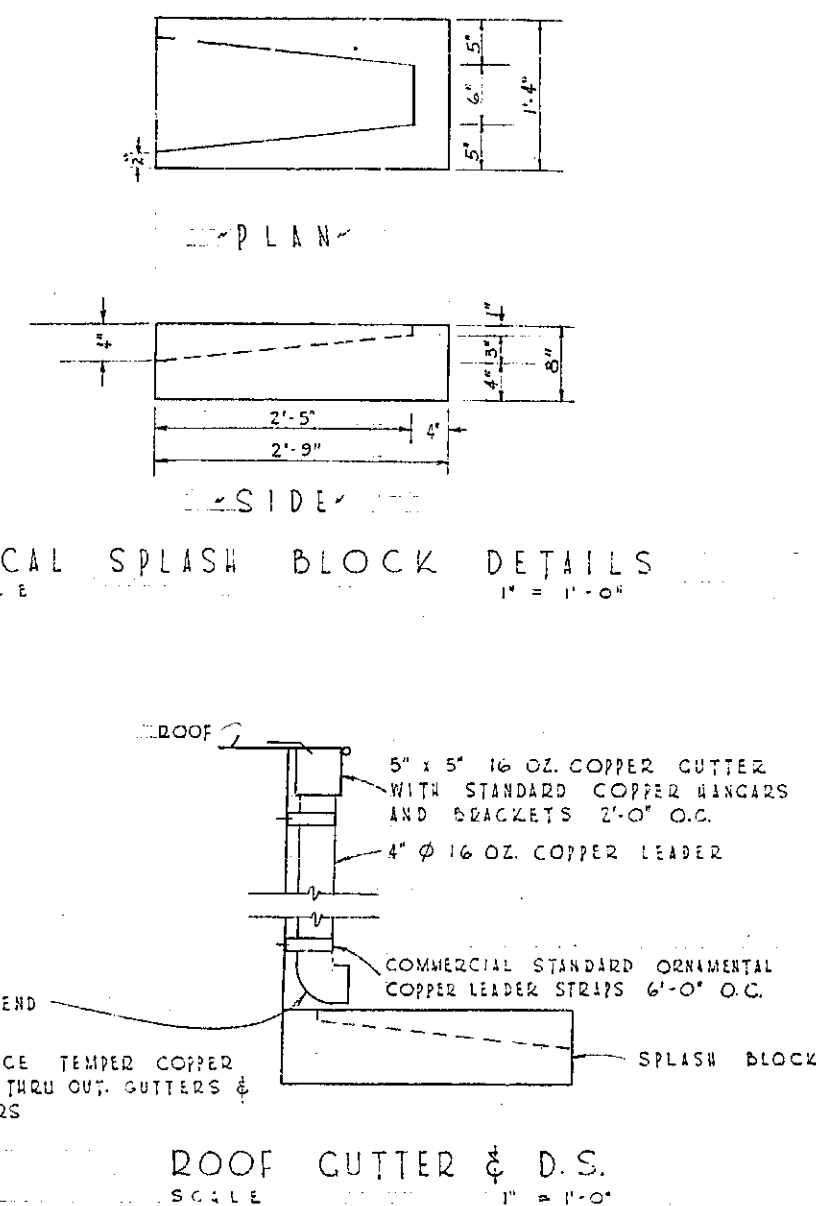

NOTES

1. PROTECT ALL NEW & EXISTING PIPES PASSING THRU NEW FOOTINGS OR FOUNDATION WALLS WITH A MIN. OF 2" OF SEMI RIGID MASTIC ON ALL EDGES. EXCEPT V.C. SEWER PIPE WHICH SHALL BE PROTECTED AS SHOWN ON SHEET (7)

PLUMBING
SCALE

P L A N
1/4" = 1' - 0"


LEGEND

- ☐ 2ND FLOOR DRAIN WITH TRAP
☒ 4TH FLOOR DRAIN WITH TRAP
 --- COLD WATER
 --- HOT WATER
 --- SANITARY SEWER

REVISION	DATE	DESCRIPTION	BY
DEPARTMENT OF THE AIR FORCE ODGEN AIR MATERIAL AREA OFFICE OF INSTALLATIONS ODGEN, UTAH			
HILL AIR FORCE BASE		MODIFICATION OF BUILDING #2113 FOR	
DESIGNED BY <u>C. G. JOHNS</u>		X-RAY FACILITIES	
DRAWN BY <u>L. G. SEIDELS</u>		PLUMBING & ROOF DETAILS	
TRACED BY <u>N. G. T. 1957</u>			
CHECKED BY <u>DATE</u>			
APPROVED BY <u>DATE</u>			
SUBMITTED		APPROVAL RECOMMENDED	
APPROVED		APPROVED	
APP. REVIEWED		DATE	
APPROVED		DATE	
APPROVED		DATE	
PROJECT NO.		DRAWING NUMBER	
SCALE		NOTED	

2113-57-C-A

99-97

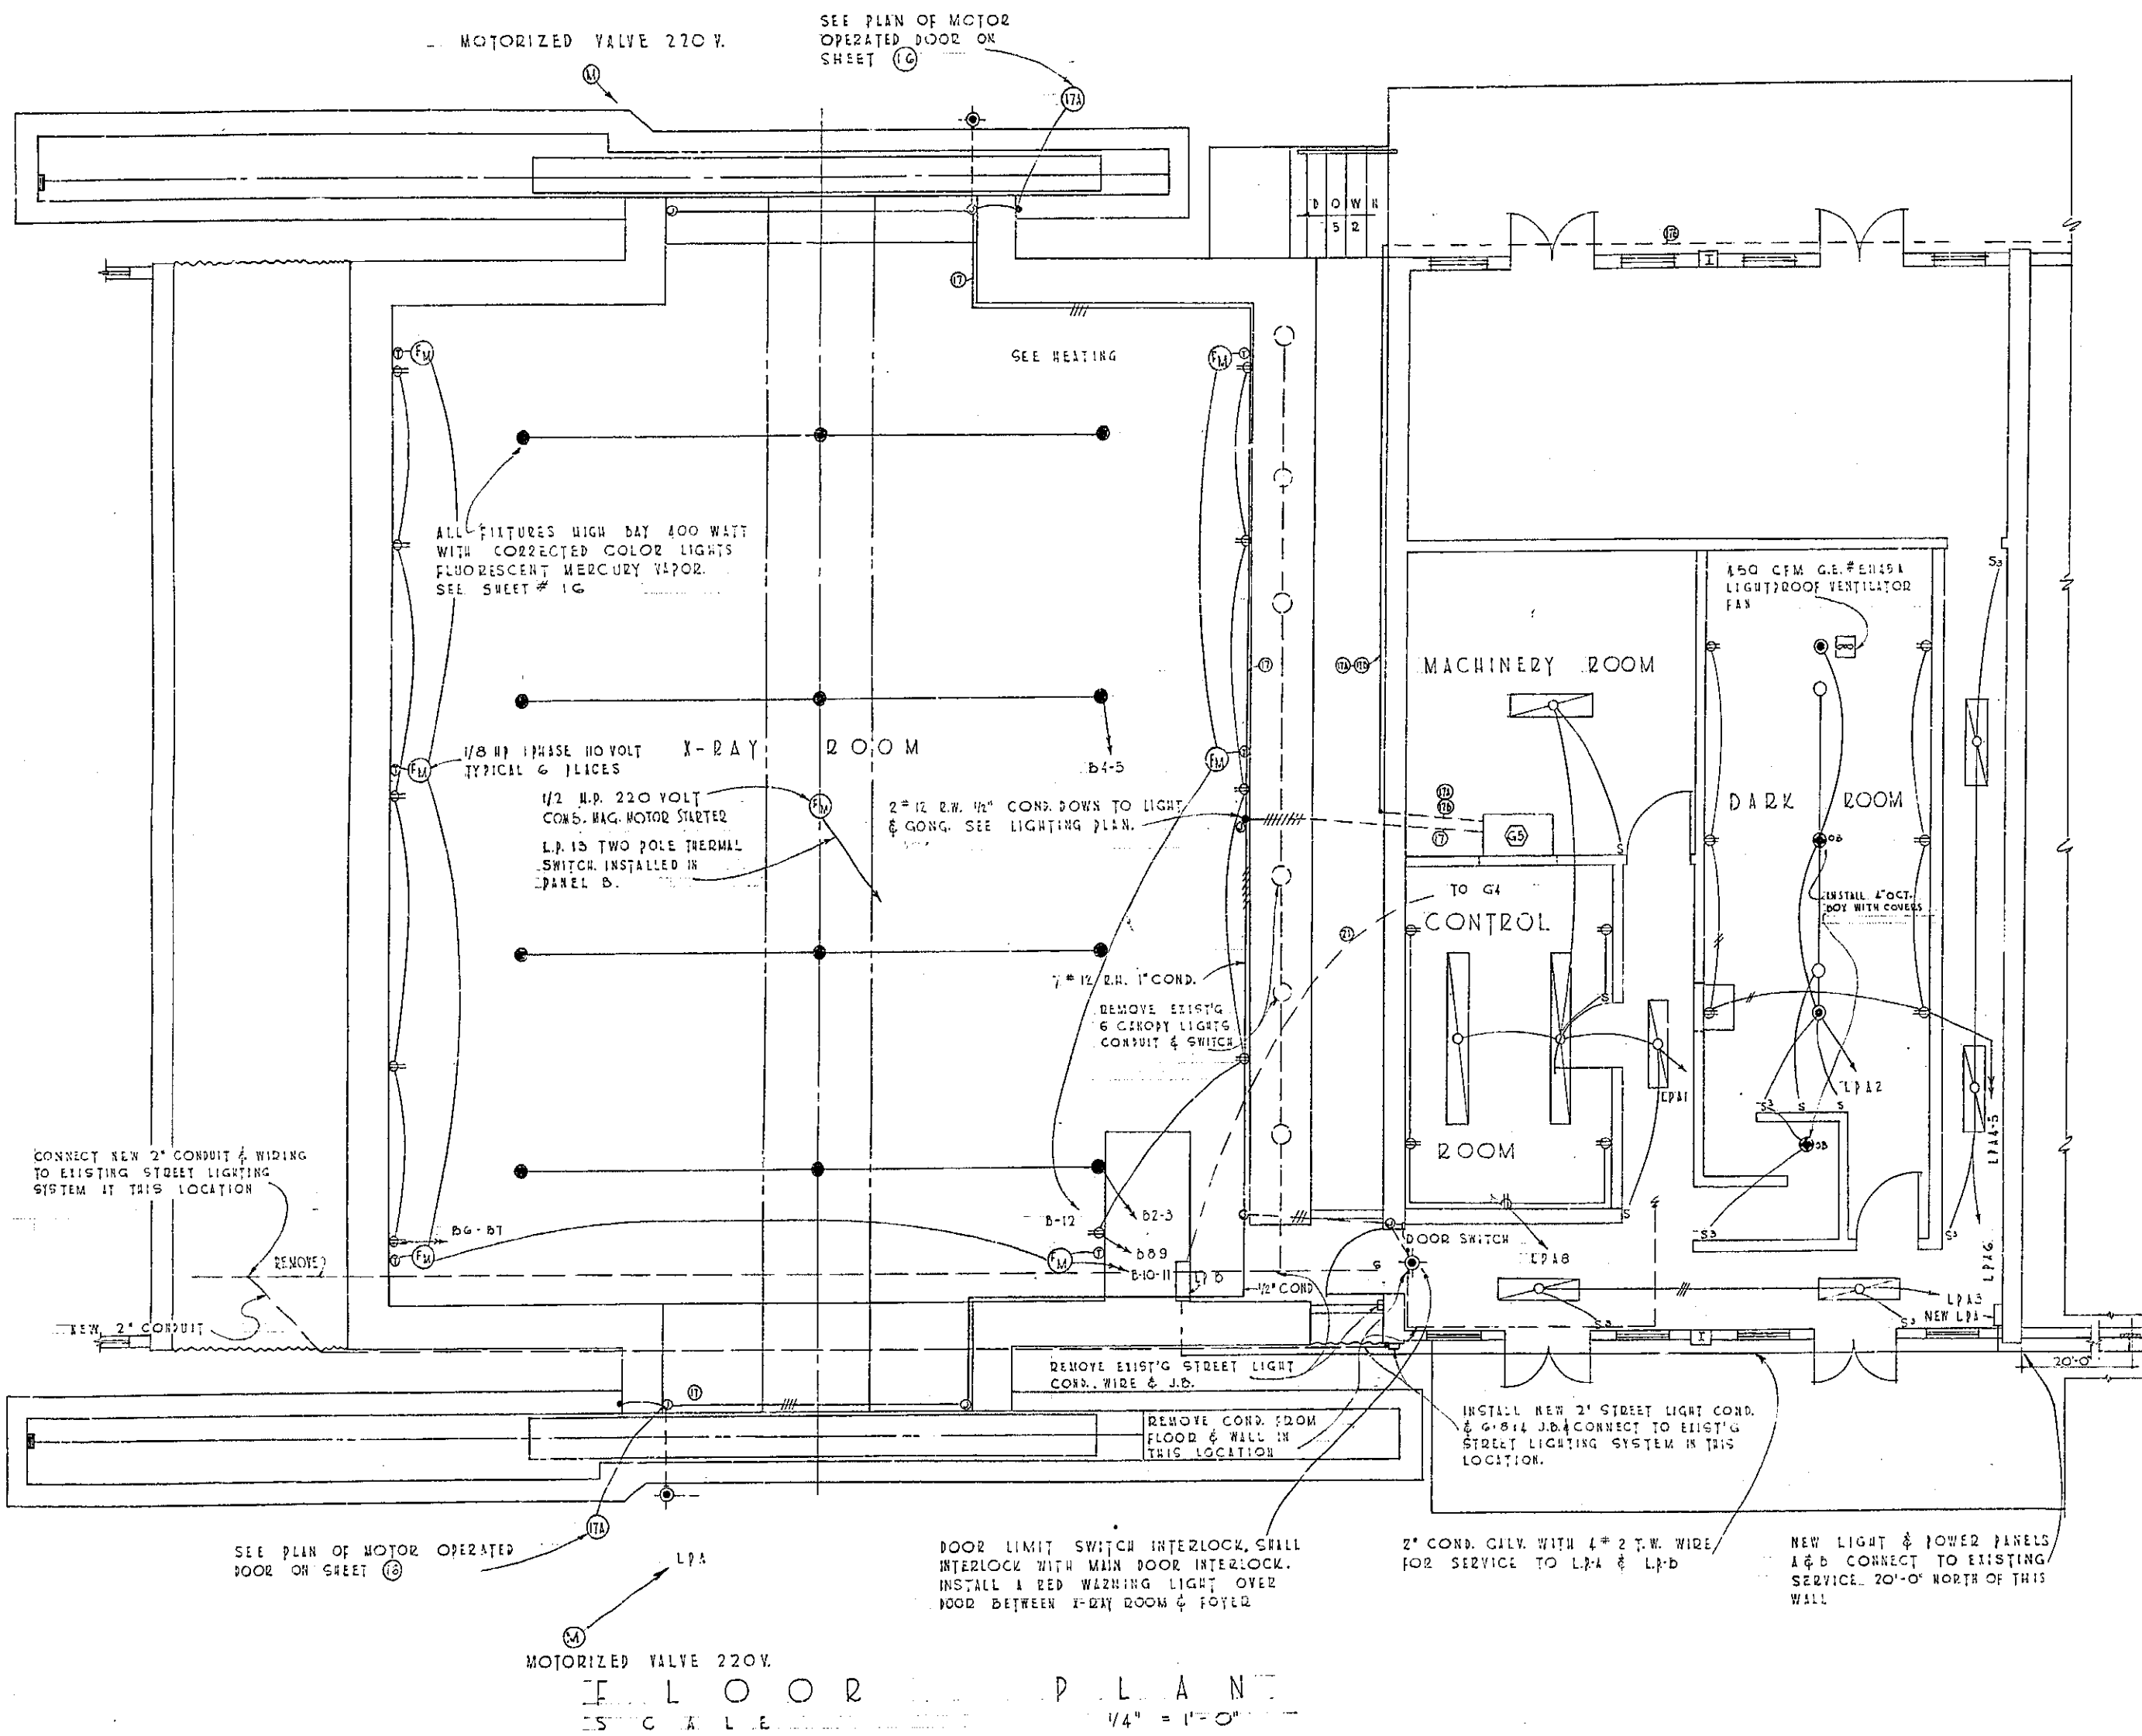

TYPE F.S. FITTING WITH 4*12 TW IN 3/4\" GILV. COND. UP THRU ROOF. SEE POWER PANEL X. X-RAY ROOM DOOR SWITCHES, SEE NOTE 3 SHEET 15.

- ### NOTES
1. ALL OUTLETS TO BE 4 FT. FROM FLOOR.
 2. GROUND ALL OUTLETS WITH GREEN WIRE TO WATER PIPE.
 3. INSTALL GILV. STEEL PLAT COVERS.
 4. G.F.E. = GOVERNMENT FURNISHED EQUIPMENT
 5. G.F.E.I. = GOVERNMENT FURNISHED EQUIPMENT INSTALLED BY GOVERNMENT
 6. NOTES MARKED * PERTAIN TO ALL SHEETS

LEGEND

- 86\" SLIMLINE 73 WATT 3 TUBE # NT 304-S2 SLOTTED WITH TUBET SOCKET.
- FLUORESCENT FIXTURE # NT 216 NB SMOOTH GLASS.
- CONDUIT EXPOSED.
- CONDUIT CONCEALED IN CEILING OR WALL.
- CONDUIT CONCEALED IN FLOOR.
- FIXTURE # 26 9YF 200 WATT LAMP RED GLOBE AND GUARD. (WARNING LIGHT)
- UNIVERSAL # 5262 DUPLEX RECEPTACLE 3 POLE GROUNDING.
- FRACTIONAL HP. HTZ. FAN MOTOR AND SOLENOID OR VALVE.
- THERMOSTAT MERCURY 10 AMP. 110 VOLT
- G.F.E. # 10109C 50 WATT LAMP RED GLOBE.
- FIXTURE 50 9YF 200 WATT LAMP (WHITE)
- PANEL (D) G.E. CAT. 102 W.P. NLAB416AB
- PANEL (A) 16 CIRCUIT PANEL 20 AMP. 1 POLE 120 VOLT 60 AMP. 220 VOLT AND 2-30 AMP. 220 VOLT 1 PHASE. CIRCUIT IN THIS PANEL FOR WATER HTZ. DRYER & PROCESSING TANK. THIS PANEL TO HAVE 1 100 AMP. 3 POLE MAIN (3 PHASE 4 WIRE CIRCUIT)
- FLUORESCENT MERCURY THOR - SEE DETAIL SHEET 16
- 4\" OCTAGON BOX & COVER


NOTE:
1. INSTALL A THERMAL SWITCH FOR MOTOR PROTECTION AT HIGH THERMOSTAT.
2. THERMOSTATS INSTALLED 5'-0\" FROM FLOOR

REVISION	DATE	DESCRIPTION	BY
DEPARTMENT OF THE AIR FORCE ODGEN AIR MATERIAL AREA OFFICE OF INSTALLATIONS			
MODIFICATION OF BUILDING NO. 2113 FOR X-RAY FACILITIES ELECTRICAL LIGHTING			
DESIGNED BY	DATE	APPROVAL RECOMMENDED	
DRAWN BY	DATE	APPROVED	
CHECKED BY	DATE	APPROVED	
PROJECT NO. H1-29-8		DRAWING NUMBER 58-3837	
SHEET 12 OF 15		SCALE NOTED	

2113-57-E


49-48

FURNISH AND INSTALL A 6"x10"x12" BOX SCREW TYPE COVER #16 GAUGE SHEET STEEL FOR BOTH MOTOR AND GENERATOR

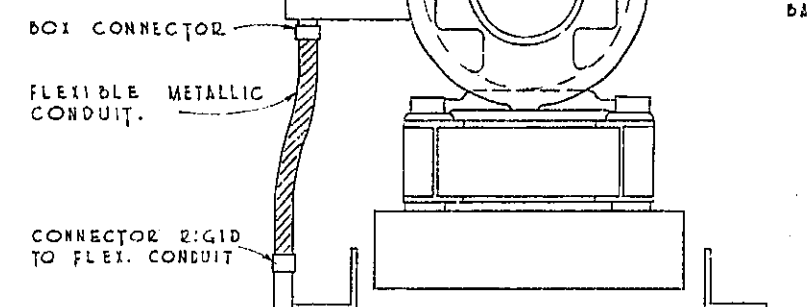


TYPICAL CONNECTION TO MOTOR & GEN.
NO SCALE


FABRICATE FROM 2"x3/16" FLAT STEEL BAR WELD TO ANGLE

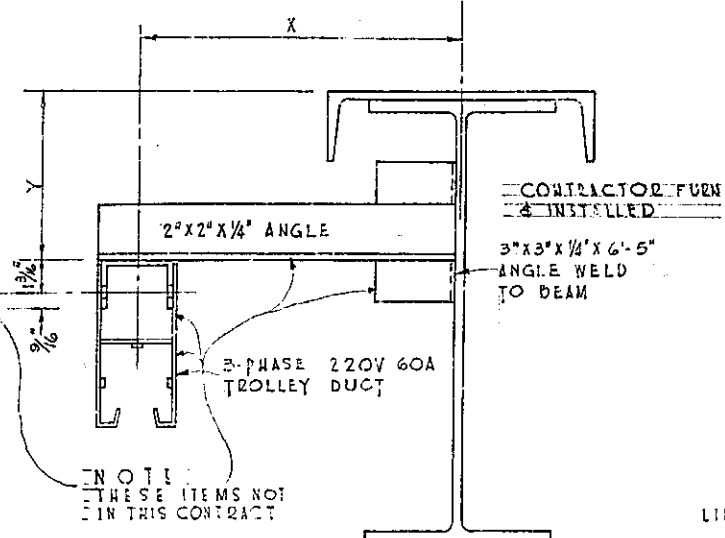

TYPICAL DETAIL MOUNTING OF CRANE TROLLEY BUS
SEE NOTE 2
NO SCALE

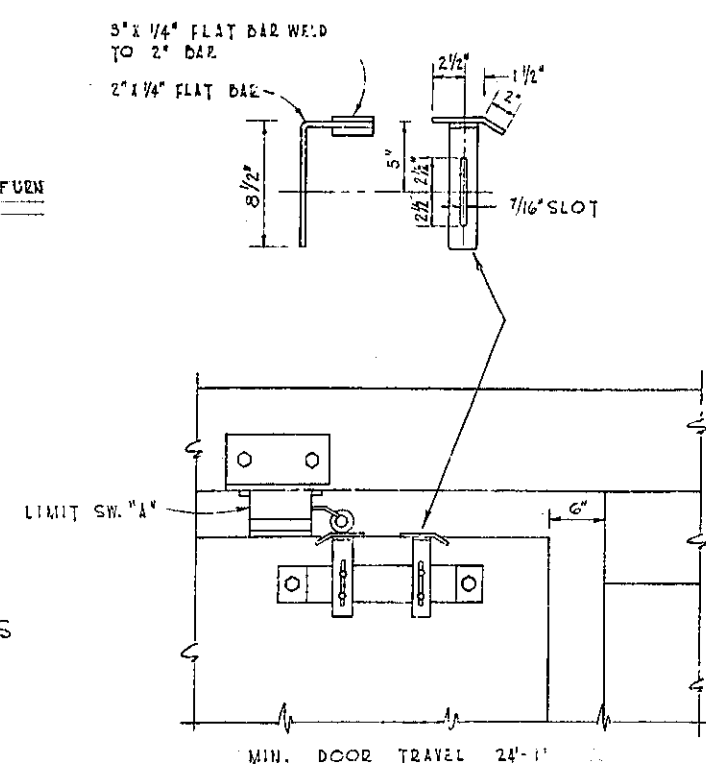


DETAIL A
DOOR FULLY OPEN
SCALE

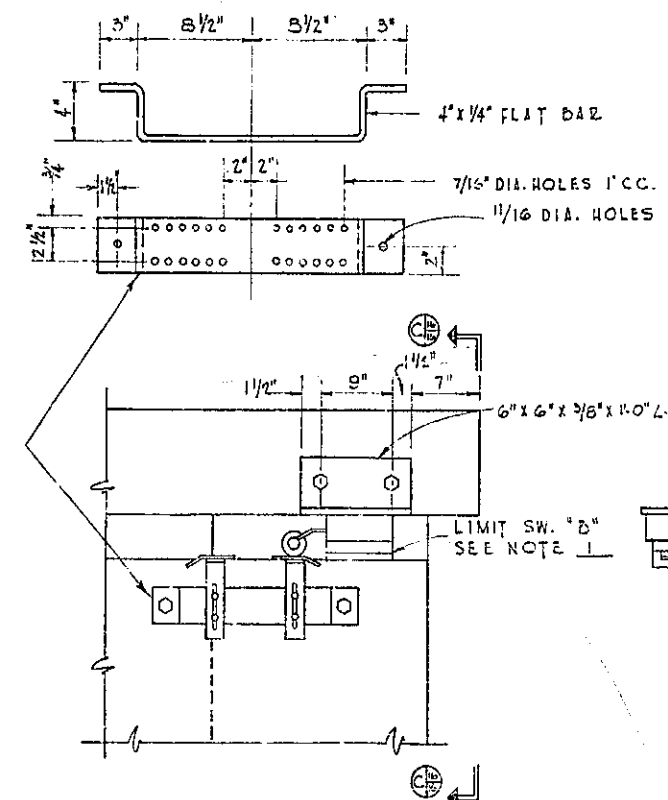


DETAIL B
DOOR FULLY CLOSED
SCALE

LIMIT SW. 'A' AND 'B' SHALL BE LEVER TYPE WITH STEEL ROLLER AND I.M.O. AND I.M.C. CONTACTS RATED TO CARRY 5A CONTINUOUSLY AND INTERRUPT 10A AT 220V. W/ G.E. ENCLOSURE


5/8"x19" GALV. BOLTS CAST IN CONC. OR EXPANSION BOLT ASSEMBLY

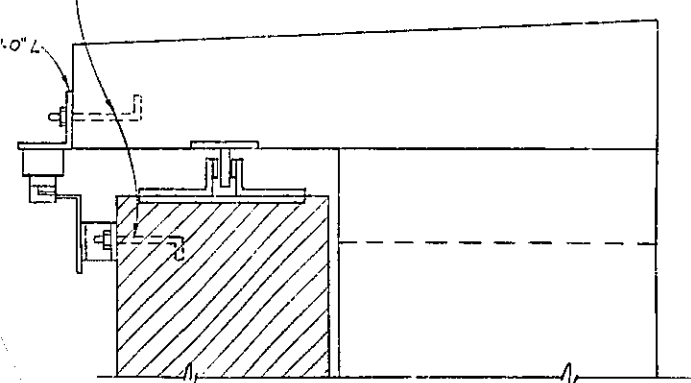


ELEVATION C
1" = 1'-0"

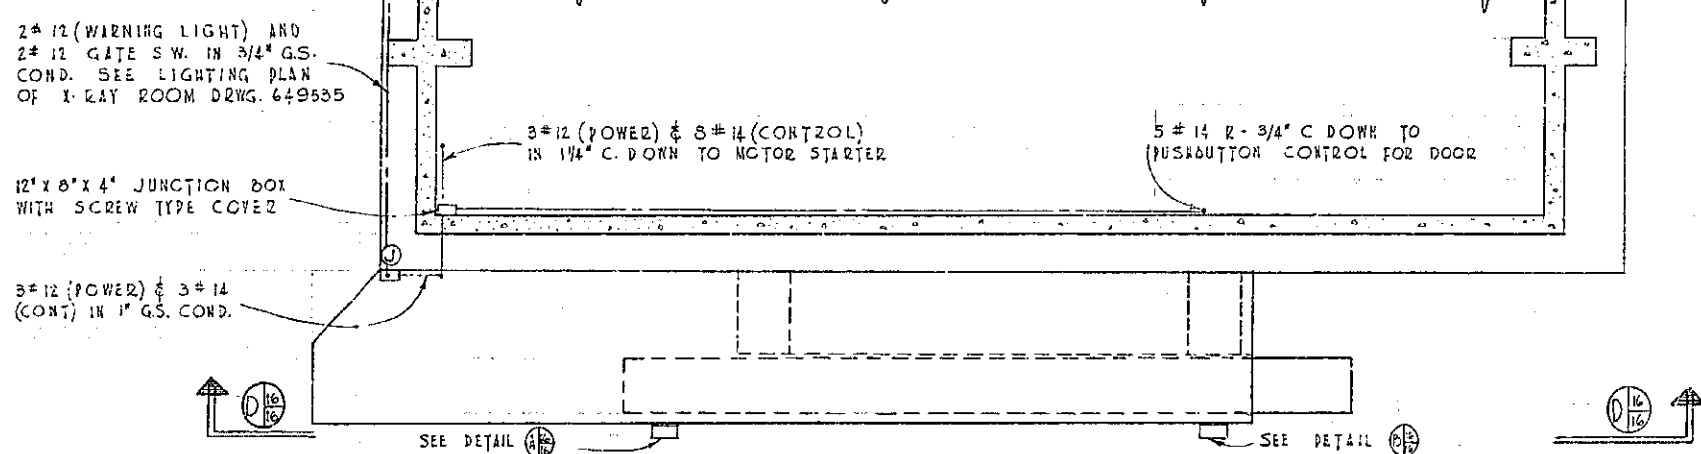


PLAN - MOTOR OPERATED DOOR
SCALE 1/4" = 1'-0"

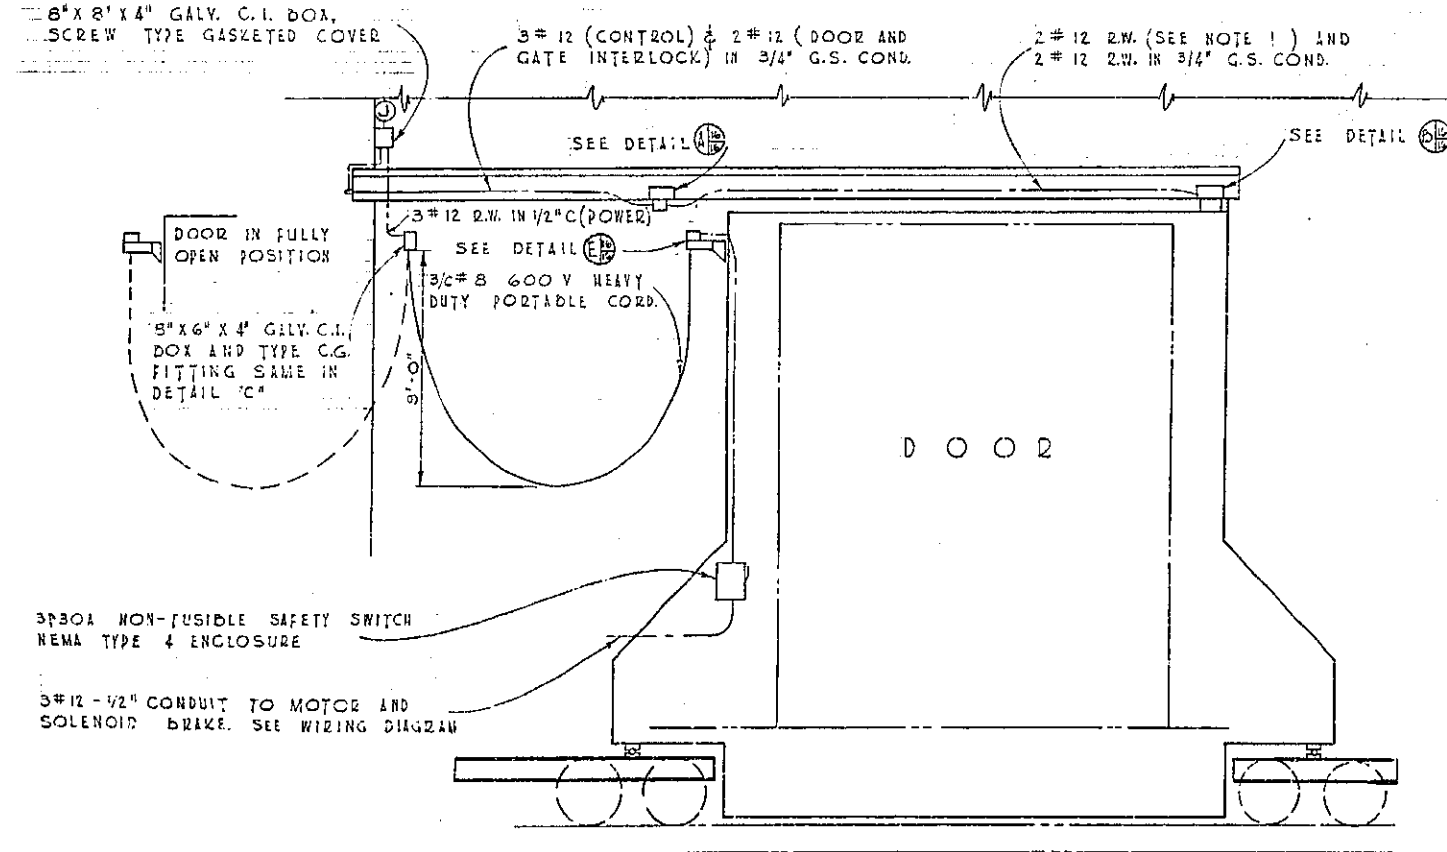


ELEVATION
SCALE 1/4" = 1'-0"

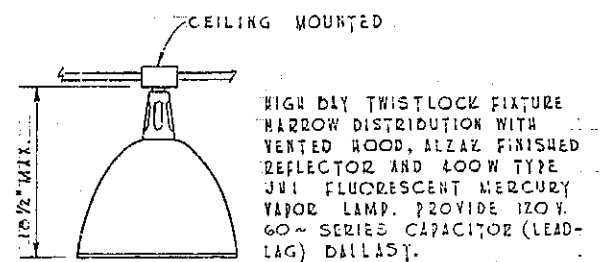


DETAIL - HIGH BAY FIXTURE
NO SCALE

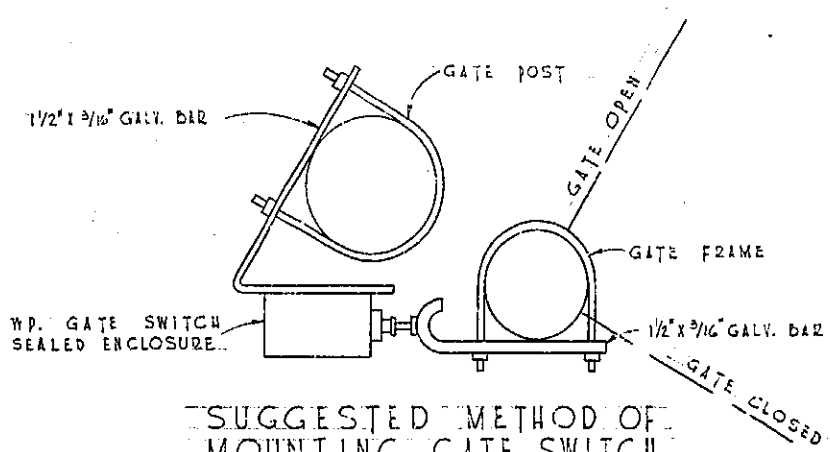

SUGGESTED METHOD OF MOUNTING GATE SWITCH
NO SCALE

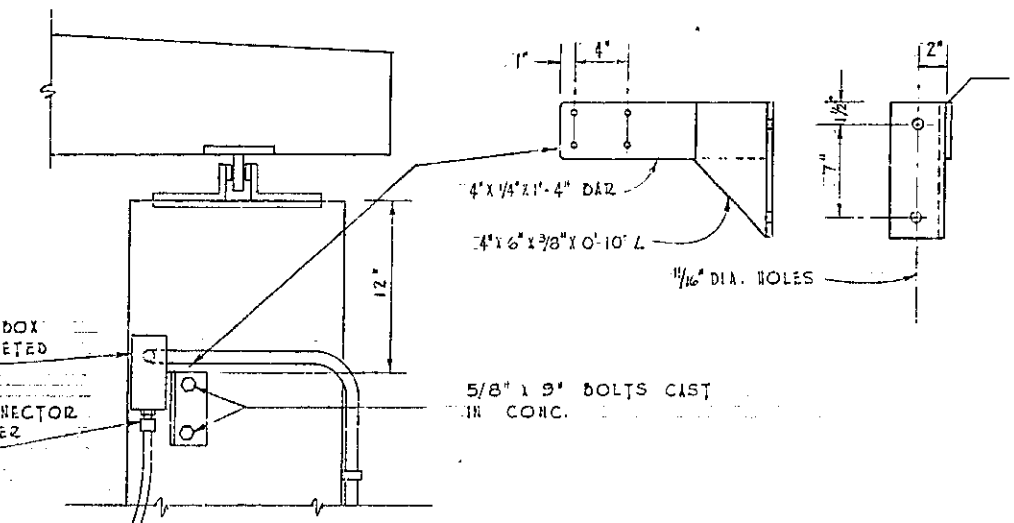

DETAIL D
SCALE 1" = 1'-0"

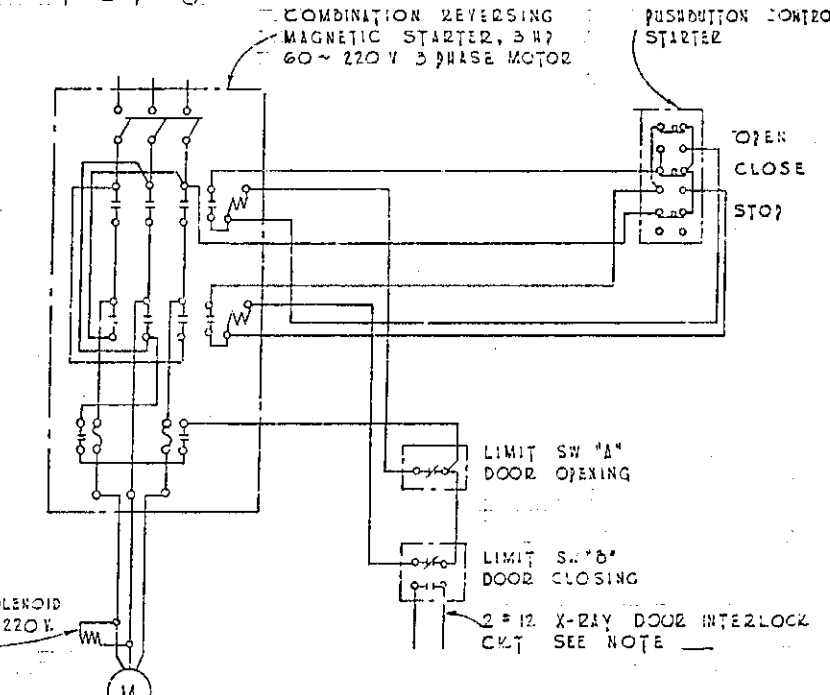

WIRING DIAGRAM - DOOR MOTOR


- NOTES
1. THE DOOR SWITCH AND THE I.M.O. CONTACT OF LIMIT SWITCH 'B' OF DOORS TO 1-RAY ROOM AND THE FOUR GATE SWITCHES I.M.O. CONTACTS, SHALL BE CONNECTED IN SERIES. (EACH SERIES CIRCUIT FROM EACH DOOR SWITCH AND THE SERIES CIRCUIT FROM THE GATE SWITCHES, WILL HAVE INDIVIDUAL CIRCUITS COMING FROM JUNCTION BOX 'A')
 2. ALL EQUIPMENT MUST BE GROUNDED TO WATER PIPE.

REVISION	DATE	DESCRIPTION	BY
DEPARTMENT OF THE AIR FORCE OGDEN AIR MATERIAL AREA OFFICE OF INSTALLATIONS OGDEN, UTAH			
HILL AIR FORCE BASE			
DESIGNED BY: HENRIE			
DRAWN BY: L.C. SHIELDS			
TRACED BY: NOV. '57			
CHECKED BY: DATE			
APPROVED BY: DATE			
SUBMITTED: APPROVAL RECOMMENDED: APPROVED: <i>Robert E. Smith</i>			
DATE: PROJECT NO. 411-29-8			
DATE: DRAWING NUMBER 58-3837			
DATE: SHEET (6) OF 13 SCALE NOTED			


49-35

2113-57-E


234

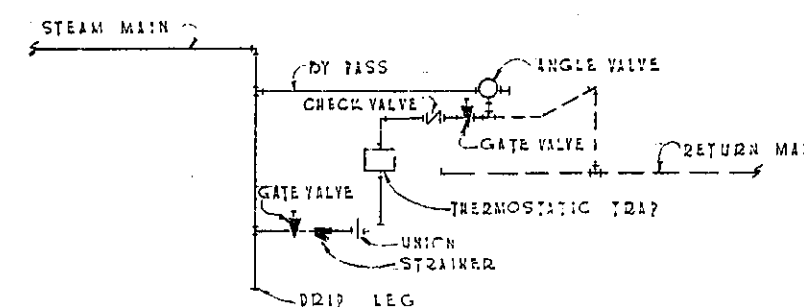

DETAIL (D 17/17) DRIP ON END OF STEAM MAIN
NO SCALE

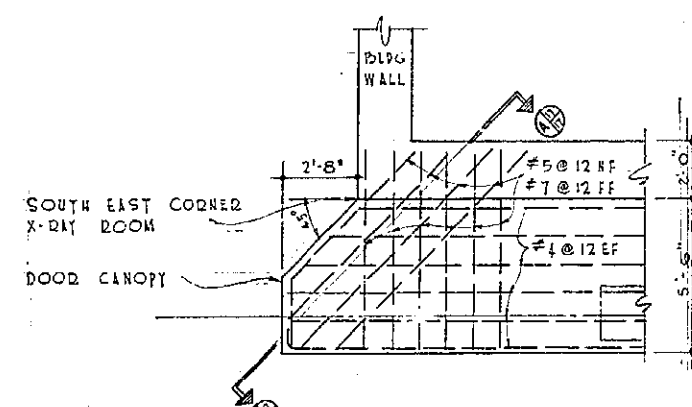

REIN DETAIL S. E. CORNER DOOR CANOPY
SCALE 1/4" = 1'-0"

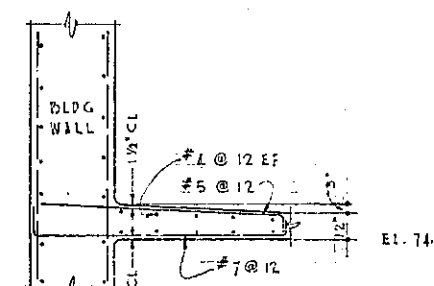


SECTION 
SCALE 1/4" = 1'-0"

PLAN OF X-RAY GATE SWITCHES

POWER PANEL X													
3P200A MAIN BREAKER 440VOLT 3 PHASE 3 WIRE * SURFACE MOUNTED													
FEED TO	CONDUIT		WIRE SIZE	BRANCH		DRAINER		WIRE SIZE	CONDUIT		FEED TO		
	SIZE	NR		AMP	POLE	NR	AMP		NR	SIZE		SIZE	
EQUIP. NR G3	1 1/2"	4	3 # 2	90	3	1	2	3	90	3 # 2	10	1 1/2"	CRAWL TROLLY
EQUIP. NR G4	1 1/4"	7	3 # 3	70	3	3	4	3	20	3 # 12	16	3/4"	DOOR MOTOR
SPARE				20	3	5	6	3	20				SPARE
SPARE				20	3	7	8	3	20				SPARE
LIGHTING PANEL "A"													
3P100A MAIN BREAKER 120-208-VOLT 3-PHASE 4-WIRE SURFACE MOUNTED													
EXHIBIT FAN	1/2"	11	3 # 12	20	1	1	2	1	20	2 # 12	12	1/2"	BARBROOM LIGHTS
SPARE	1/2"	13		20	1	3	4	1	20	2 # 12	14	1/2"	BARBROOM OUTLET
BARBROOM OUTLETS	1/2"	A5	2 # 12	20	1	5	6	1	20	2 # 12	16	1/2"	HALL LIGHTS
CONTROL RM. LTS.	1/2"	A7	2 # 12	20	1	7	8	1	20	2 # 12	18	1/2"	CONTROL RM. OUTLET
MACHINE RM. LTS.	1/2"	A9	2 # 12	20	1	9	10	1	20	2 # 12	110	1/2"	MACHINE RM. OUTLET
TO PANEL PXX	1"	A12	2 # 12	25	1	12	13	1	20	2 # 12	113	1"	TO PANEL PXX
TO PANEL PXX	1"	A14	2 # 12	20	1	14	15	1	20	2 # 12	115	1"	TO PANEL PXX
EQUIP.	1"	A16	2 # 10	30	1	16	17	1	30	2 # 12	117	1"	EQUIP.
SPARE			3 # 8	60	1	18	19	1	30				SPARE
SPARE				20	1	20	21	1	20				SPARE
LIGHTING PANEL "B"													
50A MAINS 120-208 VOLTS 3-PHASE 4-WIRE SURFACE MOUNTED													
NTR. FAN MOTORS	1/2"	B1	2 # 12	20	1	1	2	1	20	3 # 12	B2	1/2"	LTS. X-RAY RM.
LIGHTS	1/2"	B5	2 # 12	20	1	3	4	1	20				LTS. X-RAY RM.
LIGHTS	1/2"	B5	2 # 12	20	1	5	6	1	20	2 # 12	B6	1/2"	LTS. X-RAY RM.
OUTLETS		B7		20	1	7	8	1	20		B6		OUTLETS
OUTLETS		B9		20	1	9	10	1	20		B8		OUTLETS
HEATING		B11		20	1	11	12	1	20		B10		HEATING
VENT FAN		B13		20	3	13	14	1	20		B12		HEATING
SPARE		B15		20	1	15	16	1	20		B14		SPARE



* PROVIDE A GROUND BUS IN PP-X

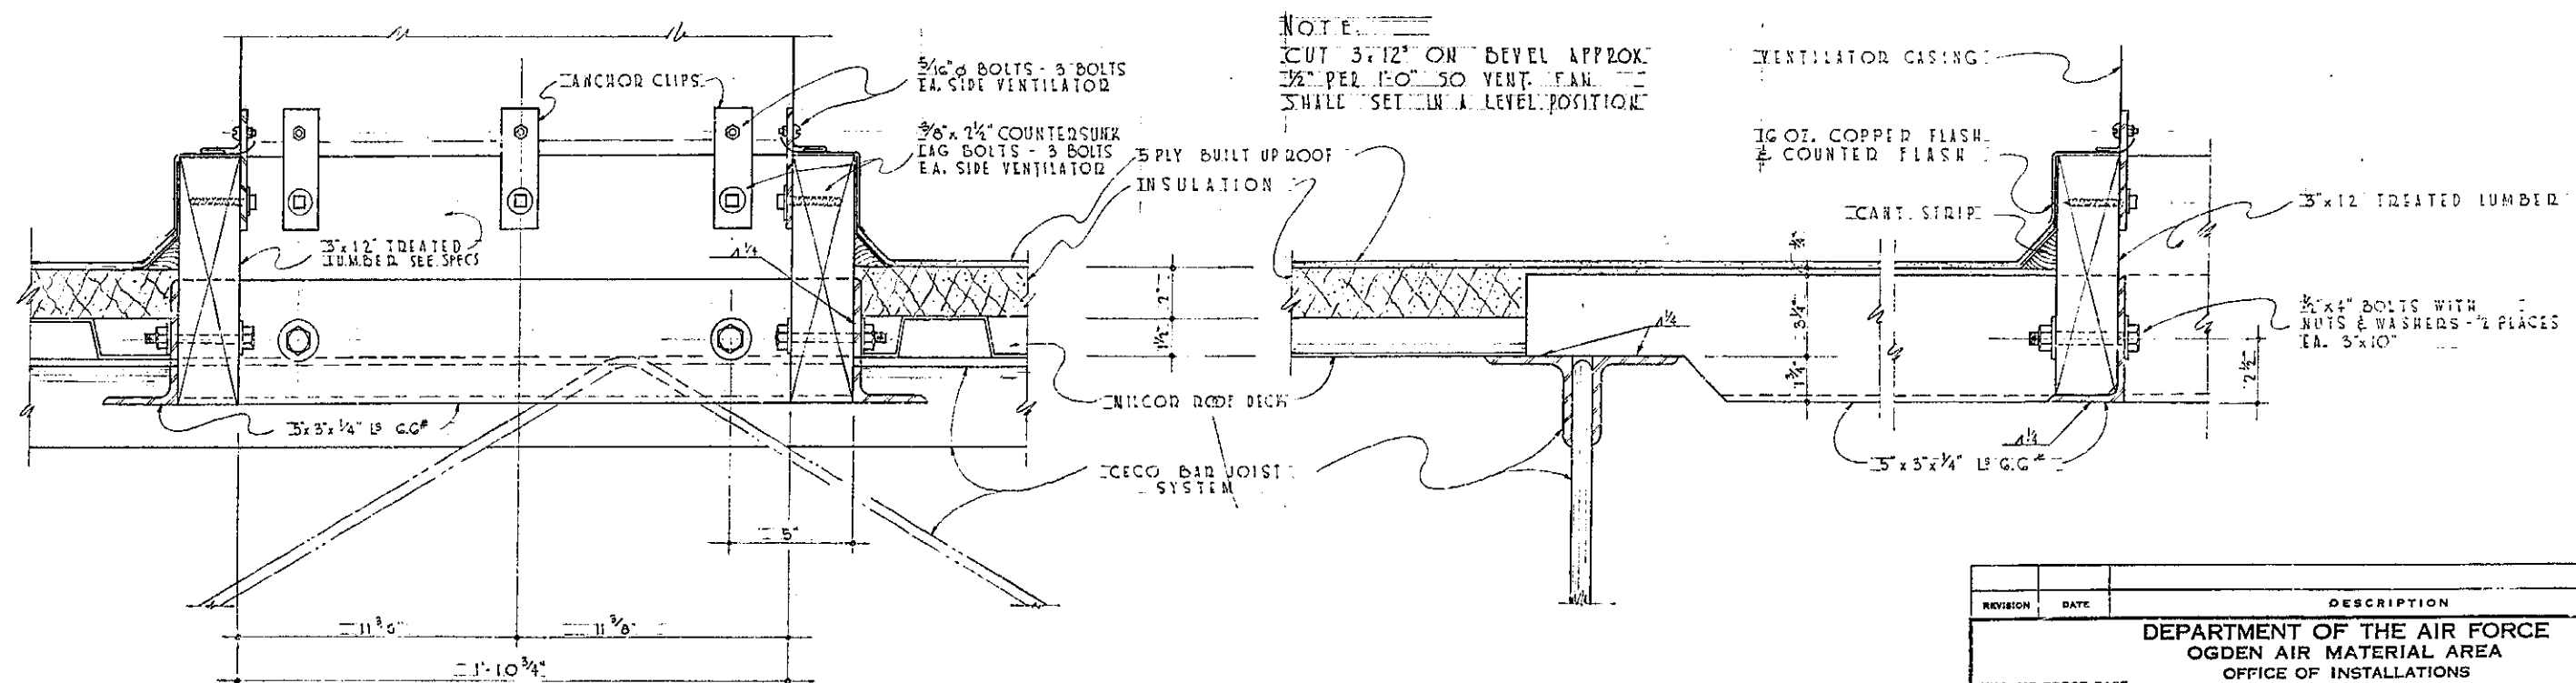SECTION
SCALESECTION
SCALE

REVISION	DATE	DESCRIPTION
DEPARTMENT OF THE AIR FORCE ODGEN AIR MATERIAL AREA OFFICE OF INSTALLATIONS		
MIL AIR FORCE BASE		ODGEN, UT
DESIGNED BY G.G. JONES	MODIFICATION OF BUILDING #2113 FOR X-RAY FACILITIES ELECT. DETAILS GATE SWITCHES & MISC.	
DRAWN BY SUTLEY MCVAY		
14 DEC. 1957		
TRACED BY		
CHECKED BY	DATE	
APPROVED BY	DATE	
SUBMITTED		
APPROVAL RECOMMENDED		APPROVED
PROJECT NO. 5 MIL 28-8		
DRAWING NUMBER		
58-3637		
SHEET (1) OF 18		SCALE N O T E

2113-57-E

49-50

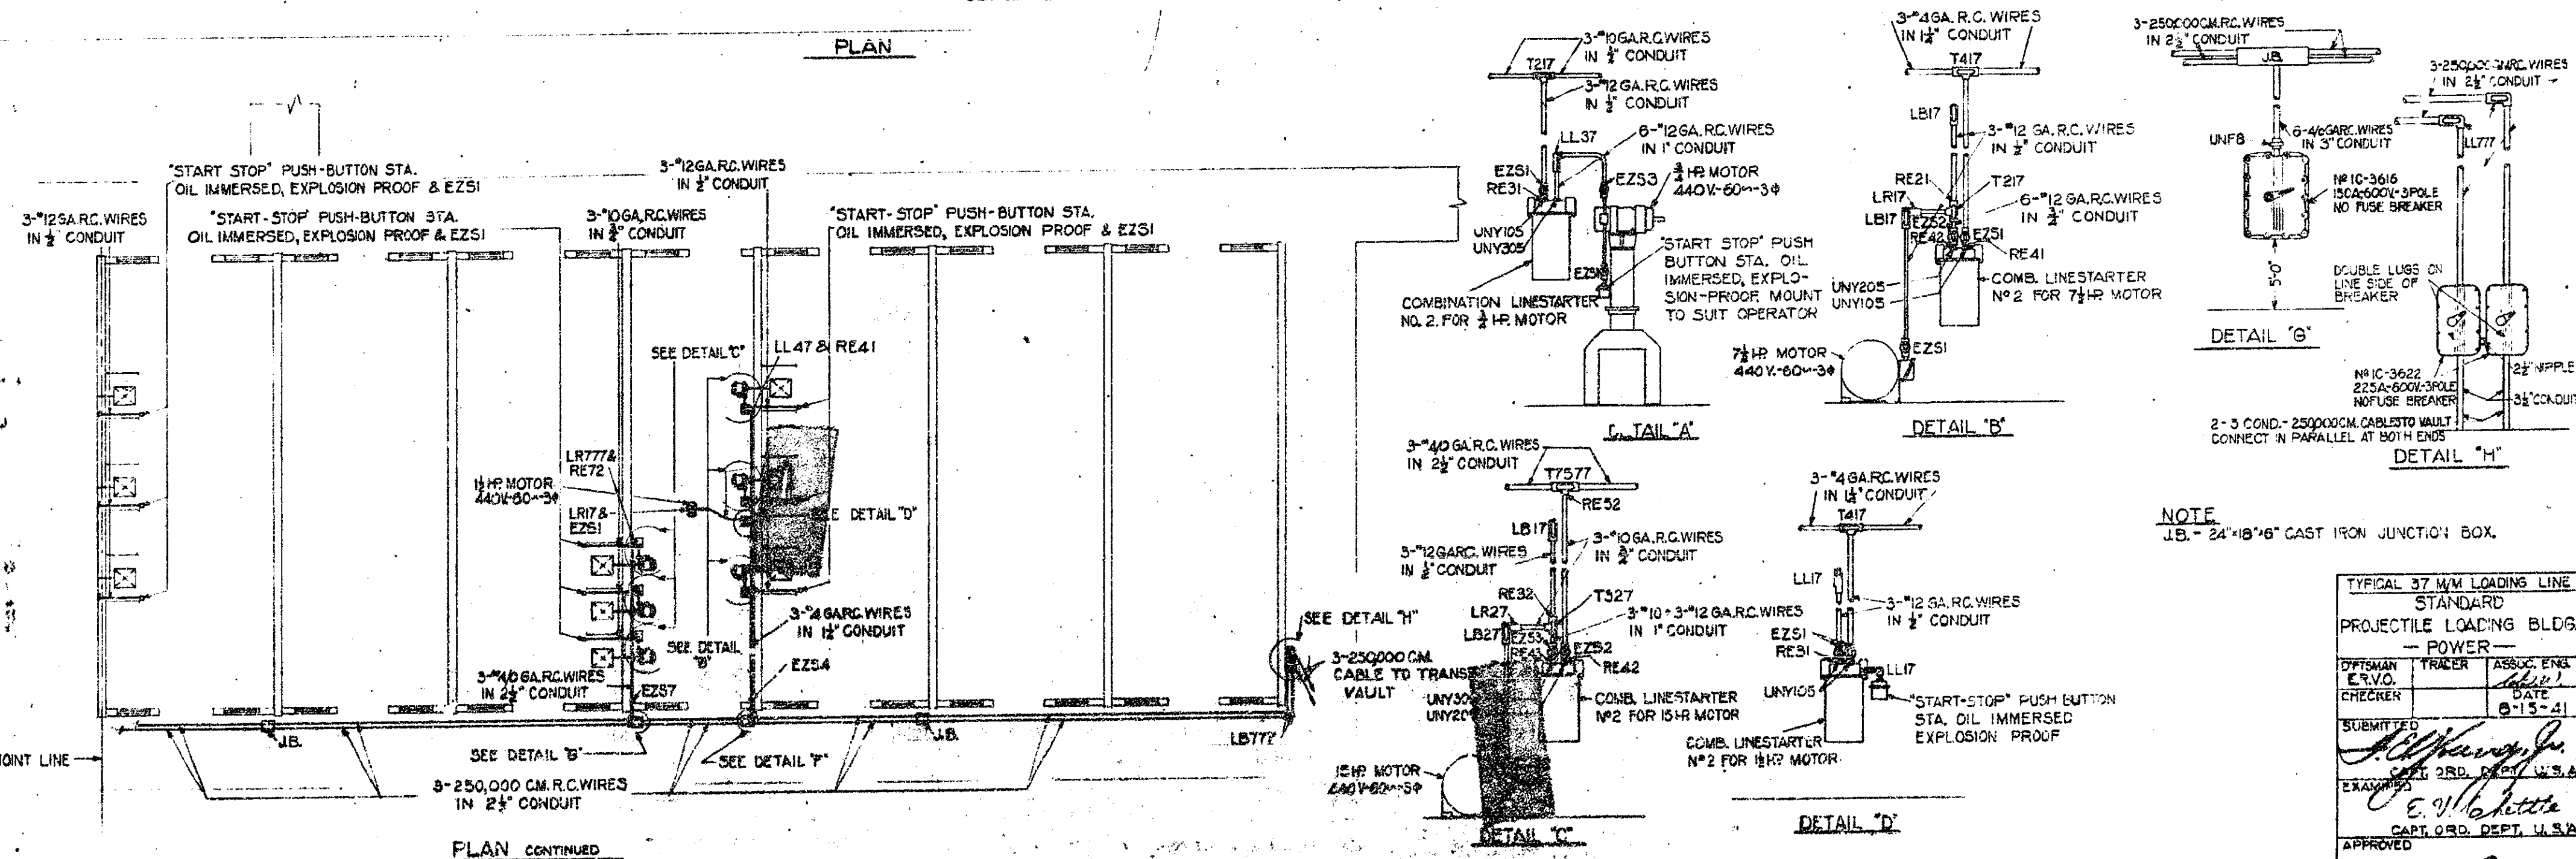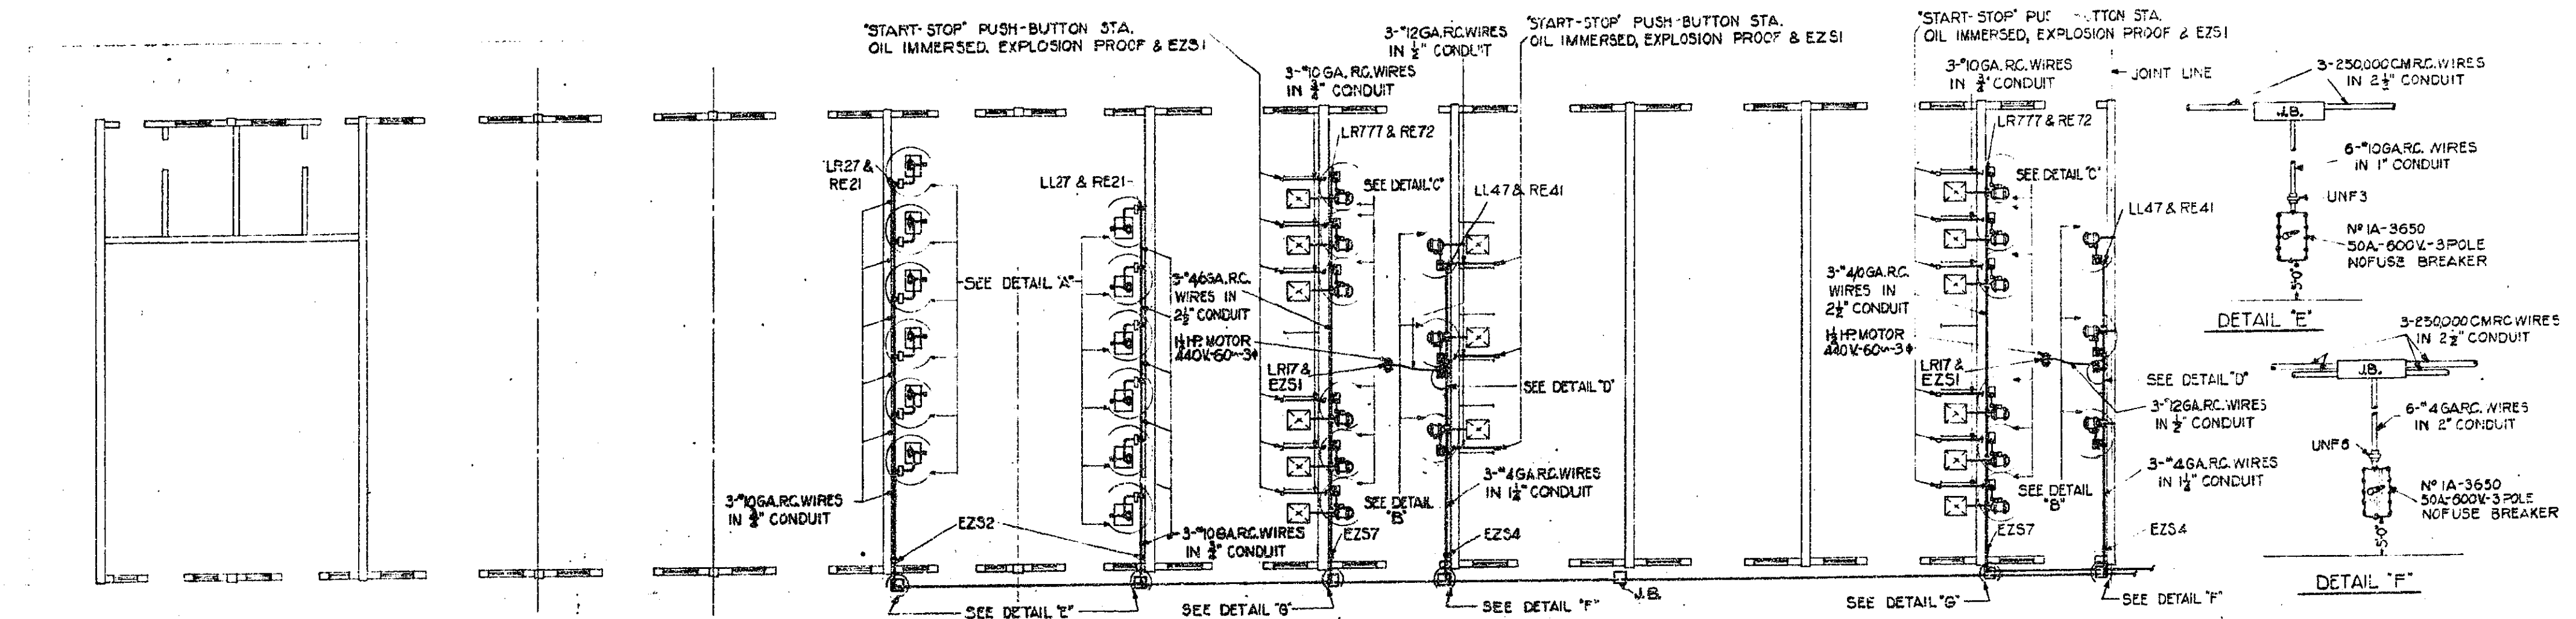

NOTE
J.B. - 24" x 18" x 6" CAST IRON JUNCTION BOX.

TYPICAL 37 MM LOADING LINE STANDARD PROJECTILE LOADING BLDG. - POWER -		
OFFICER E.V.O.	TRACER	ASSOC. ENG.
CHECKER		DATE
SUBMITTED E. J. Little CAPT. ORD. DEPT. U.S.A.		
APPROVED J. W. Little LT. COL. ORD. DEPT. U.S.A.		
OSDEN ORDNANCE DEPOT		

SCALE 1/4" = 1'-0"
11-D-52

