




KEYPLAN


AREA 'A'

AREA 'B'

AREA 'C'

Naval Facilities Engineering Command Southern Division Charleston, South Carolina		SHAW AIR FORCE BASE		SOUTH CAROLINA		DRAWING REVISIONS		FAN SYSTEMS CORPORATION 1347 Painters Ave., Suite 202 Winter Park, Florida 32789 Tel. 407-240-7337 Fax 407-240-7337			
		DEPLOYMENT		PROCESSING CENTER		Rev.	Description			Prep By	Date
		COMPOSITE FLOOR PLAN			AS-BUILT DATE					8/14/07	
APPROVED		DATE	EFD FOR COMMANDER, NAVFAC		DSSN DRZ OR		SUPV CEN ENGR		CSS CHK MFJ		
					SUBMITTED BY (FIRM MAJOR-TITLE):		TECHNICAL BRANCH		PRINCIPAL -- / -- / --		
					DATE						

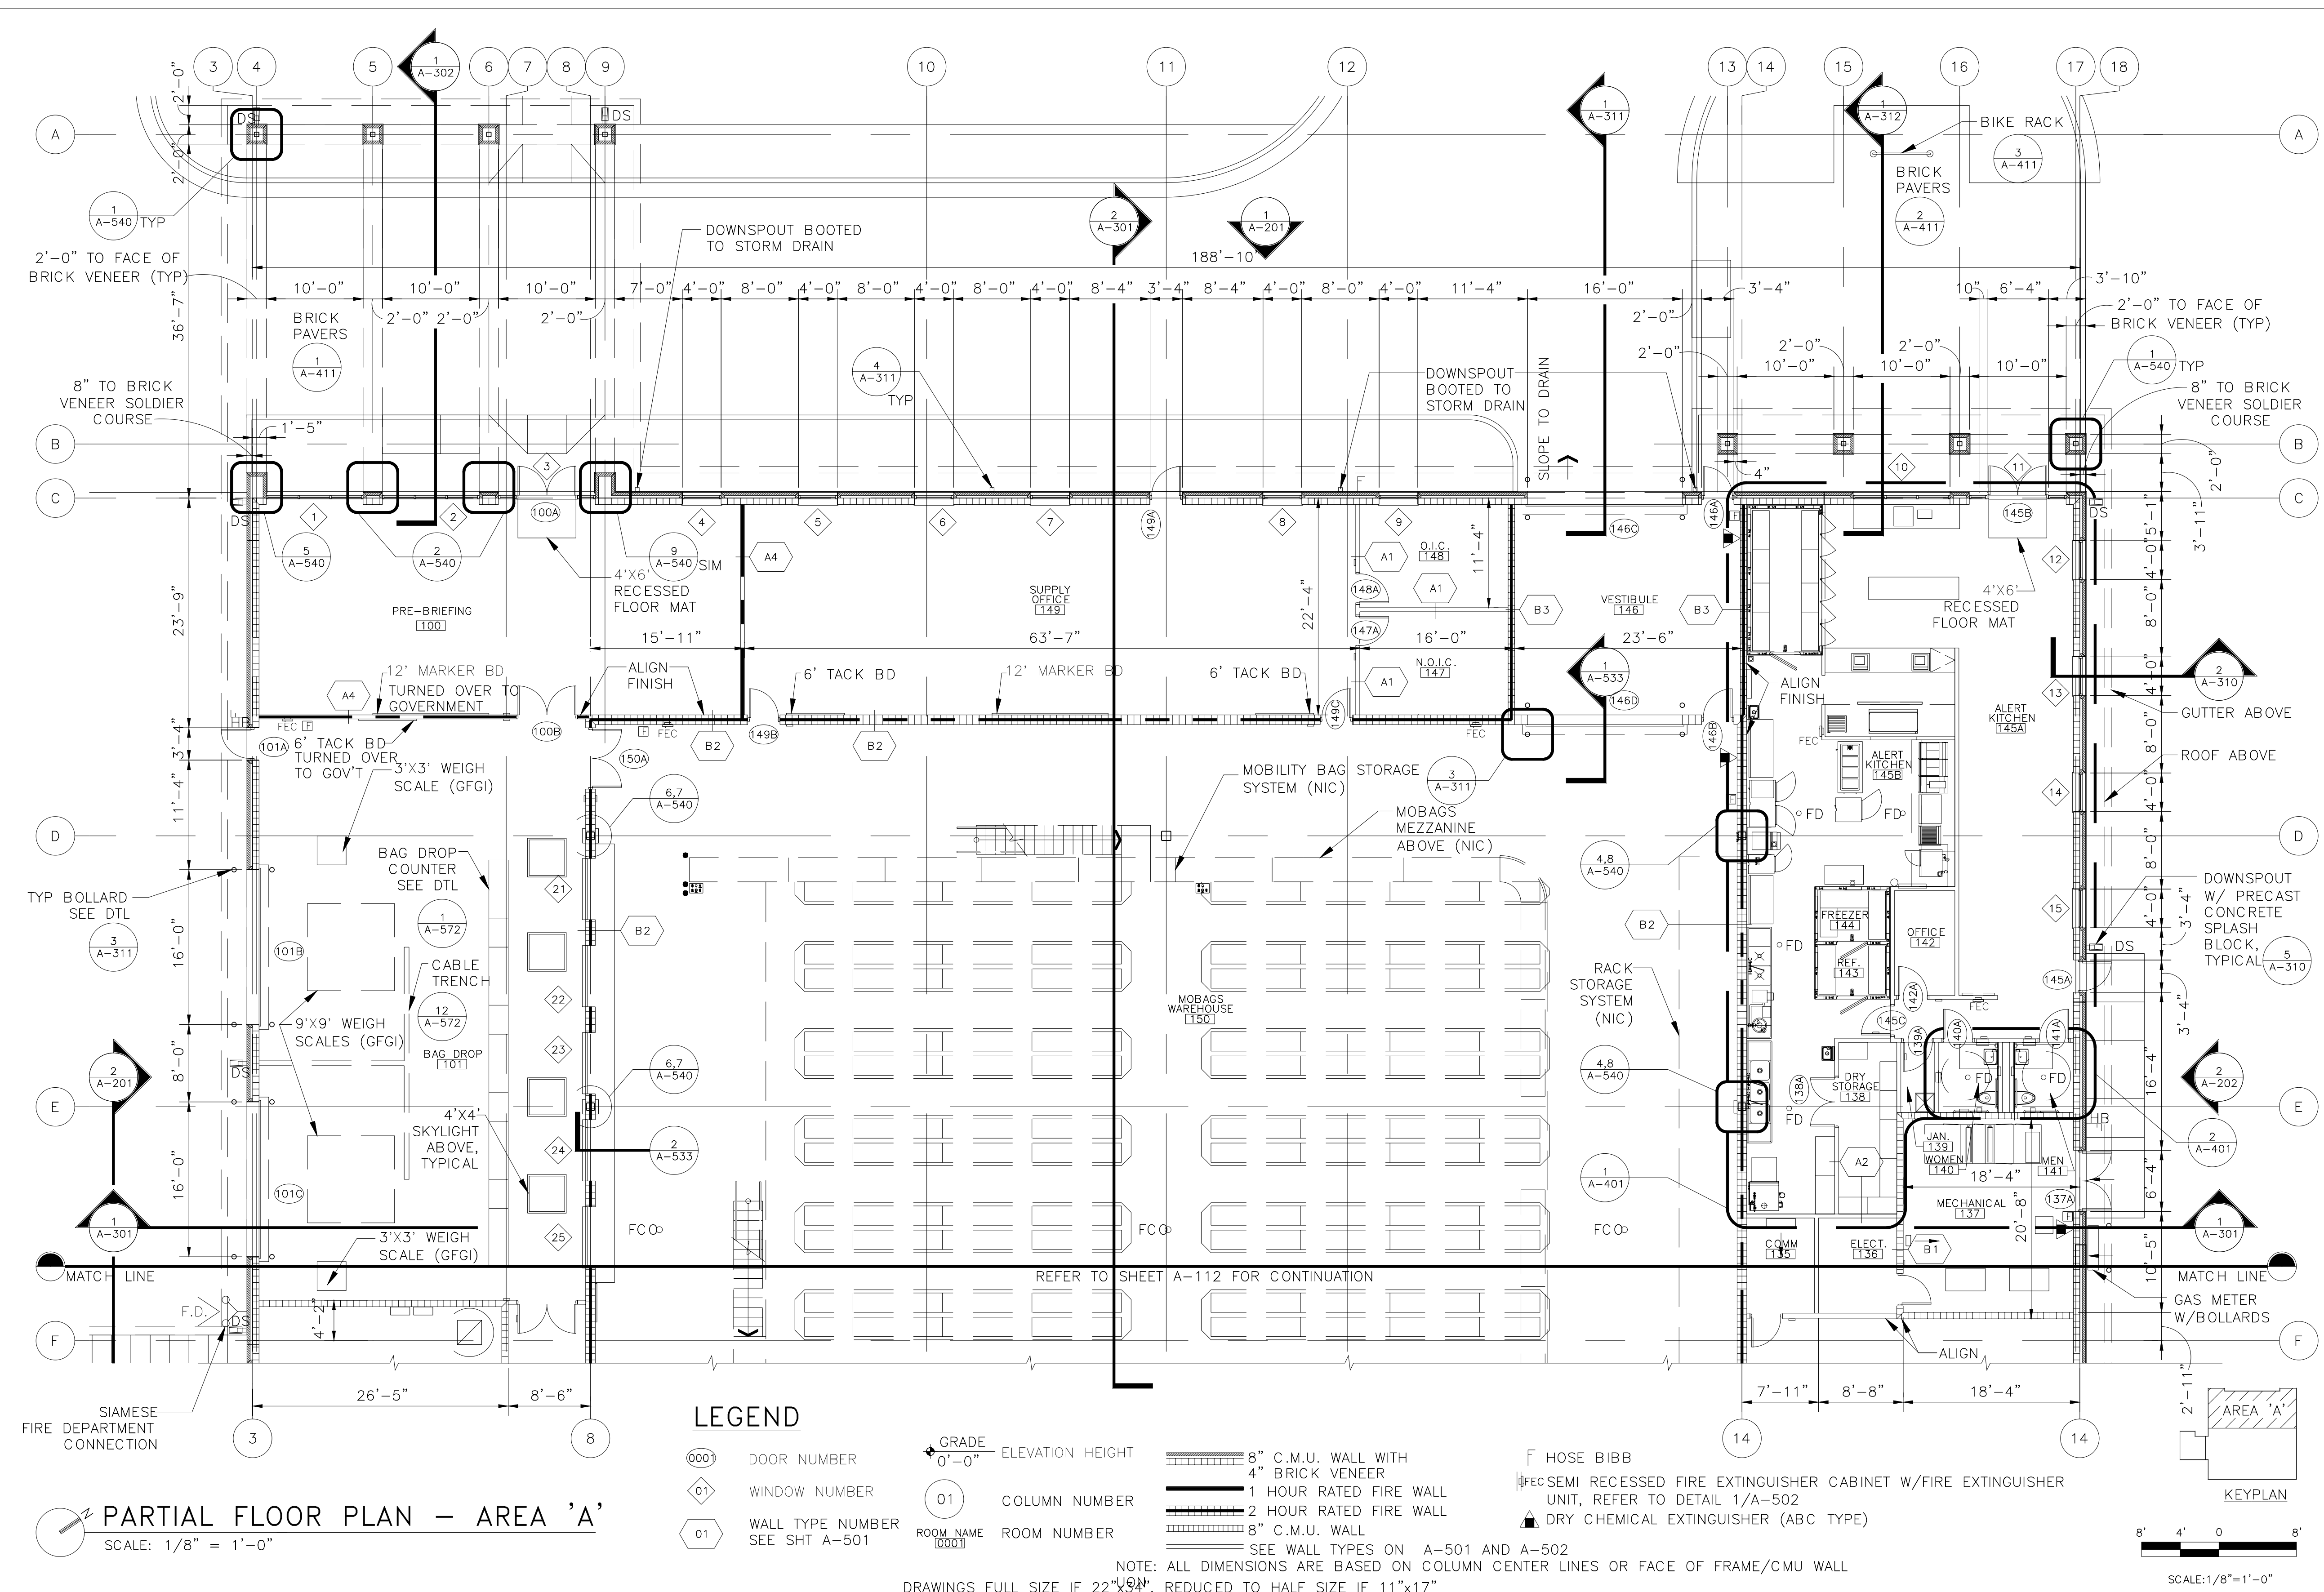

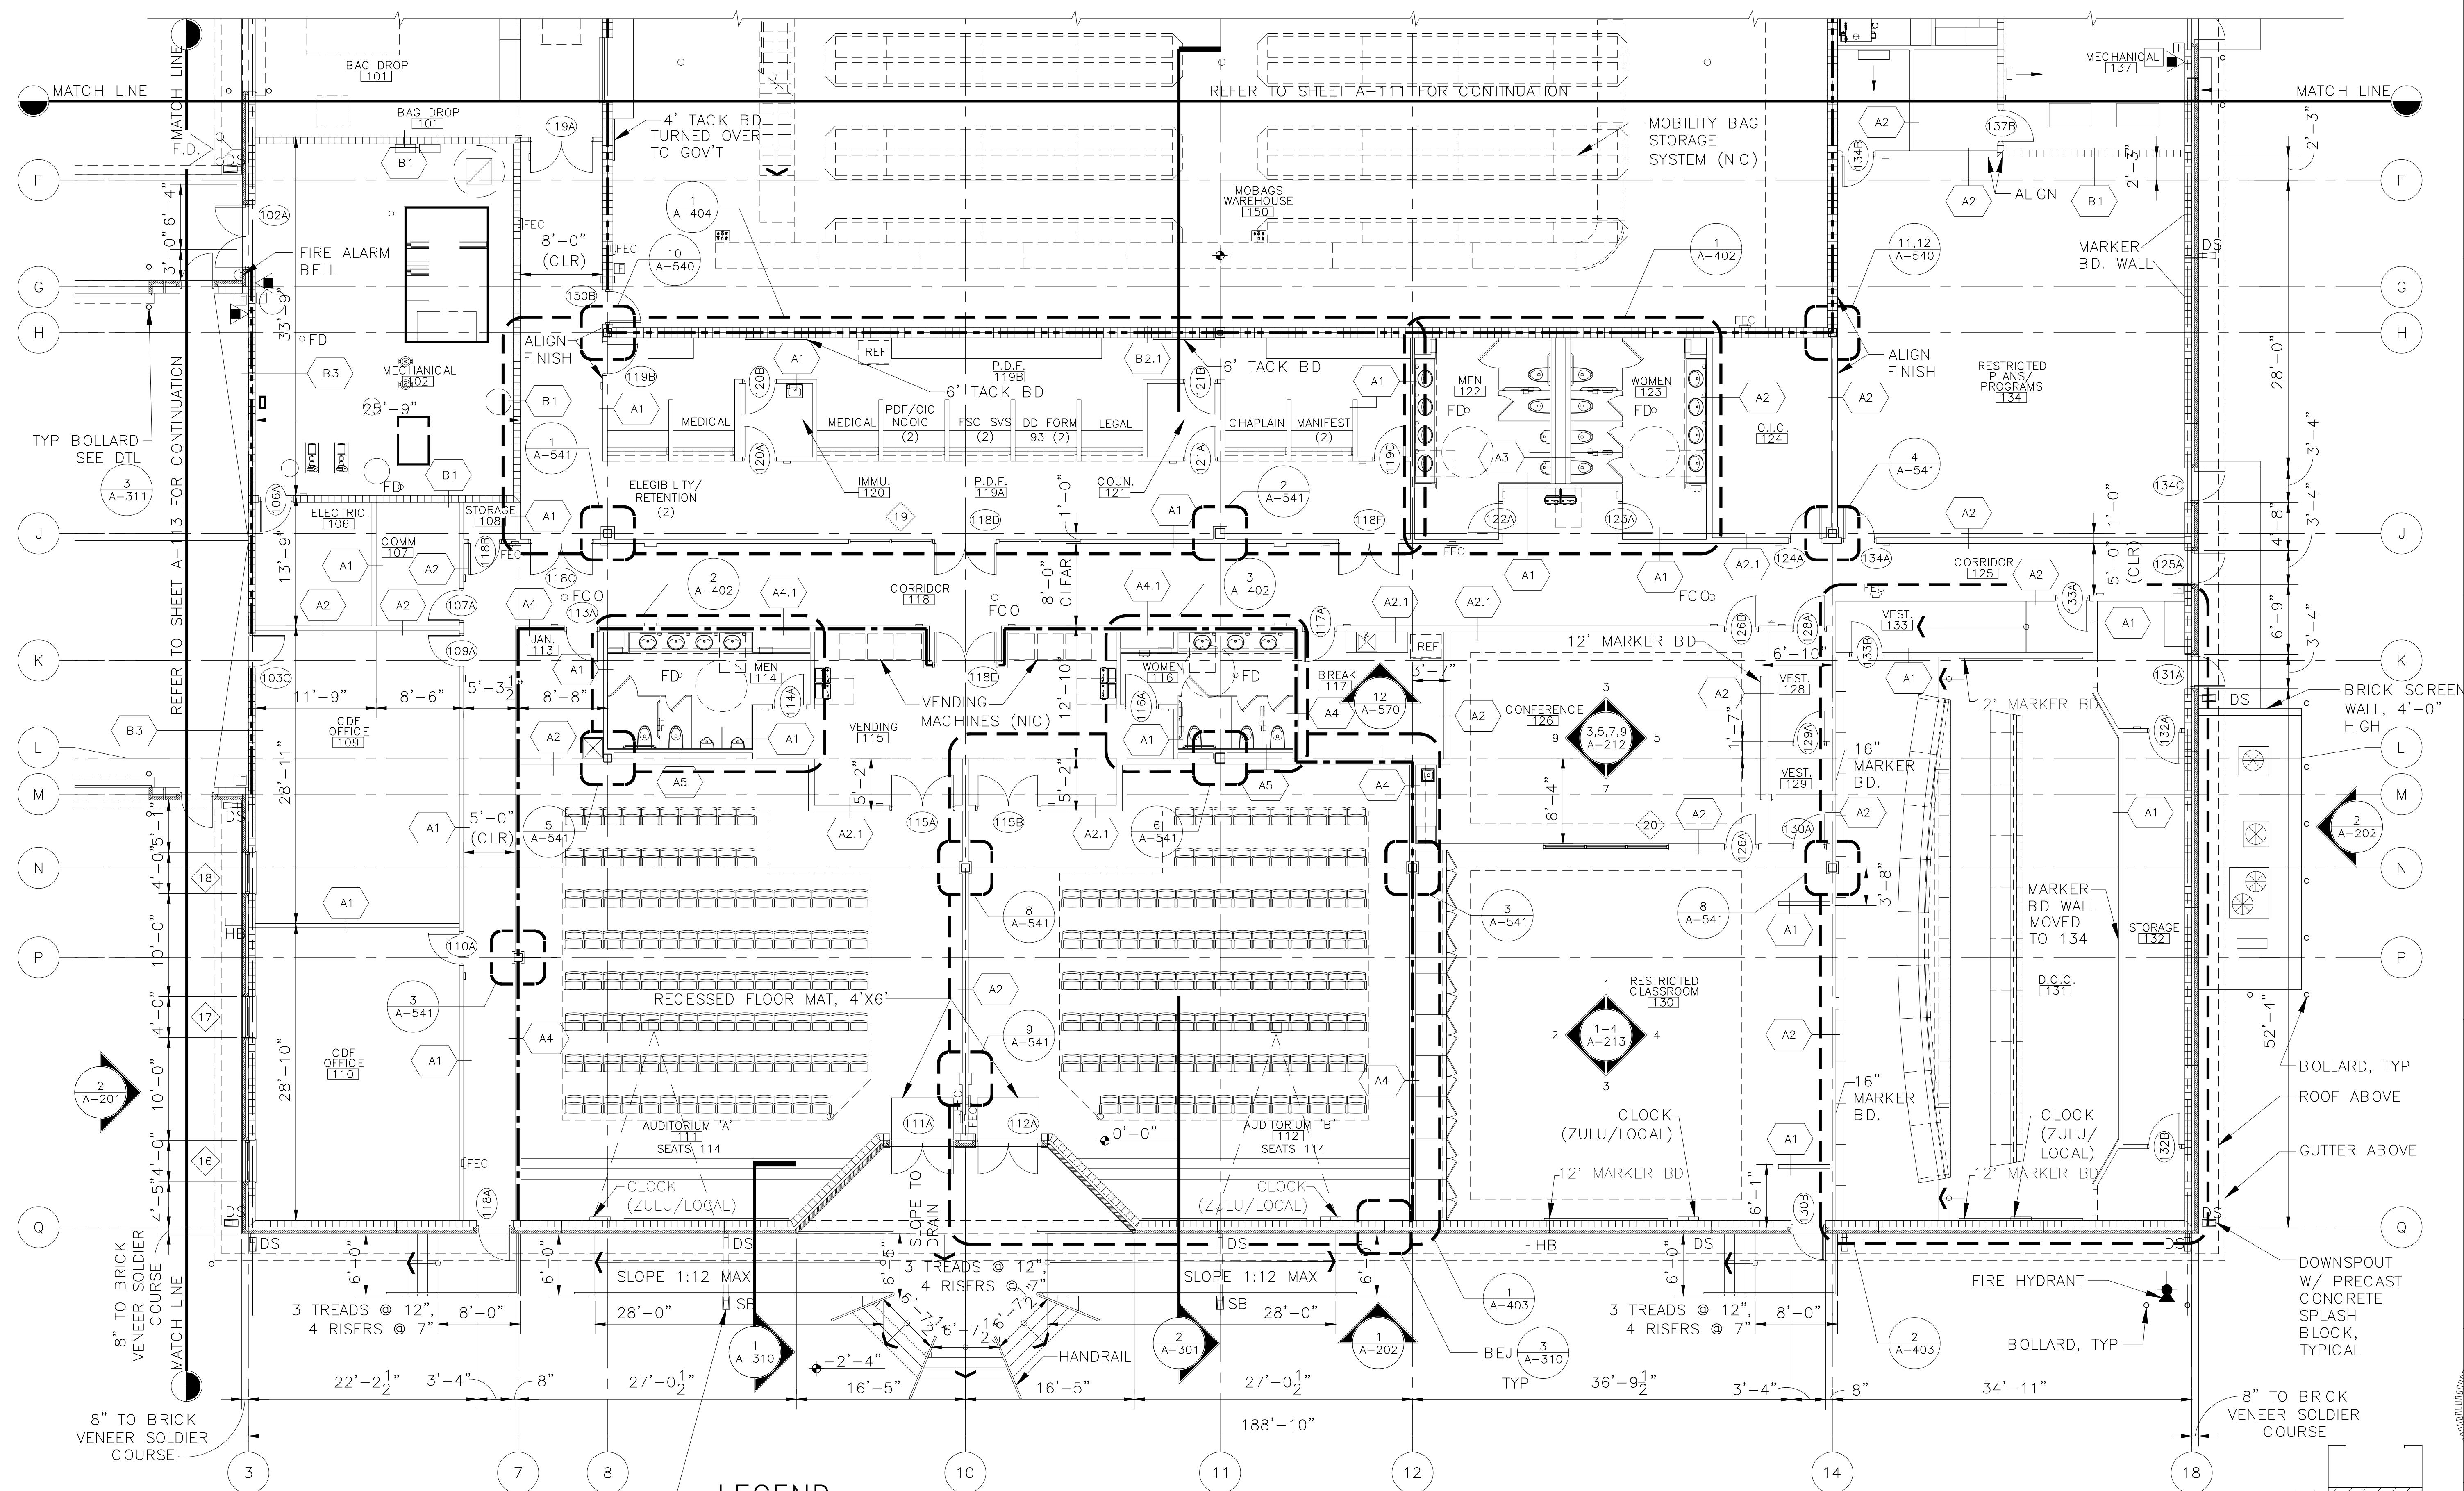


PARTIAL FLOOR PLAN - AREA 'B'
SCALE: 1/8" = 1'-0"

LEGEND

- DOOR NUMBER
- WINDOW NUMBER
- WALL TYPE NUMBER SEE SHT A-501
- GRADE 0'-0" ELEVATION HEIGHT
- COLUMN NUMBER
- ROOM NAME
- ROOM NUMBER

- 8" C.M.U. WALL WITH 4" BRICK VENEER
- 1 HOUR RATED FIRE WALL
- 2 HOUR RATED FIRE WALL
- 8" C.M.U. WALL
- SEE WALL TYPES ON A-501 AND A-502
- F HOSE BIBB
- FEC SEMI RECESSED FIRE EXTINGUISHER CABINET W/FIRE EXTINGUISHER UNIT, REFER TO DETAIL 1/A-502
- ▲ DRY CHEMICAL EXTINGUISHER (ABC TYPE)

NOTE: ALL DIMENSIONS ARE BASED ON COLUMN CENTER LINES OR FACE OF FRAME/CMU WALL
DRAWINGS FULL SIZE IF 22"x34", REDUCED TO HALF SIZE IF 11"x17"

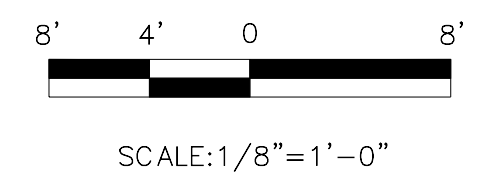

1347 Palmetto Ave., Suite 200
Charleston, SC 29405
Phone 407-644-6777
Fax 407-740-7337

TRANS SYSTEMS CORPORATION

DR

DRZ

CH ENGR

MPJ

PRINCIPAL

DATE

DRAWING REVISIONS

Rev. Description

AS-BUILT DATE

8/14/07

APPROVED

DATE

SHAW AIR FORCE BASE

DEPLOYMENT PROCESSING CENTER

PARTIAL FLOOR PLAN - AREA 'B'

Naval Facilities Engineering Command

Southern Division

Charleston, South Carolina

REGISTERED ARCHITECT

DAVID R. ZANN

10227

RECORD DRAWING DATE

05/21/04

CODE I.D. NO.

80091

DRAWING SIZE: ANSI D

SPEC. NO. 06-03-0308

CONSTRN. CONTR. NO.

N62467-03-C-0308


NAVFAC DRAWING NO.

5417174

SHEET

31 OF 190

A-112

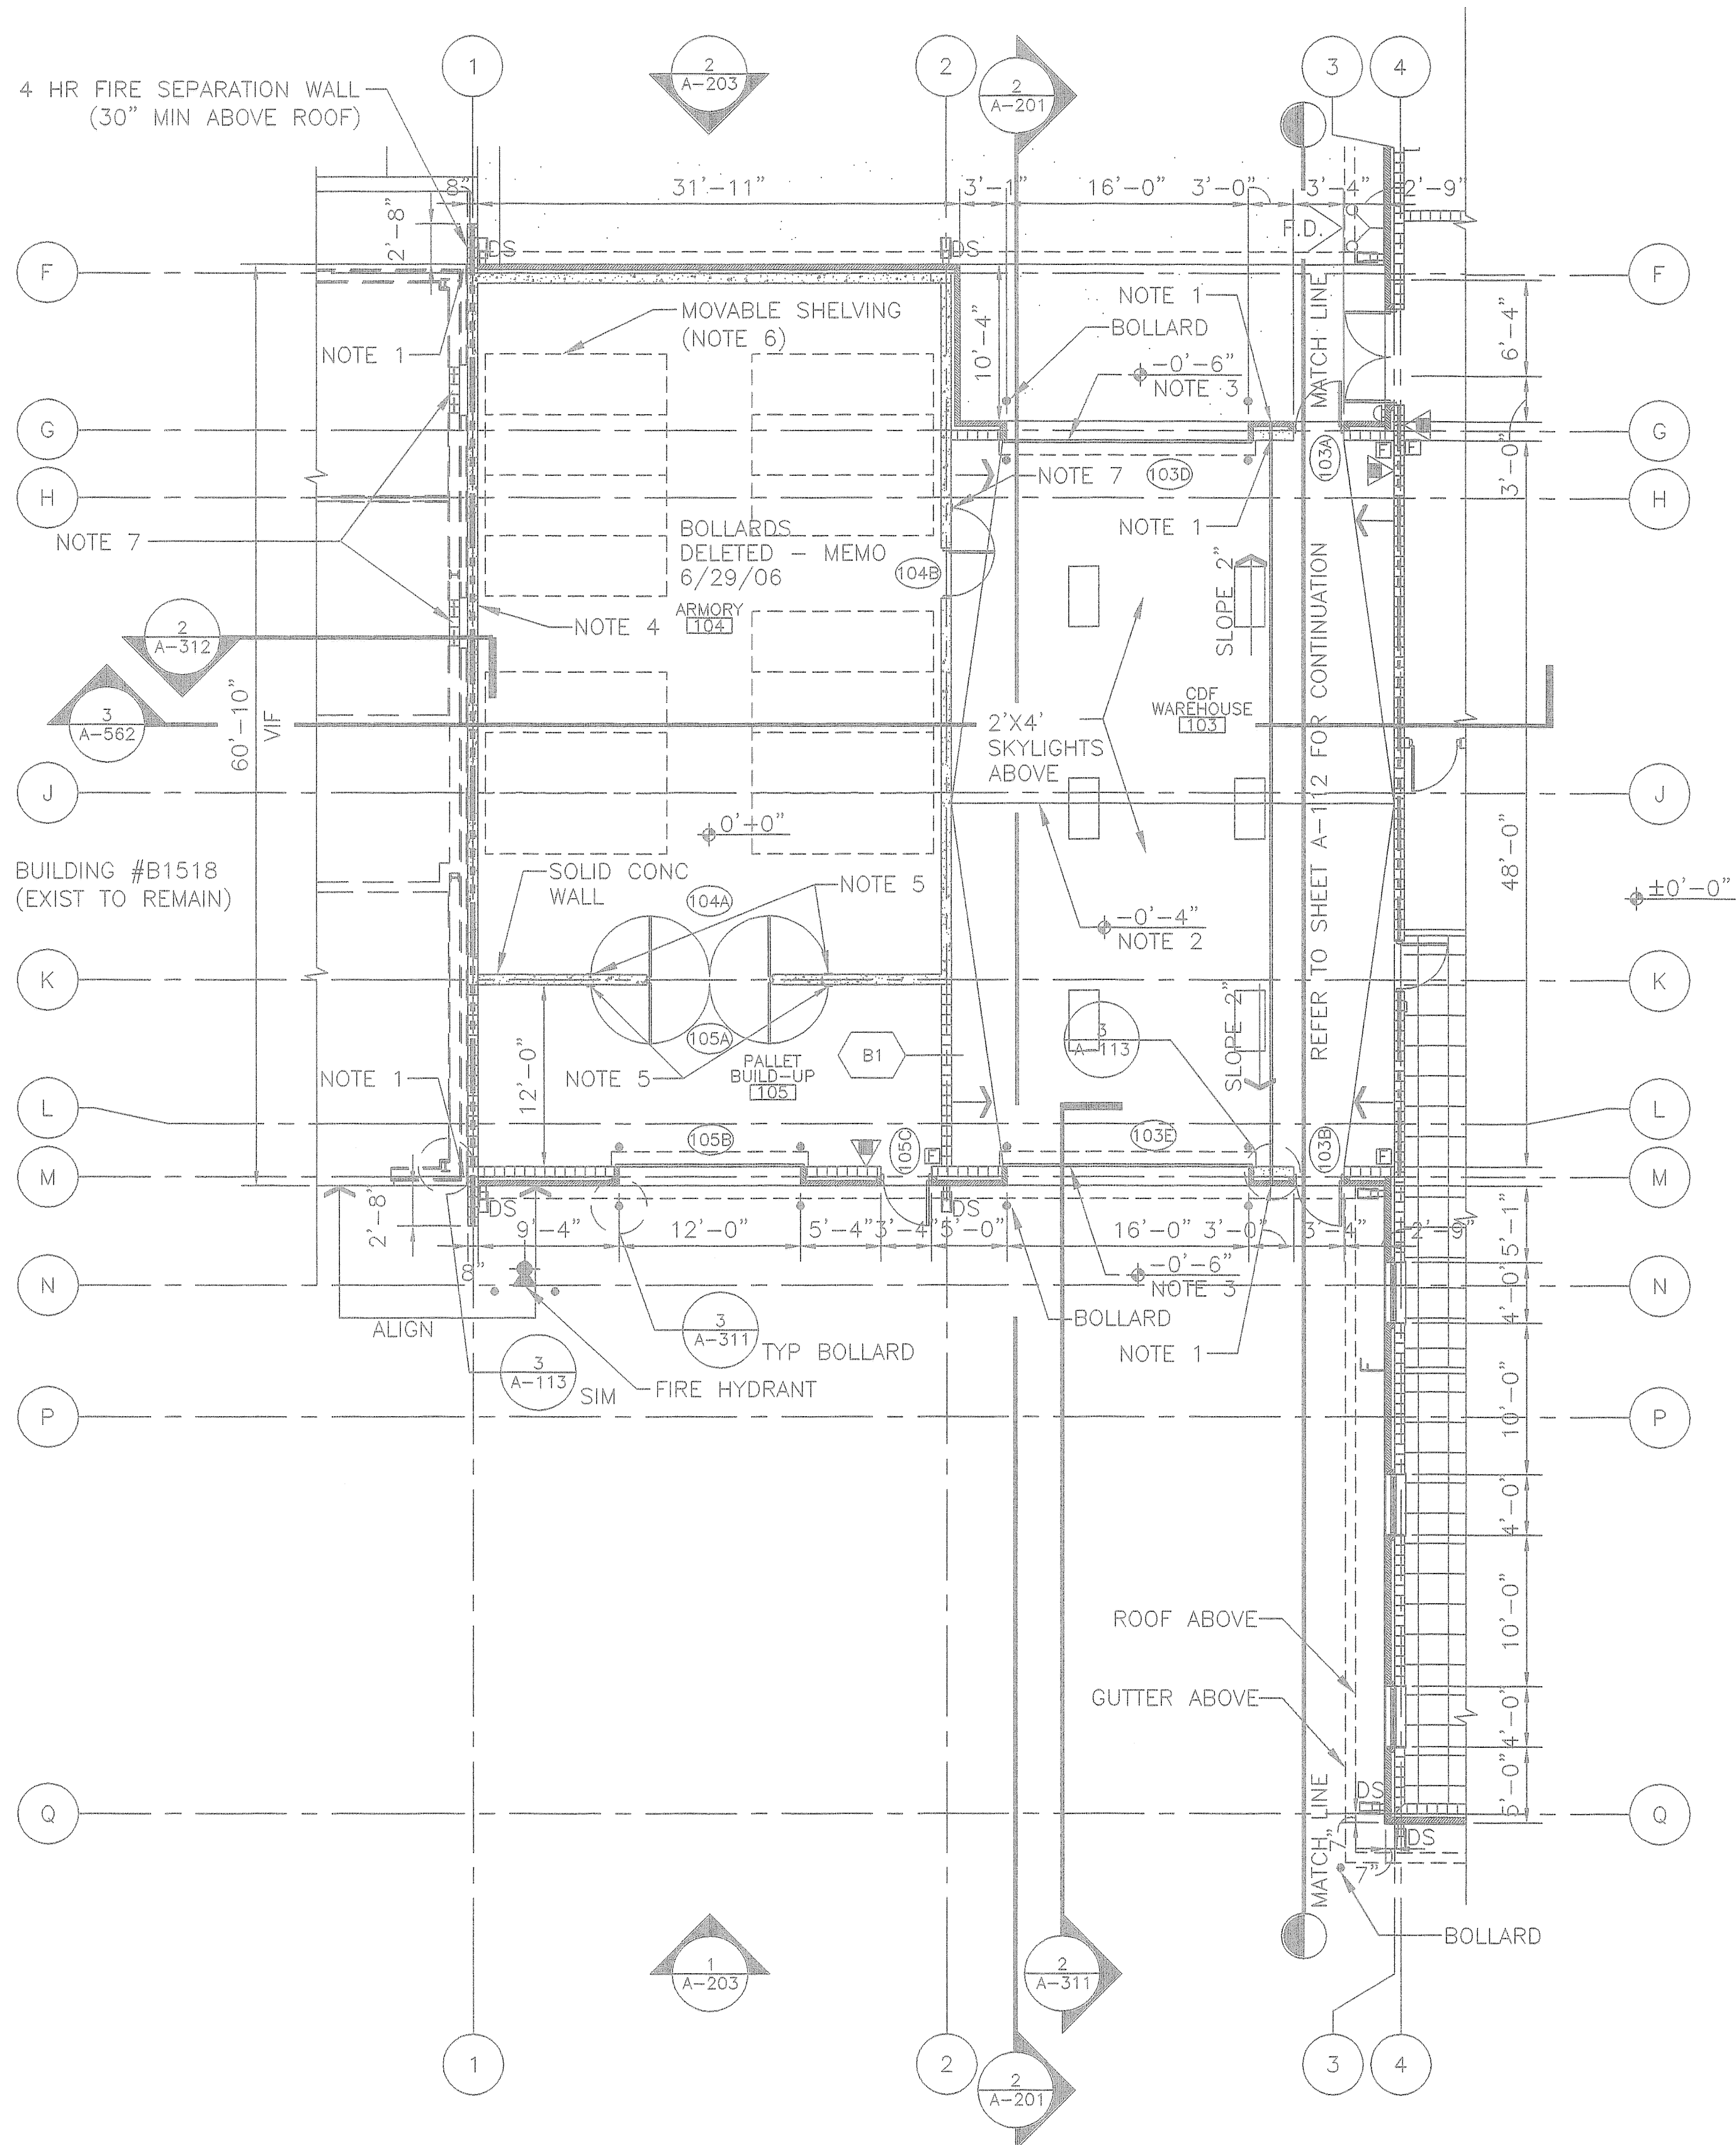

PARTIAL FLOOR PLAN - AREA 'C'
SCALE: 1/8" = 1'-0"


LEGEND

- DOOR NUMBER
- WINDOW NUMBER
- WALL TYPE NUMBER SEE SHT A-501
- GRADE ±0'-0" ELEVATION HEIGHT
- COLUMN NUMBER
- ROOM NAME ROOM NUMBER


- 8" C.M.U. WALL WITH 4" BRICK VENEER
- 1 HOUR RATED FIRE WALL
- 2 HOUR RATED FIRE WALL
- 8" C.M.U. WALL
- SEE WALL TYPES ON A-501 AND A-502

NOTE: REFER TO SHEET D-104 FOR WORK REQUIRED TO EXISTING BUILDING #B1518 (TO REMAIN)


- PLAN NOTES:
- NOTE 1 2" SEISMIC ISOLATION JOINT @ ROOF, CEILING AND WALLS
 - NOTE 2 HIGH POINT OF CONC SLAB
 - NOTE 3 LOW POINT OF CONC SLAB
 - NOTE 4 4 HOUR FIRE SEPARATION WALL; EXTEND WALL 30" MIN ABOVE ROOF LINE
 - NOTE 5 3"x3"x2" 'L' DOOR STOP BOLTED TO CONC FLOOR SLAB @ ARMORY DOOR; REFER TO DETAIL 4/A-113
 - NOTE 6 GOVERNMENT FURNISHED ROLLING SHELVING SYSTEM TO BE INSTALLED BY GOVERNMENT AND COORDINATED BY CONTRACTOR. REFER TO PHOTO BELOW.
 - NOTE 7 PROVIDE CMU INFILL AT EXISTING WINDOW OPENING. PROVIDE NEW METAL STUDS AND GYP BD PAINTED TO MATCH EXISTING WALL

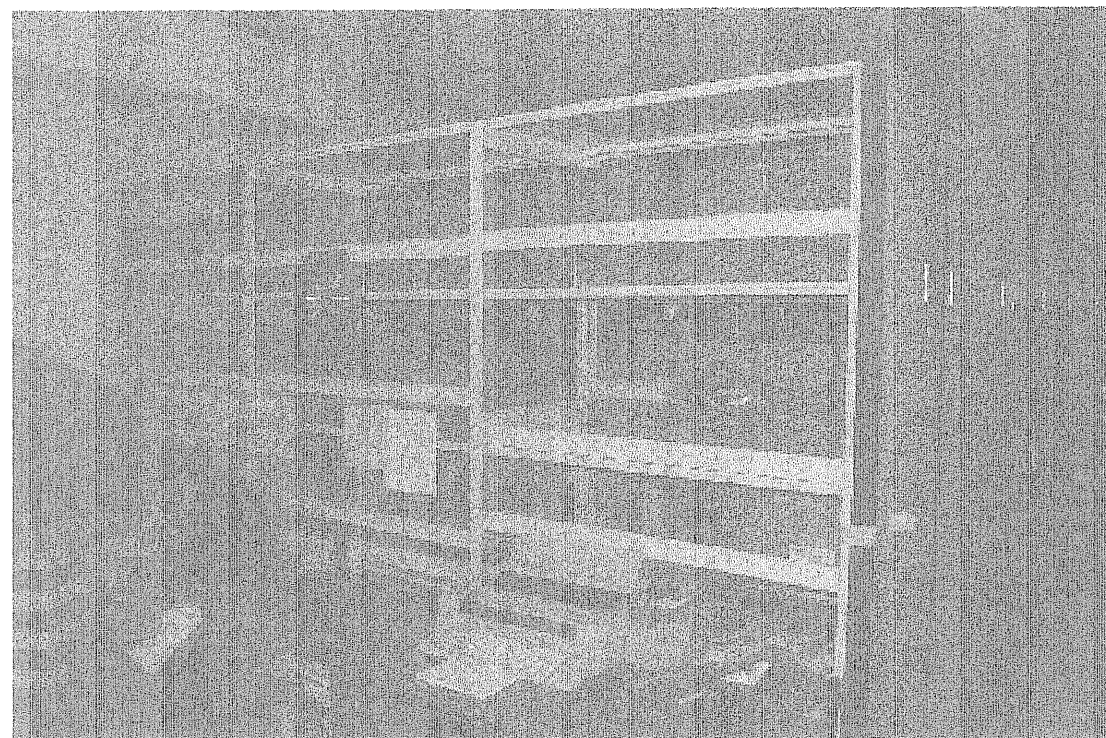


MOVABLE SHELVING

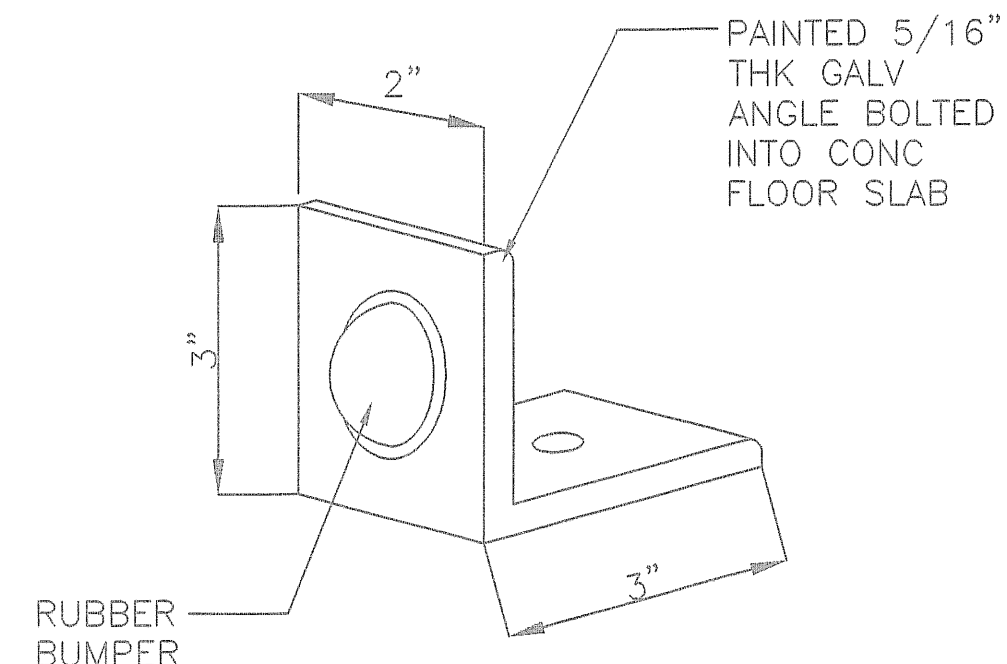


VAULT DOOR STOP
SCALE: NOT TO SCALE

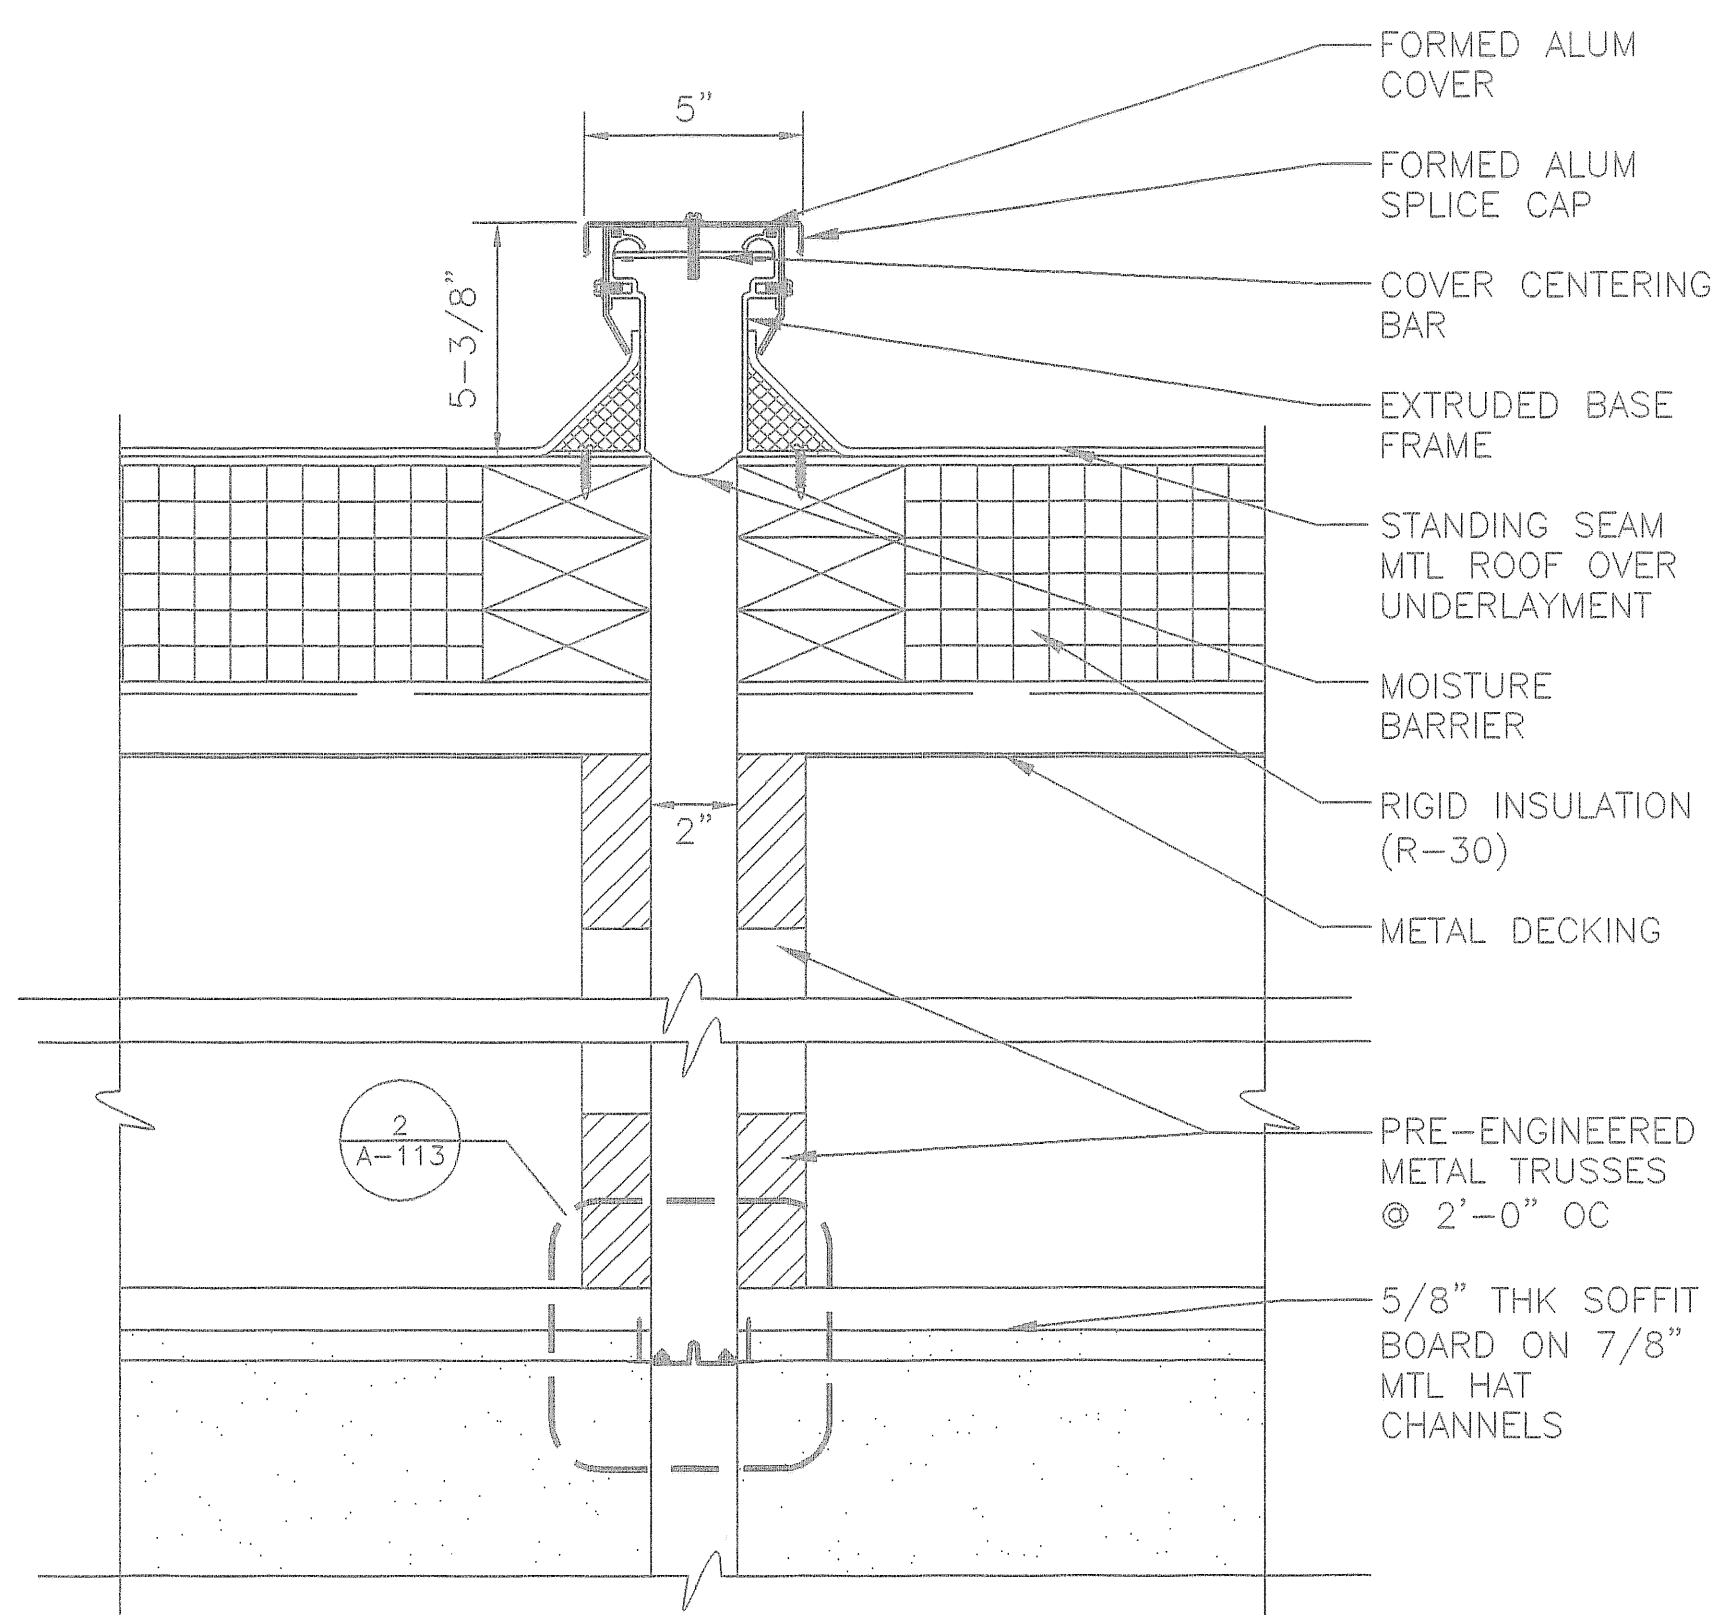


ROOF SEISMIC ISOLATION JOINT
SCALE: 3"=1'-0"

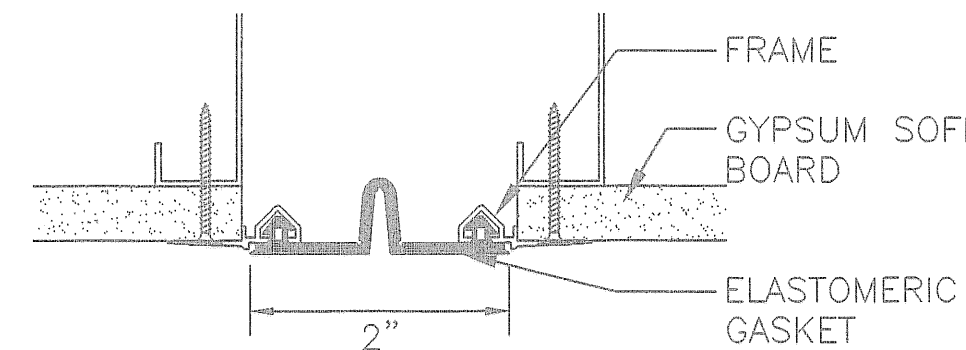

CEILING SEISMIC ISOLATION JOINT
SCALE: 3"=1'-0"

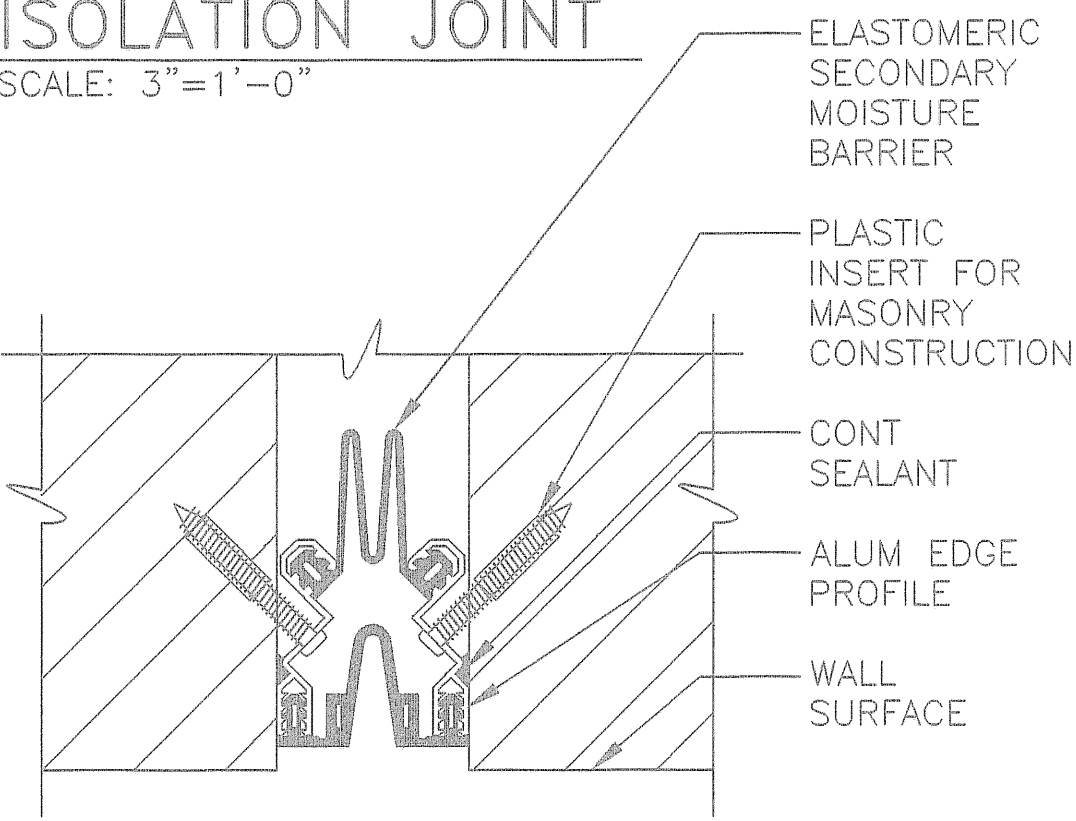

SEISMIC ISOLATION JOINT @ BRICK/CMU
SCALE: 3"=1'-0"

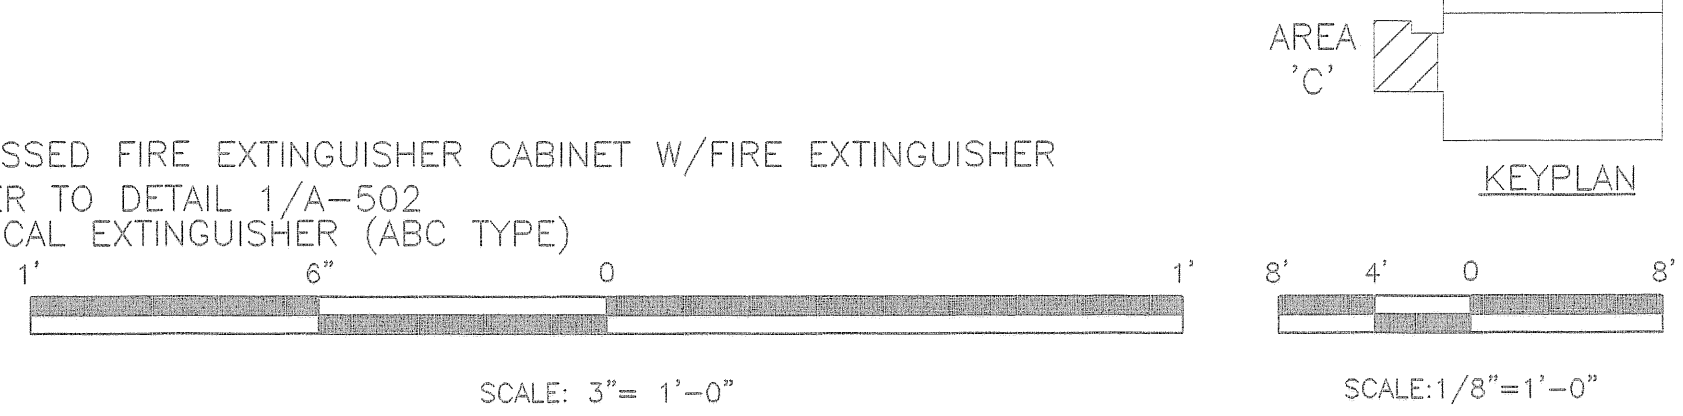

ISAT Planning, Inc. - Suite 200
1000 Highway 101, Suite 200
Pawleys Island, SC 29585
Phone: 803-444-8777
Fax: 803-444-7587


SHAW AIR FORCE BASE
SOUTH CAROLINA
DEPARTMENT OF DEFENSE
NAVY FACILITIES ENGINEERING COMMAND
Southern Division
Charleston, South Carolina

RECORD DRAWING DATE: 05/21/04
CODE I.D. NO.: 80091
DRAWING SIZE: ANSI D
SPEC. NO. 06-03-0308
CONSTR. CONTR. NO. N62467-03-C-0308
NAVFAC DRAWING NO. 5417175
SHEET 32 OF 190

DATE: 8/14/07
APPROVED: [Signature]
EFD FOR COMMANDER, NAVFAC

AREA 'C'

A-113

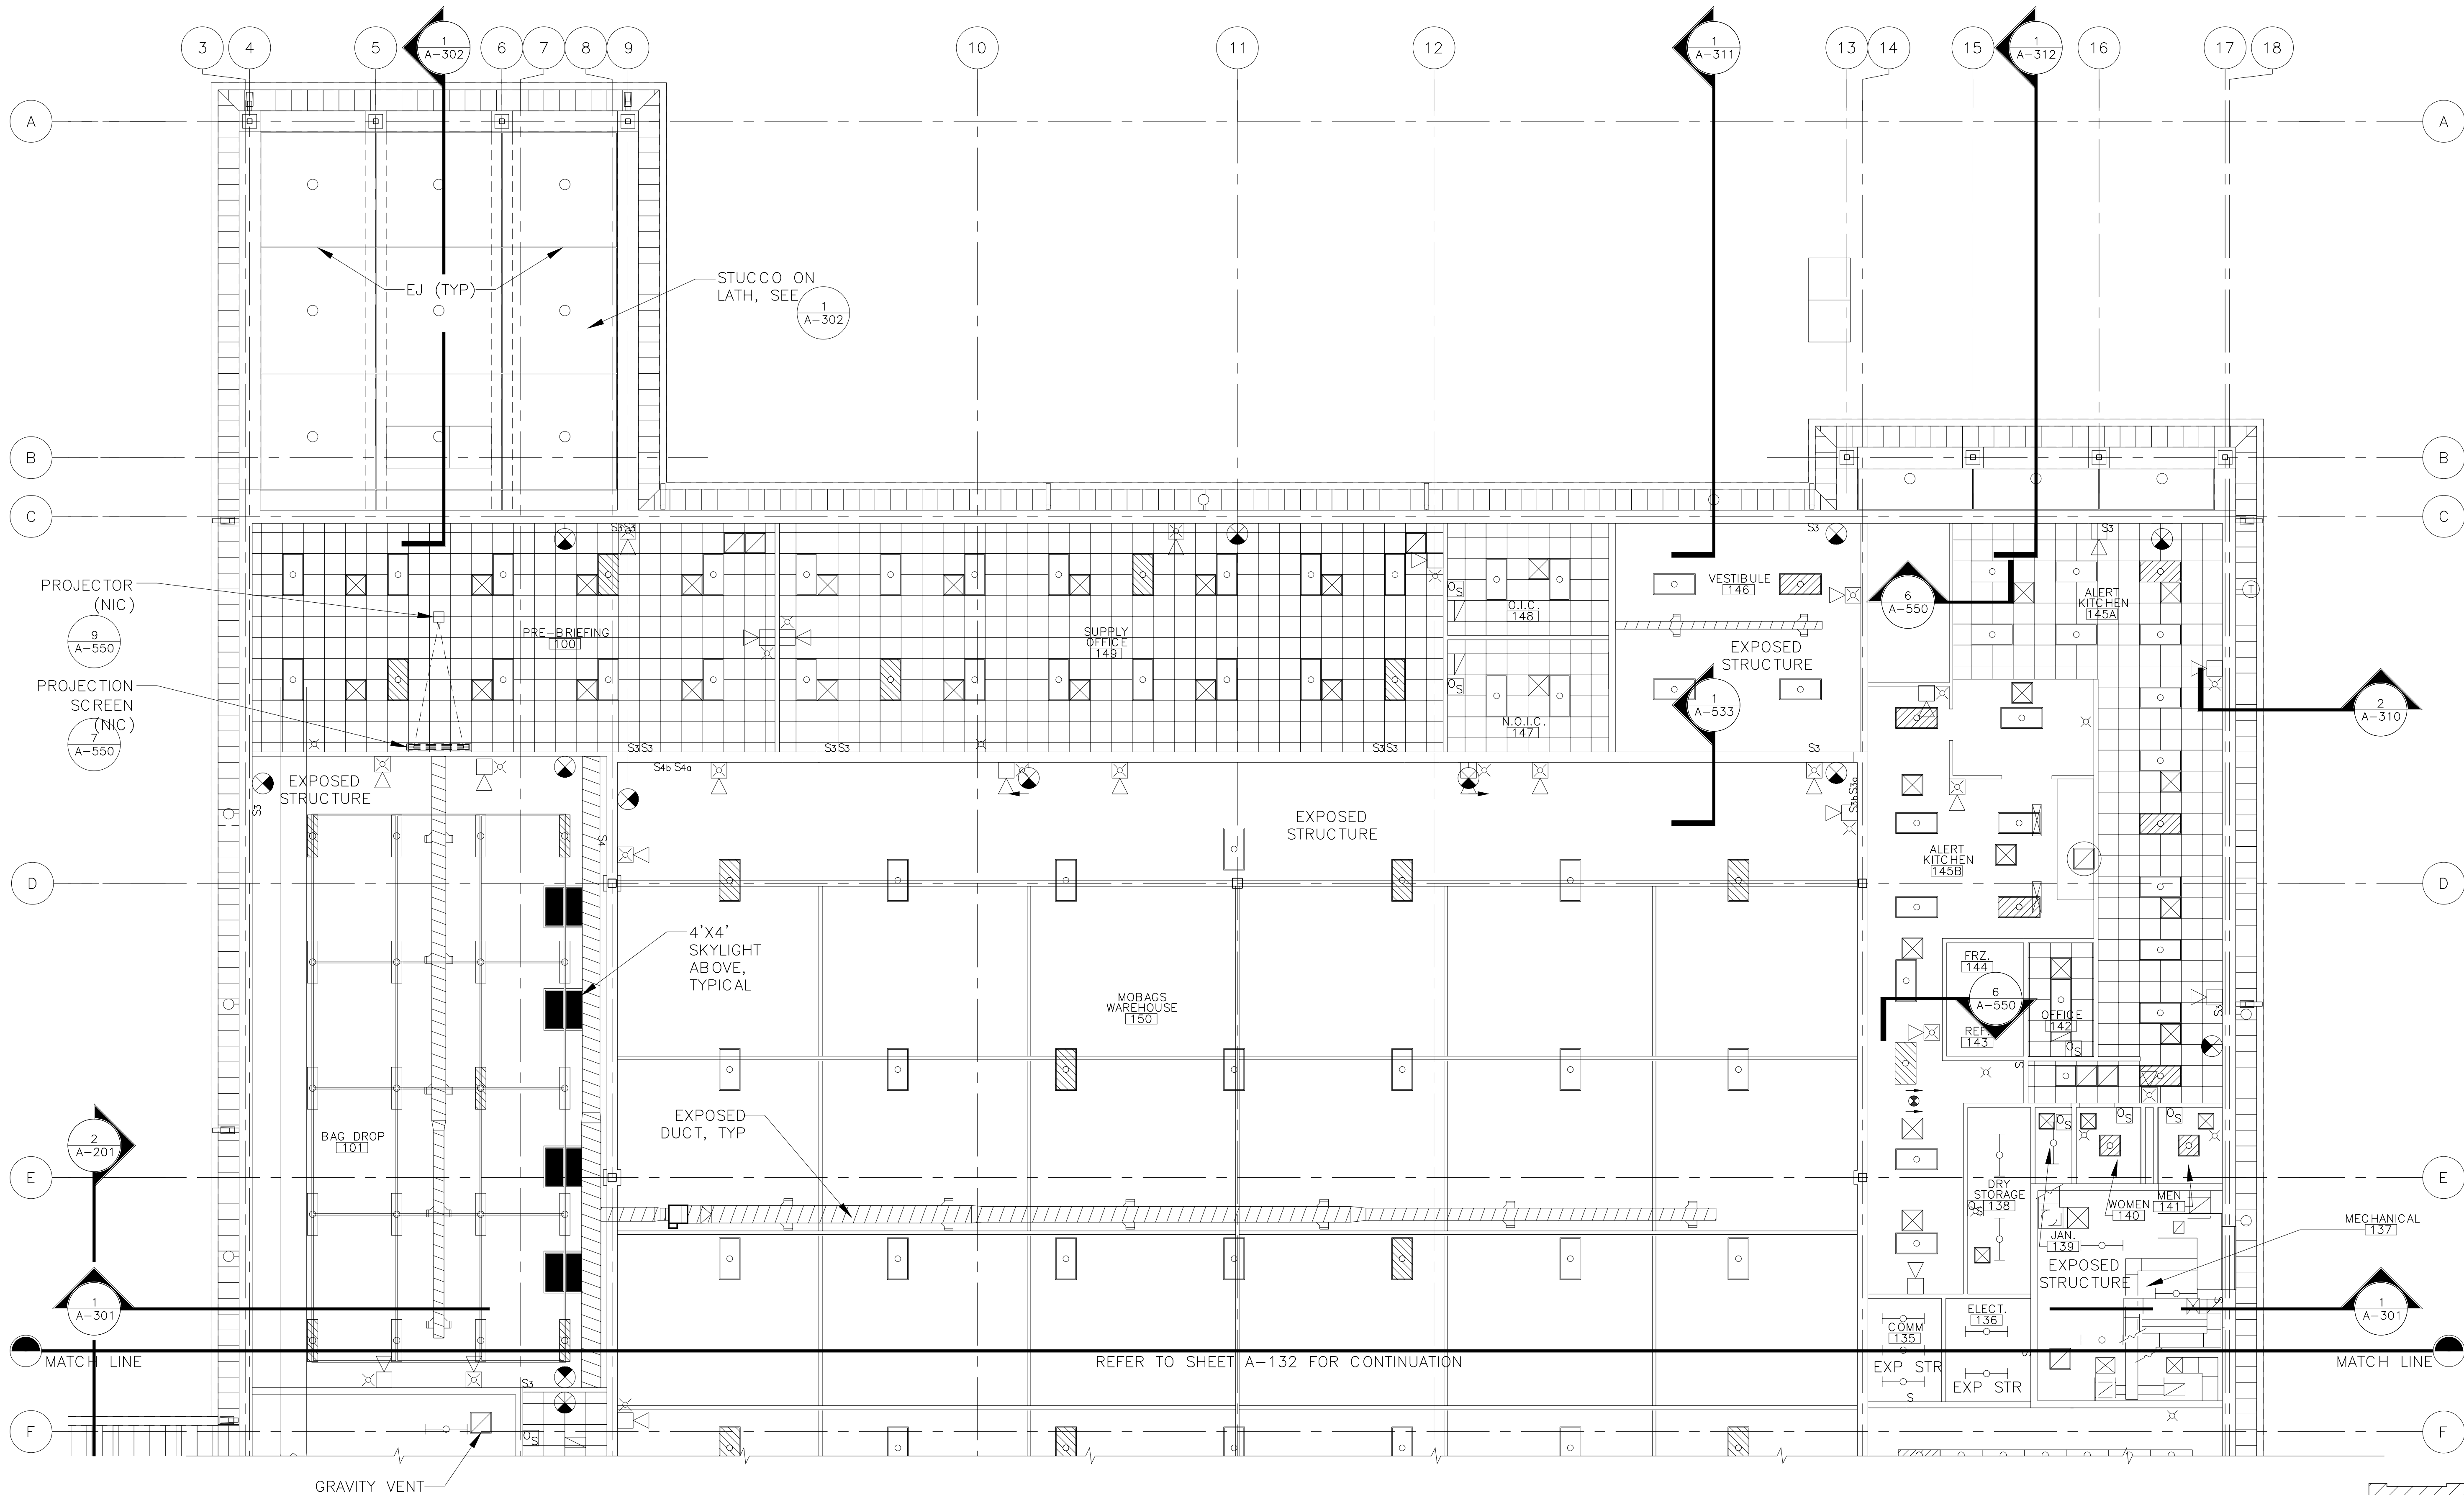



PARTIAL REFLECTED CEILING PLAN - AREA 'A'
SCALE: 1/8" = 1'-0"

LEGEND

- MECHANICAL DIFFUSERS; REFER TO HVAC PLAN, SHEET M-102
- LIGHT FIXTURES; REFER TO LIGHTING PLAN, SHEET E-101
- ALARM DEVICES; REFER TO TELECOMMUNICATION PLAN, SHEET E-107

NOTE: REFER TO MEP DRAWING FOR SPECIFIC REQUIREMENTS

DRAWINGS FULL SIZE IF 22"x34", REDUCED TO HALF SIZE IF 11"x17"

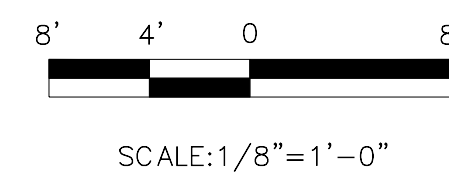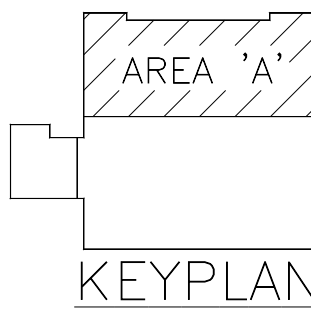

1347 Pinnetto Ave. Suite 200
Charleston, SC 29405
Phone 407-544-6777
Fax 407-740-7337

USDA DRZ SUPV

CH ENGR

MPJ

DATE

REVISIONS

AS-BUILT DATE

DATE

Rev.

AS-BUILT DATE

DATE

Prep By

Date

Appr'd

8/14/07

TRANS SYSTEMS CORPORATION

CH ENGR

MPJ

DATE

USDA DRZ SUPV

CH ENGR

MPJ

DATE

REVISIONS

AS-BUILT DATE

DATE

Rev.

AS-BUILT DATE

DATE

Prep By

Date

Appr'd

8/14/07

SHAW AIR FORCE BASE

SOUTH CAROLINA

DEPLOYMENT PROCESSING CENTER

PARTIAL REFLECTED CEILING PLAN - AREA 'A'

APPROVED

DATE

EDS FOR COMMANDER, NAVFAC

Naval Facilities Engineering Command

Southern Division

Charleston, South Carolina

STATE OF FLORIDA

REGISTERED ARCHITECT

DAVID R. ZANN

10227

RECORD DRAWING DATE

05/21/04

CODE I.D. NO.

80091

DRAWING SIZE: ANSI D

SPEC. NO. 06-03-0308

CONSTRN. CONTR. NO.

N62467-03-C-0308


NAVFAC DRAWING NO.


5417181

SHEET




38 OF 190

A-131

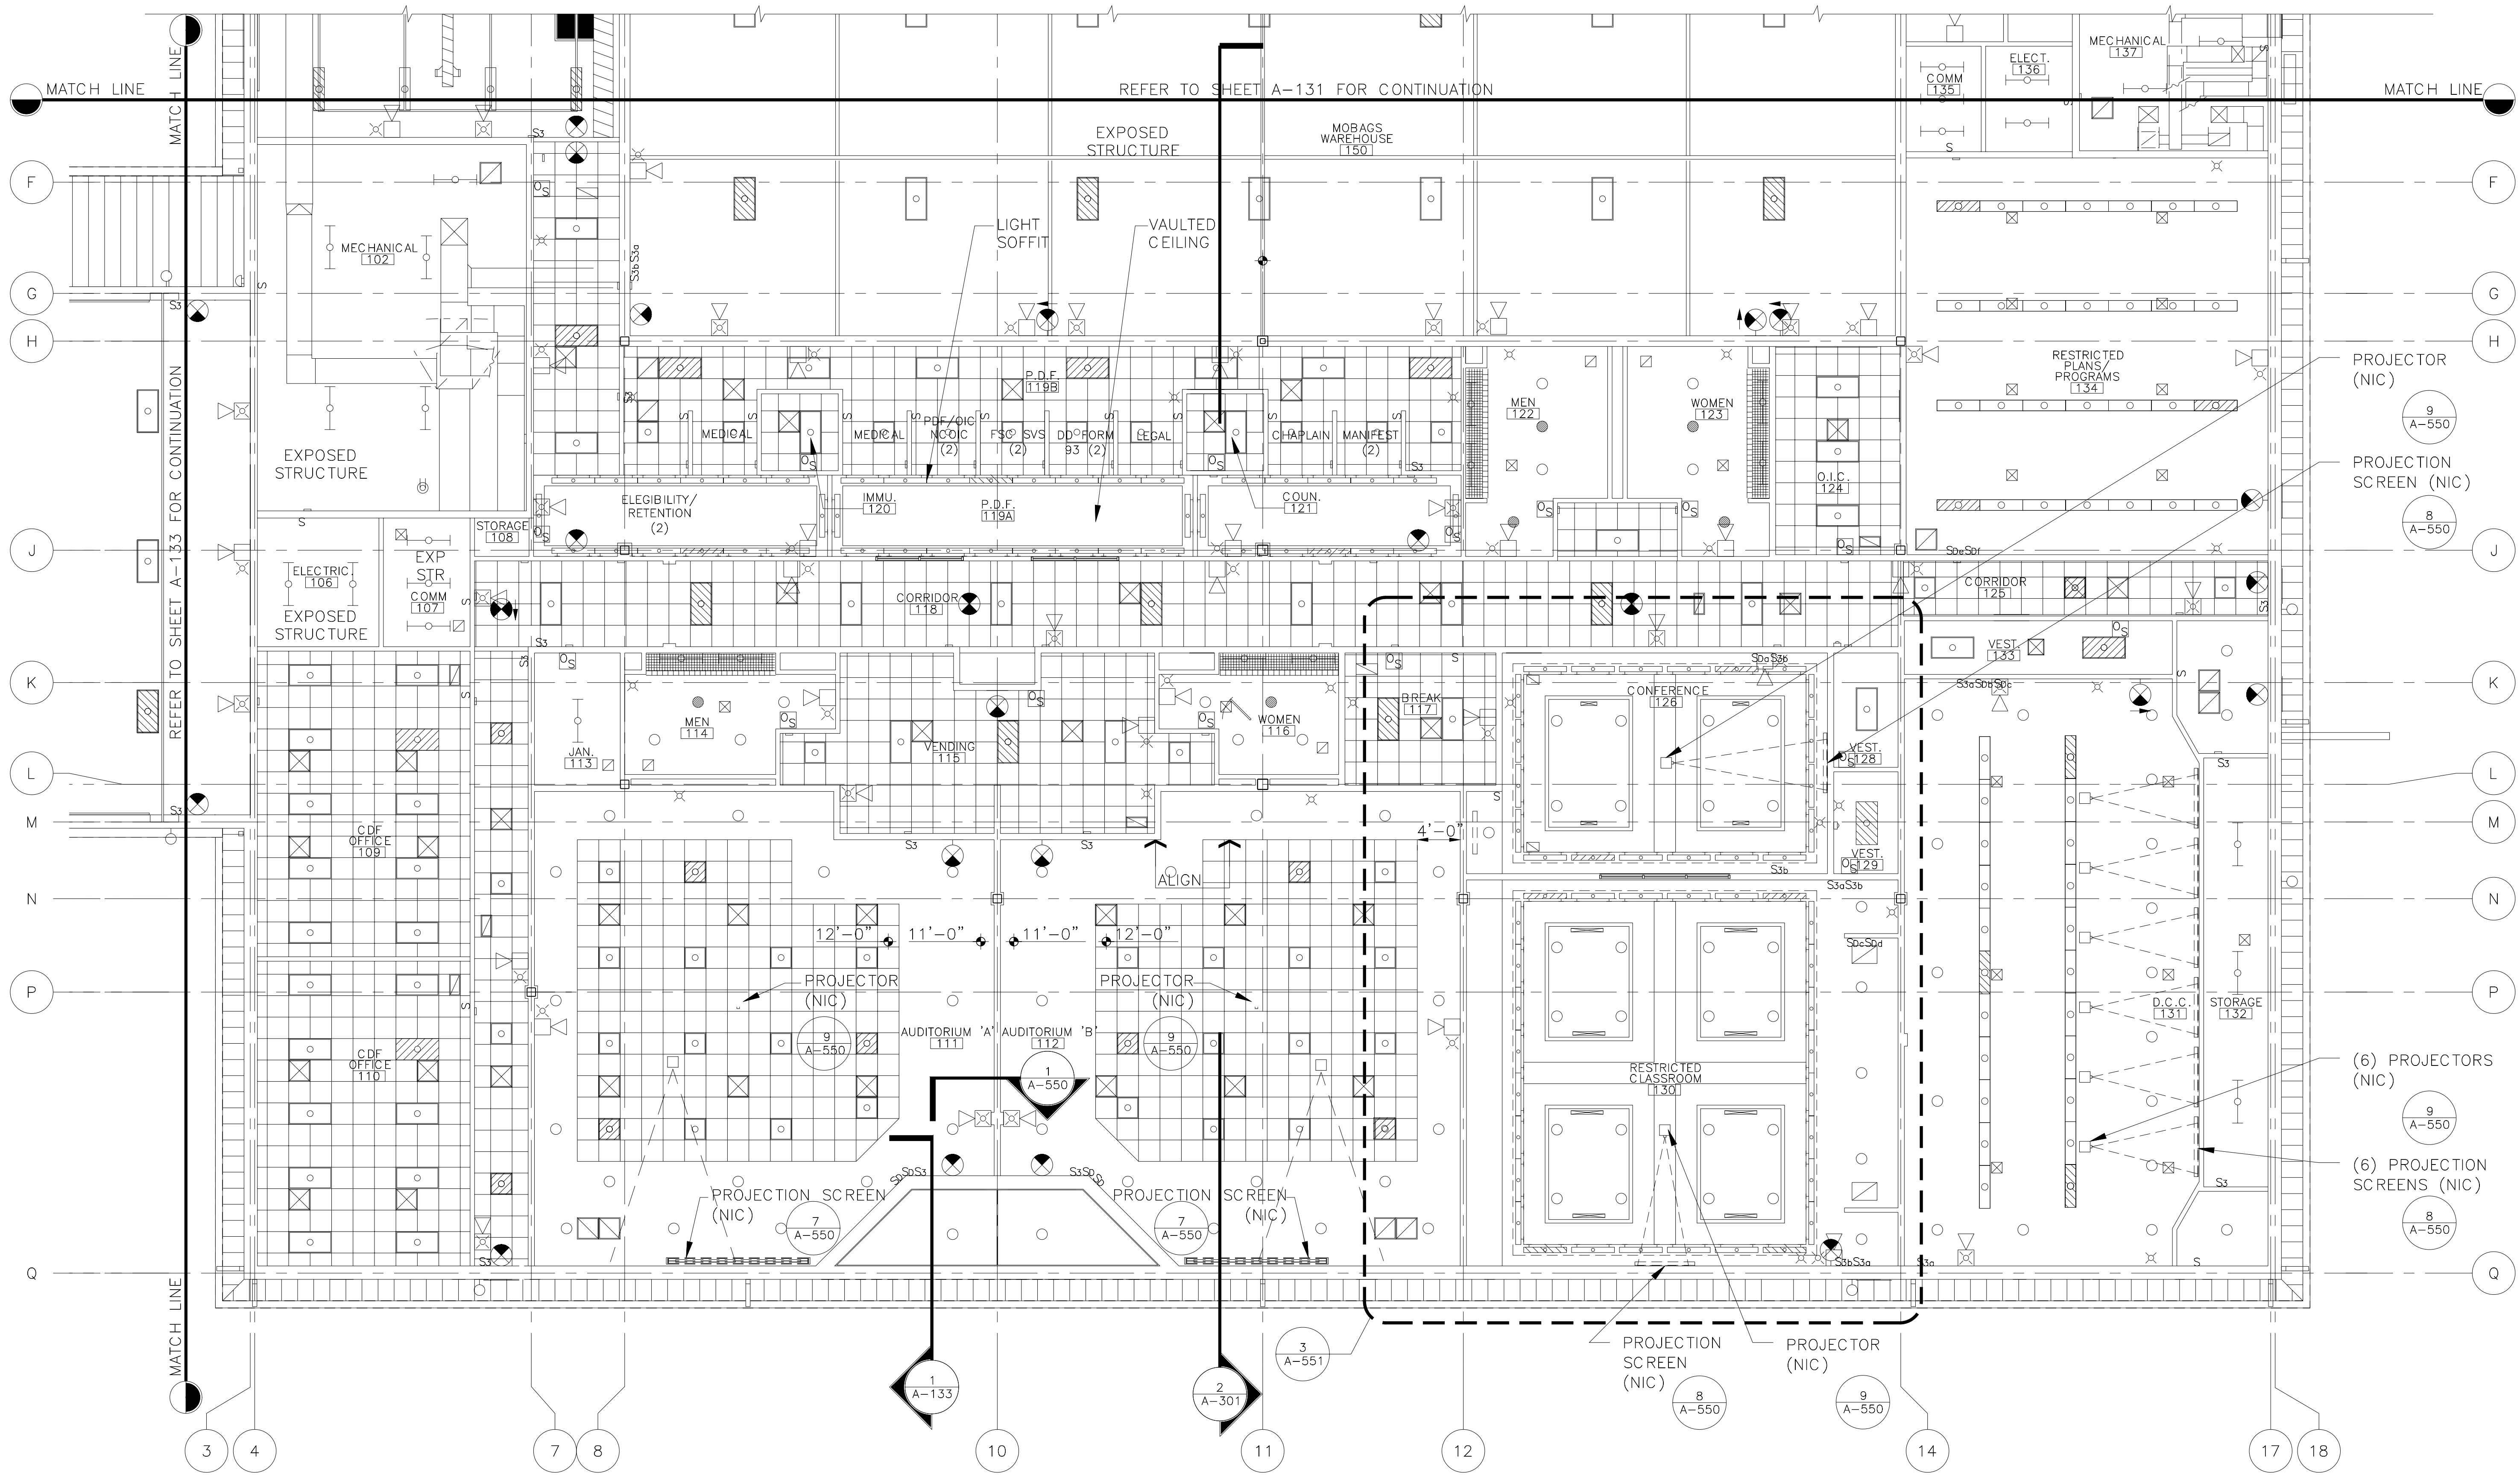

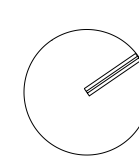
 PARTIAL REFLECTED CEILING PLAN - AREA 'B'
SCALE: 1/8" = 1'-0"

   LEGEND

-  MECHANICAL DIFFUSERS; REFER TO HVAC PLAN, SHEET M-102
-  LIGHT FIXTURES; REFER TO LIGHTING PLAN, SHEET E-101
-  ALARM DEVICES; REFER TO TELECOMMUNICATION PLAN, SHEET E-107

NOTE: REFER TO MEP DRAWING FOR SPECIFIC REQUIREMENTS

DRAWINGS FULL SIZE IF 22"x34", REDUCED TO HALF SIZE IF 11"x17"

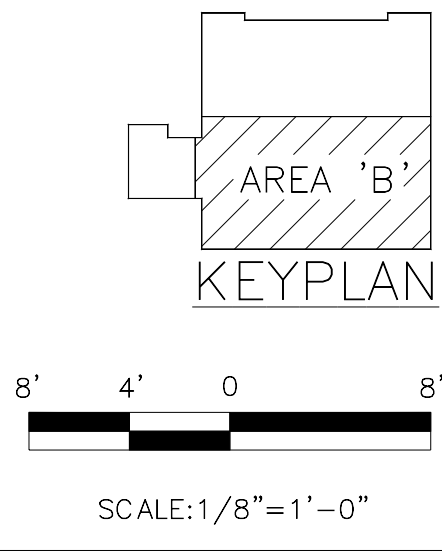

1347 Palmetto Ave., Suite 200
Charleston, SC 29405
Phone 407-644-6777
Fax 407-740-7337



CH ENGR
OR

USN

SUPV

CH ENGR

DATE

PRINCIPAL

DRAWING REVISIONS

Rev.

Description

AS-BUILT DATE

8/14/07

DATE

APPROVED

SOUTH CAROLINA

SHAW AIR FORCE BASE

Engineering Command

Southern Division

Charleston, South Carolina

REGISTERED ARCHITECT

DAVID R. ZANN

10227

RECORD DRAWING DATE

05/21/04

CODE I.D. NO.

80091

DRAWING SIZE: ANSI D

SPEC. NO. 06-03-0308

CONSTRN. CONTR. NO.

N62467-03-C-0308

NAVFAC DRAWING NO.


5417182

SHEET 39 OF 190

DEPLOYMENT

PROCESSING CENTER

A-132

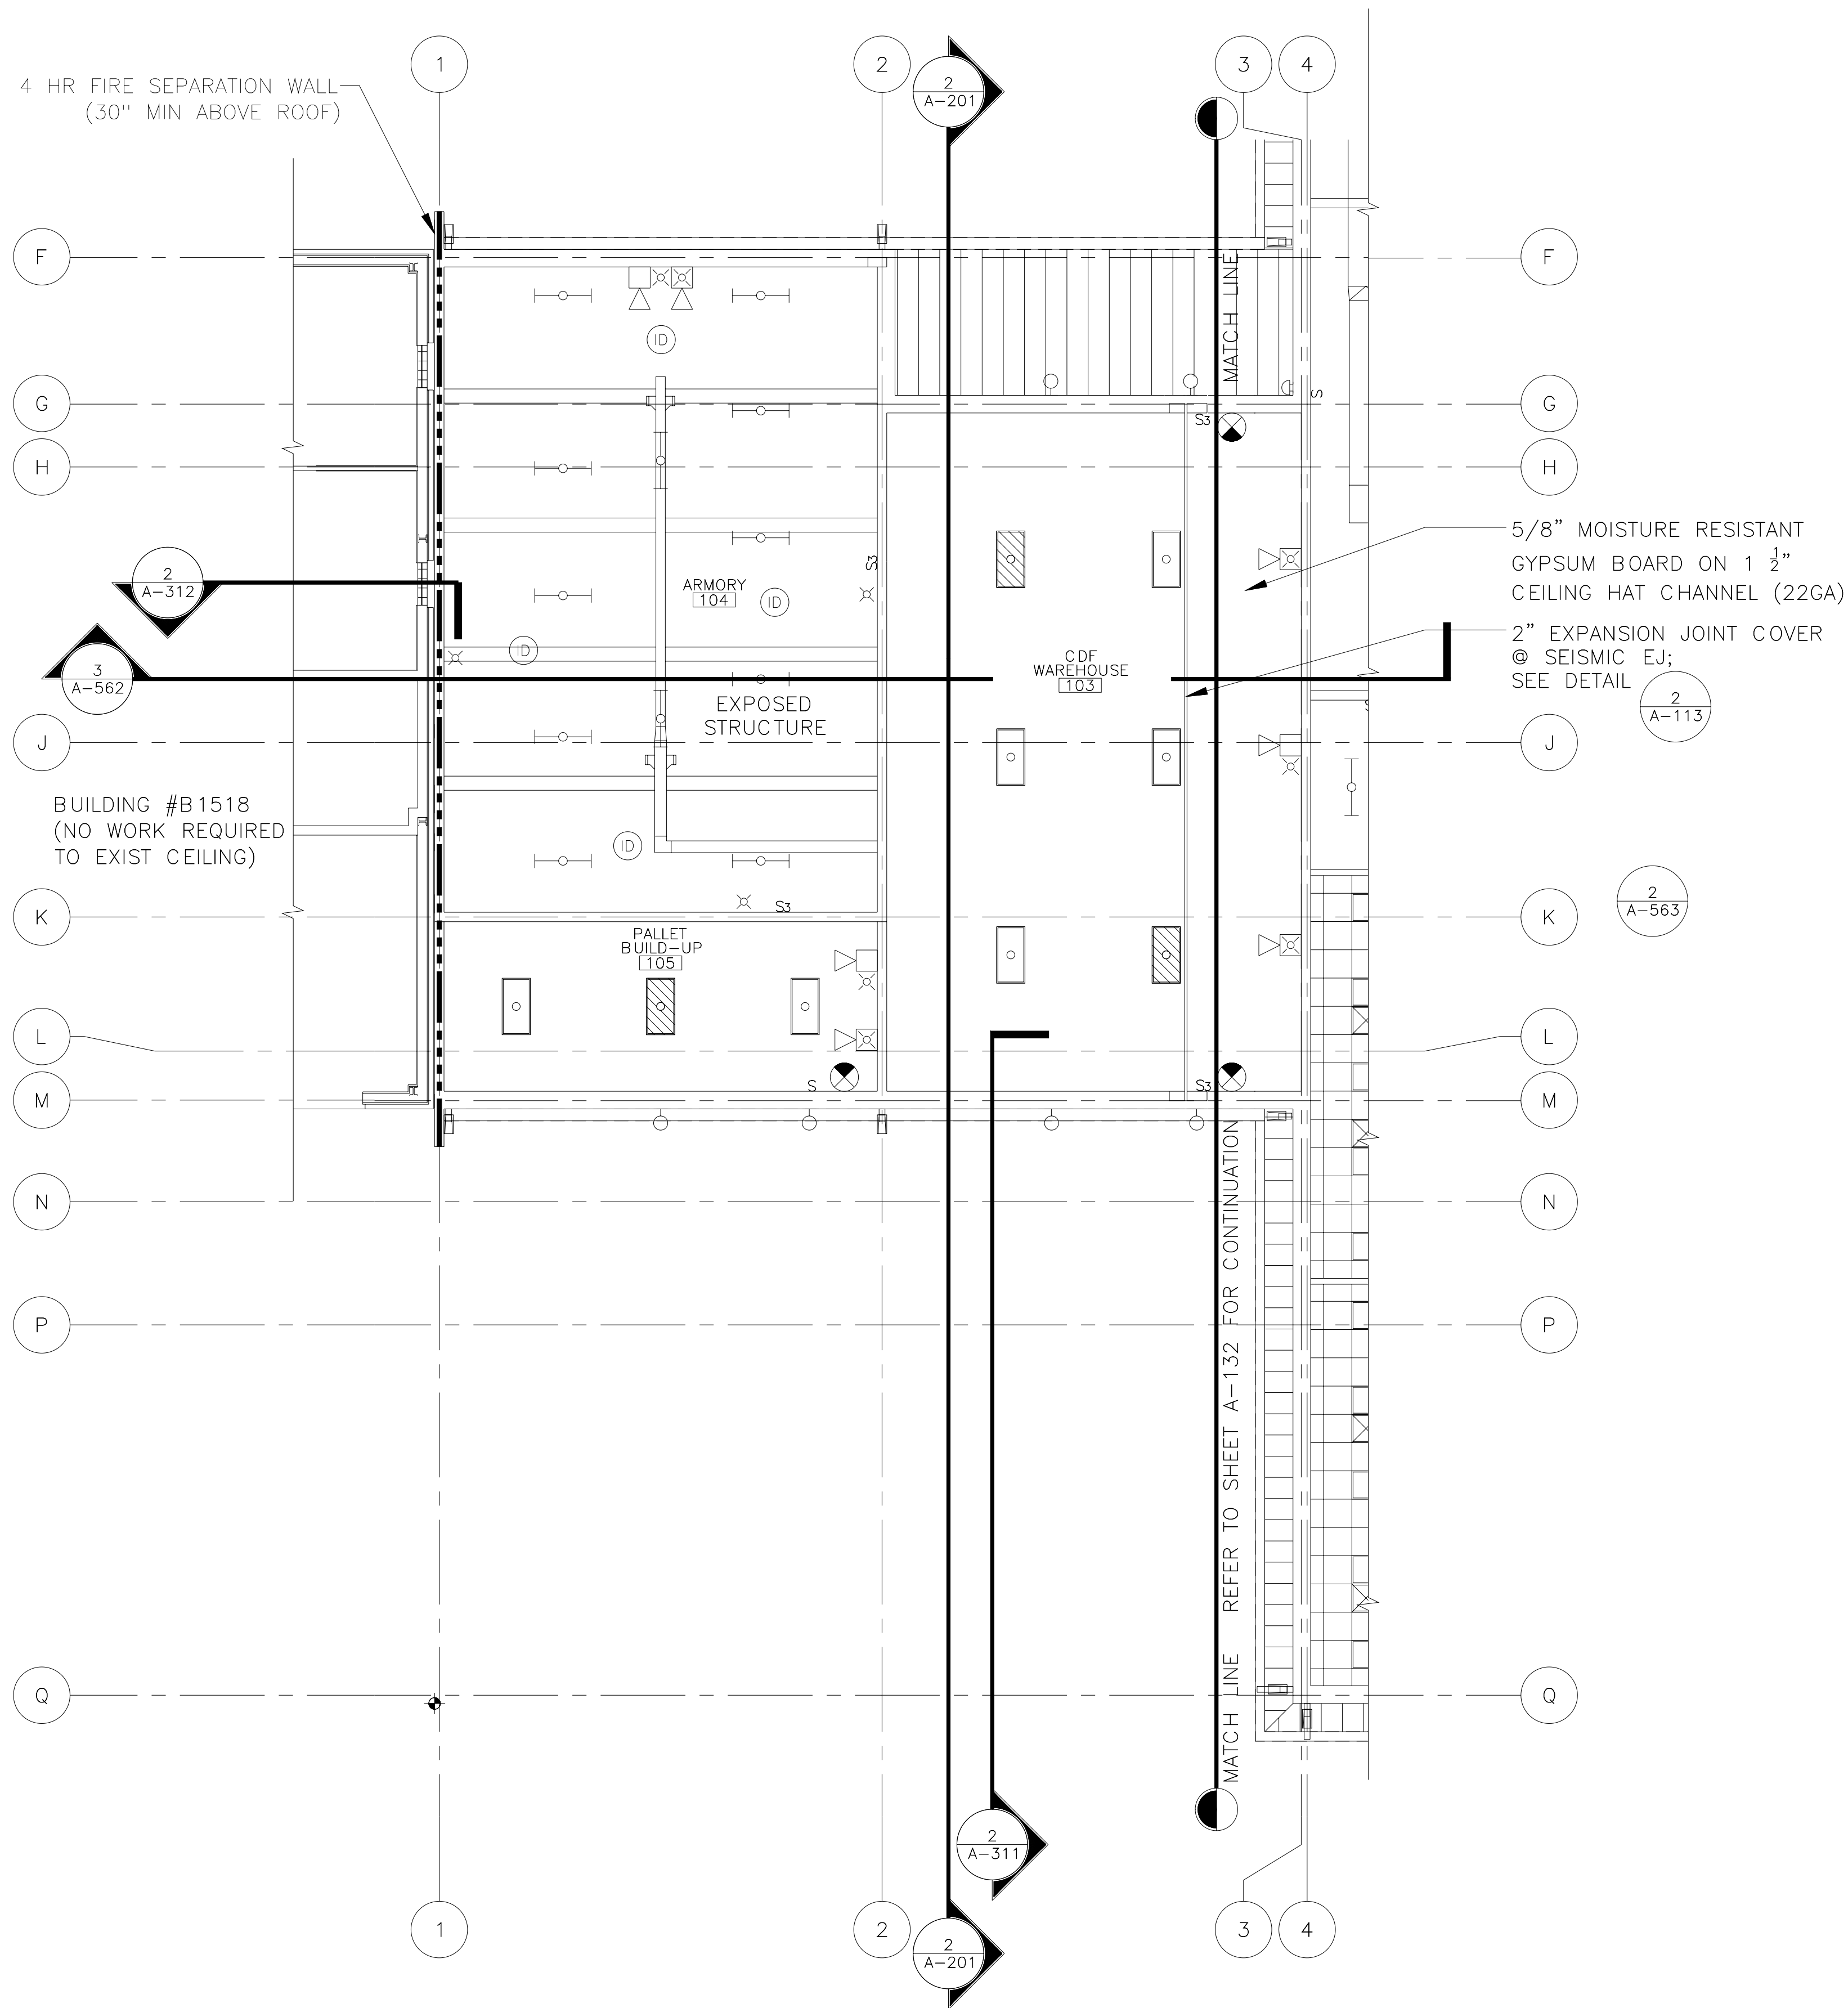


PARTIAL REFLECTED CEILING PLAN - AREA 'C'
SCALE: 1/8" = 1'-0"


LEGEND

- MECHANICAL DIFFUSERS; REFER TO HVAC PLAN, SHEET M-102
 - LIGHT FIXTURES; REFER TO LIGHTING PLAN, SHEET E-101
 - ALARM DEVICES; REFER TO TELECOMMUNICATION PLAN, SHEET E-107
- NOTE: REFER TO MEP DRAWING FOR SPECIFIC REQUIREMENTS

DRAWINGS FULL SIZE IF 22"x34", REDUCED TO HALF SIZE IF 11"x17"

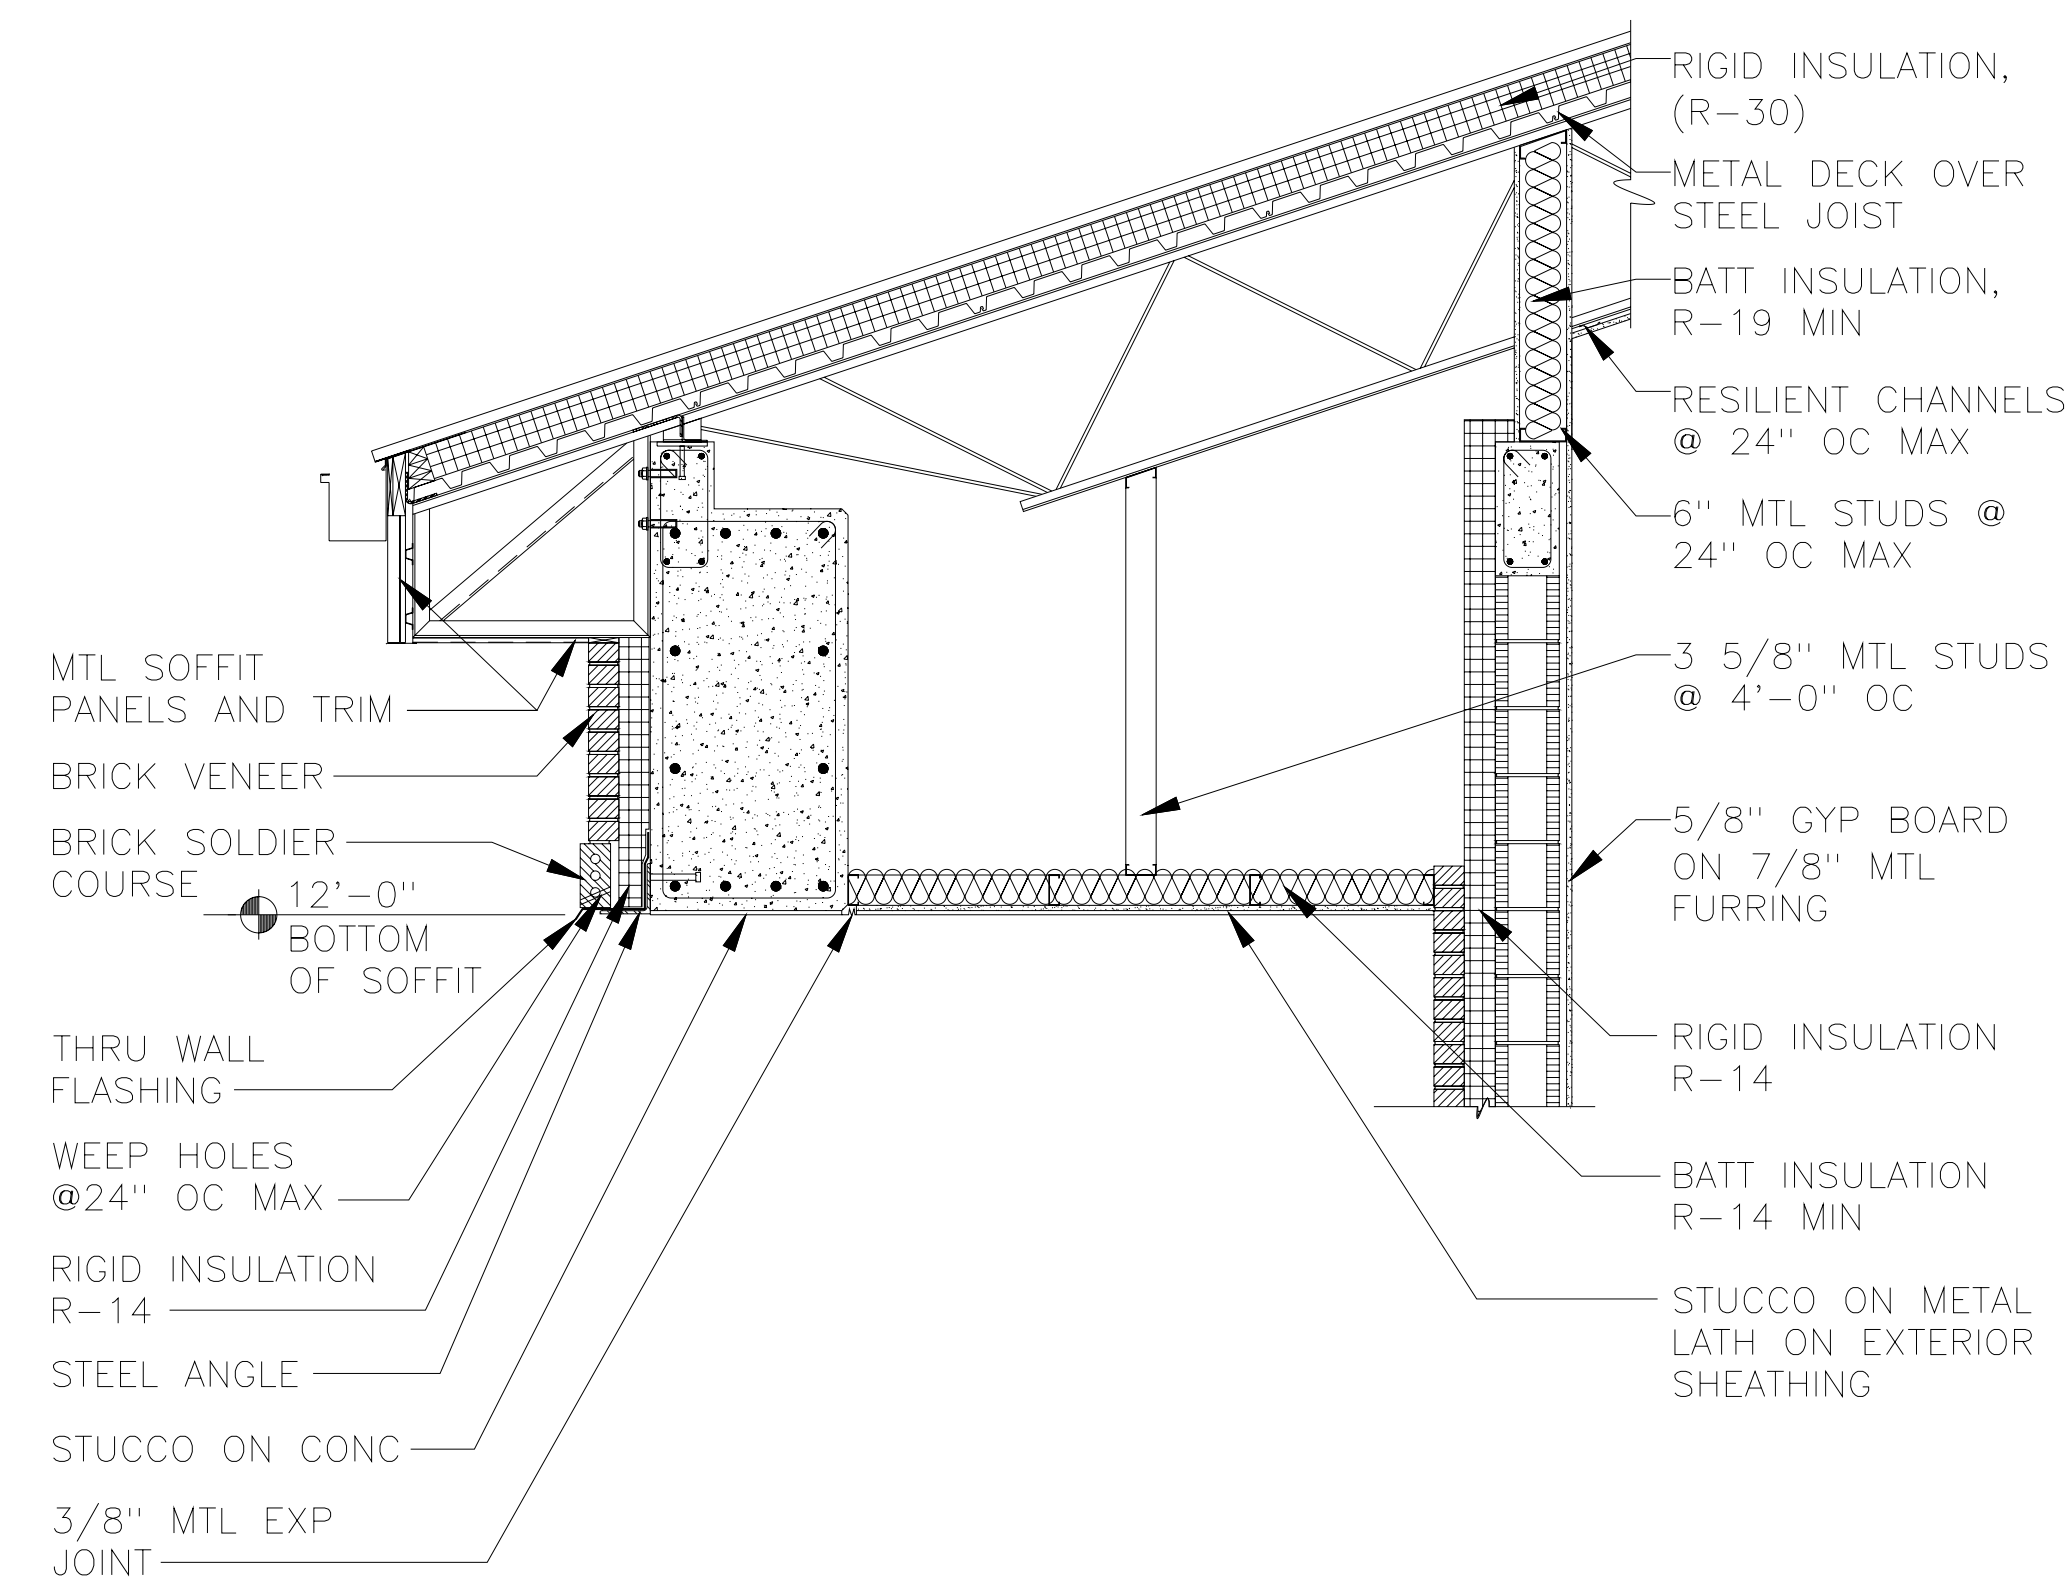

SOFFIT DETAIL
SCALE: 1/2" = 1'-0"

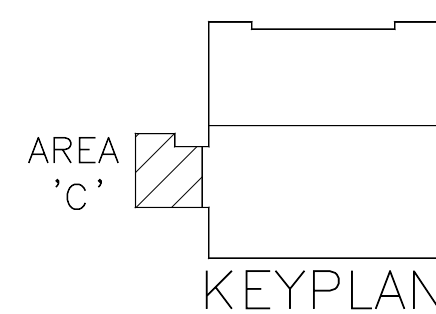

1347 Palmetto Ave., Suite 200
Charleston, SC 29405
Phone 407-544-6777
Fax 407-740-7337

Team Systems Corporation

USDA DR CH ENGR
SUPV DRZ CH ENGR
MPJ
SUBMITTED BY (FIRM MEMBER-TITLE):
TECHNICAL BRANCH
DATE: --/--/--

DRAWING REVISIONS

Rev.	Description	Prep By	Date	Appr'd.
AS-BUILT	DATE	8/14/07		

SOUTH CAROLINA

SHAW AIR FORCE BASE

DEPLOYMENT
PROCESSING CENTER

PARTIAL REFLECTED CEILING PLAN-AREA 'C'

APPROVED


DATE

EDS FOR COMMANDER, NAVFAC

Naval Facilities Engineering Command
Southern Division
Charleston, South Carolina

RECORD DRAWING DATE
05/21/04
CODE I.D. NO. 80091
DRAWING SIZE: ANSI D
SPEC. NO. 06-03-0308
CONSTRN. CONTR. NO. N62467-03-C-0308
NAVFAC DRAWING NO. 5417183
SHEET 40 OF 190

A-133

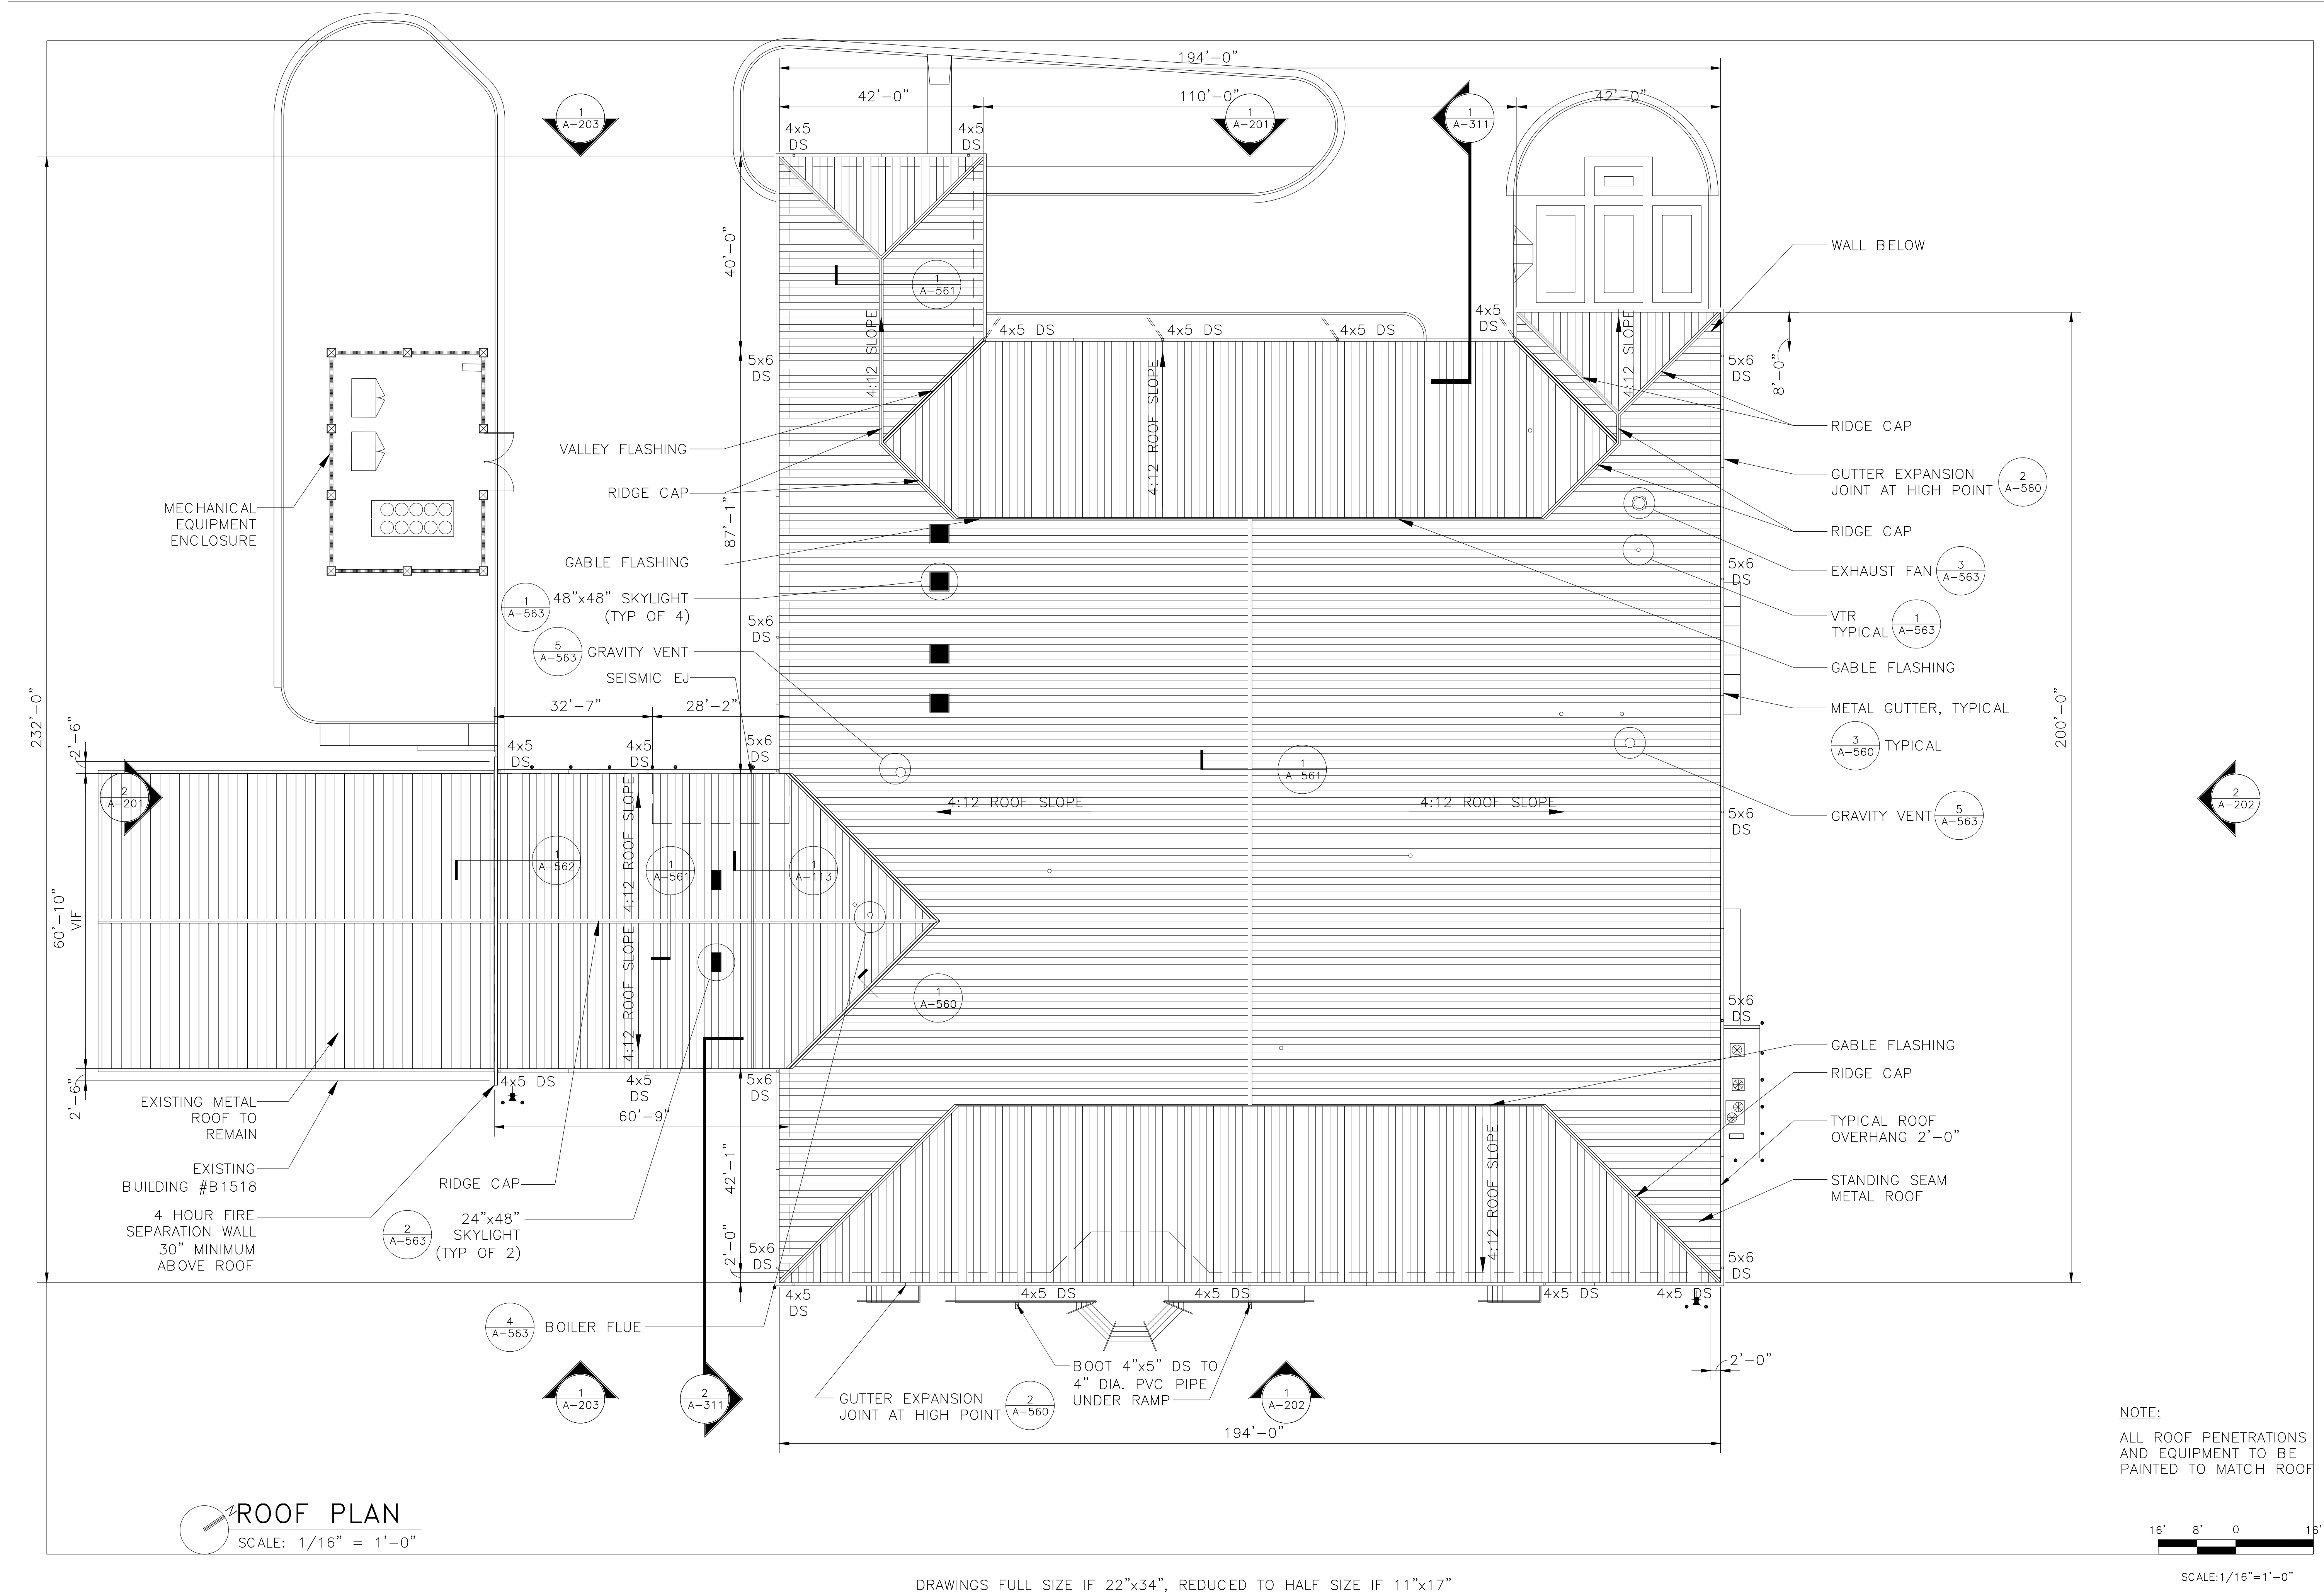

DRAWINGS FULL SIZE IF 22"x34", REDUCED TO HALF SIZE IF 11"x17"

SCALE: 1/16"=1'-0"

1347 Pinetree Ave., Suite 200
Charleston, SC 29405
Phone 407-644-6777
Fax 407-740-7337

TRANS SYSTEMS CORPORATION





USDA DR SUPV CSS CH ENGR MPJ
SUBMITTED BY (FIRM MEMBER-TITLE): PRINCIPAL
TECHNICAL BRANCH
FPE


8/14/07

DATE

APPROVED

EFD FOR COMMANDER, NAVFAC

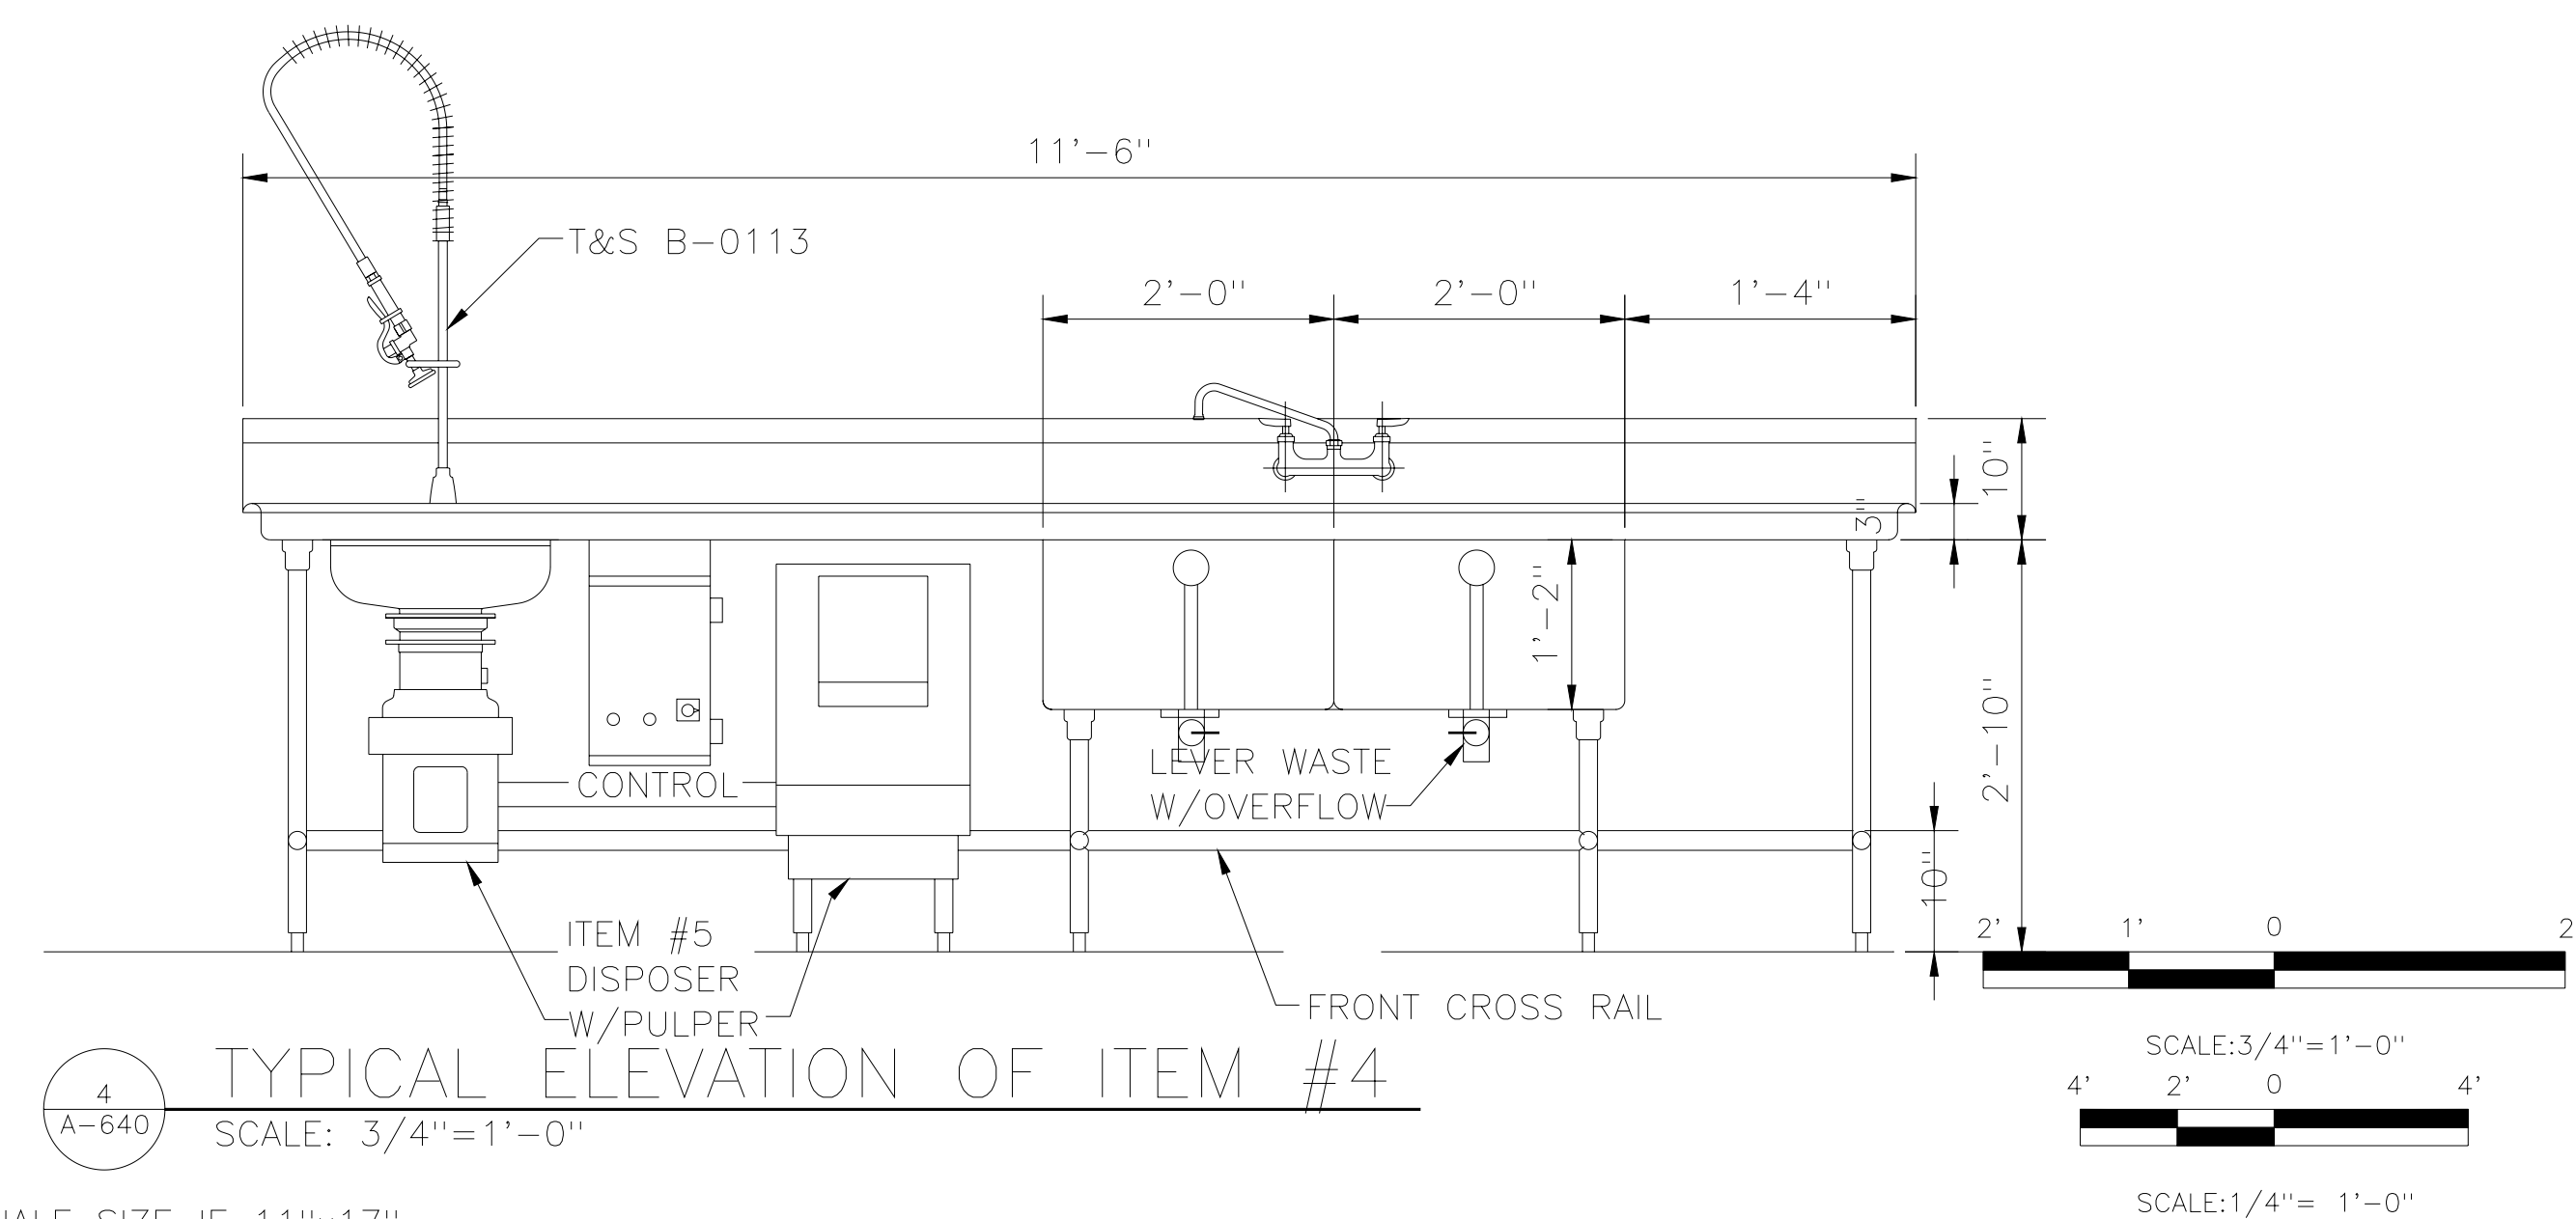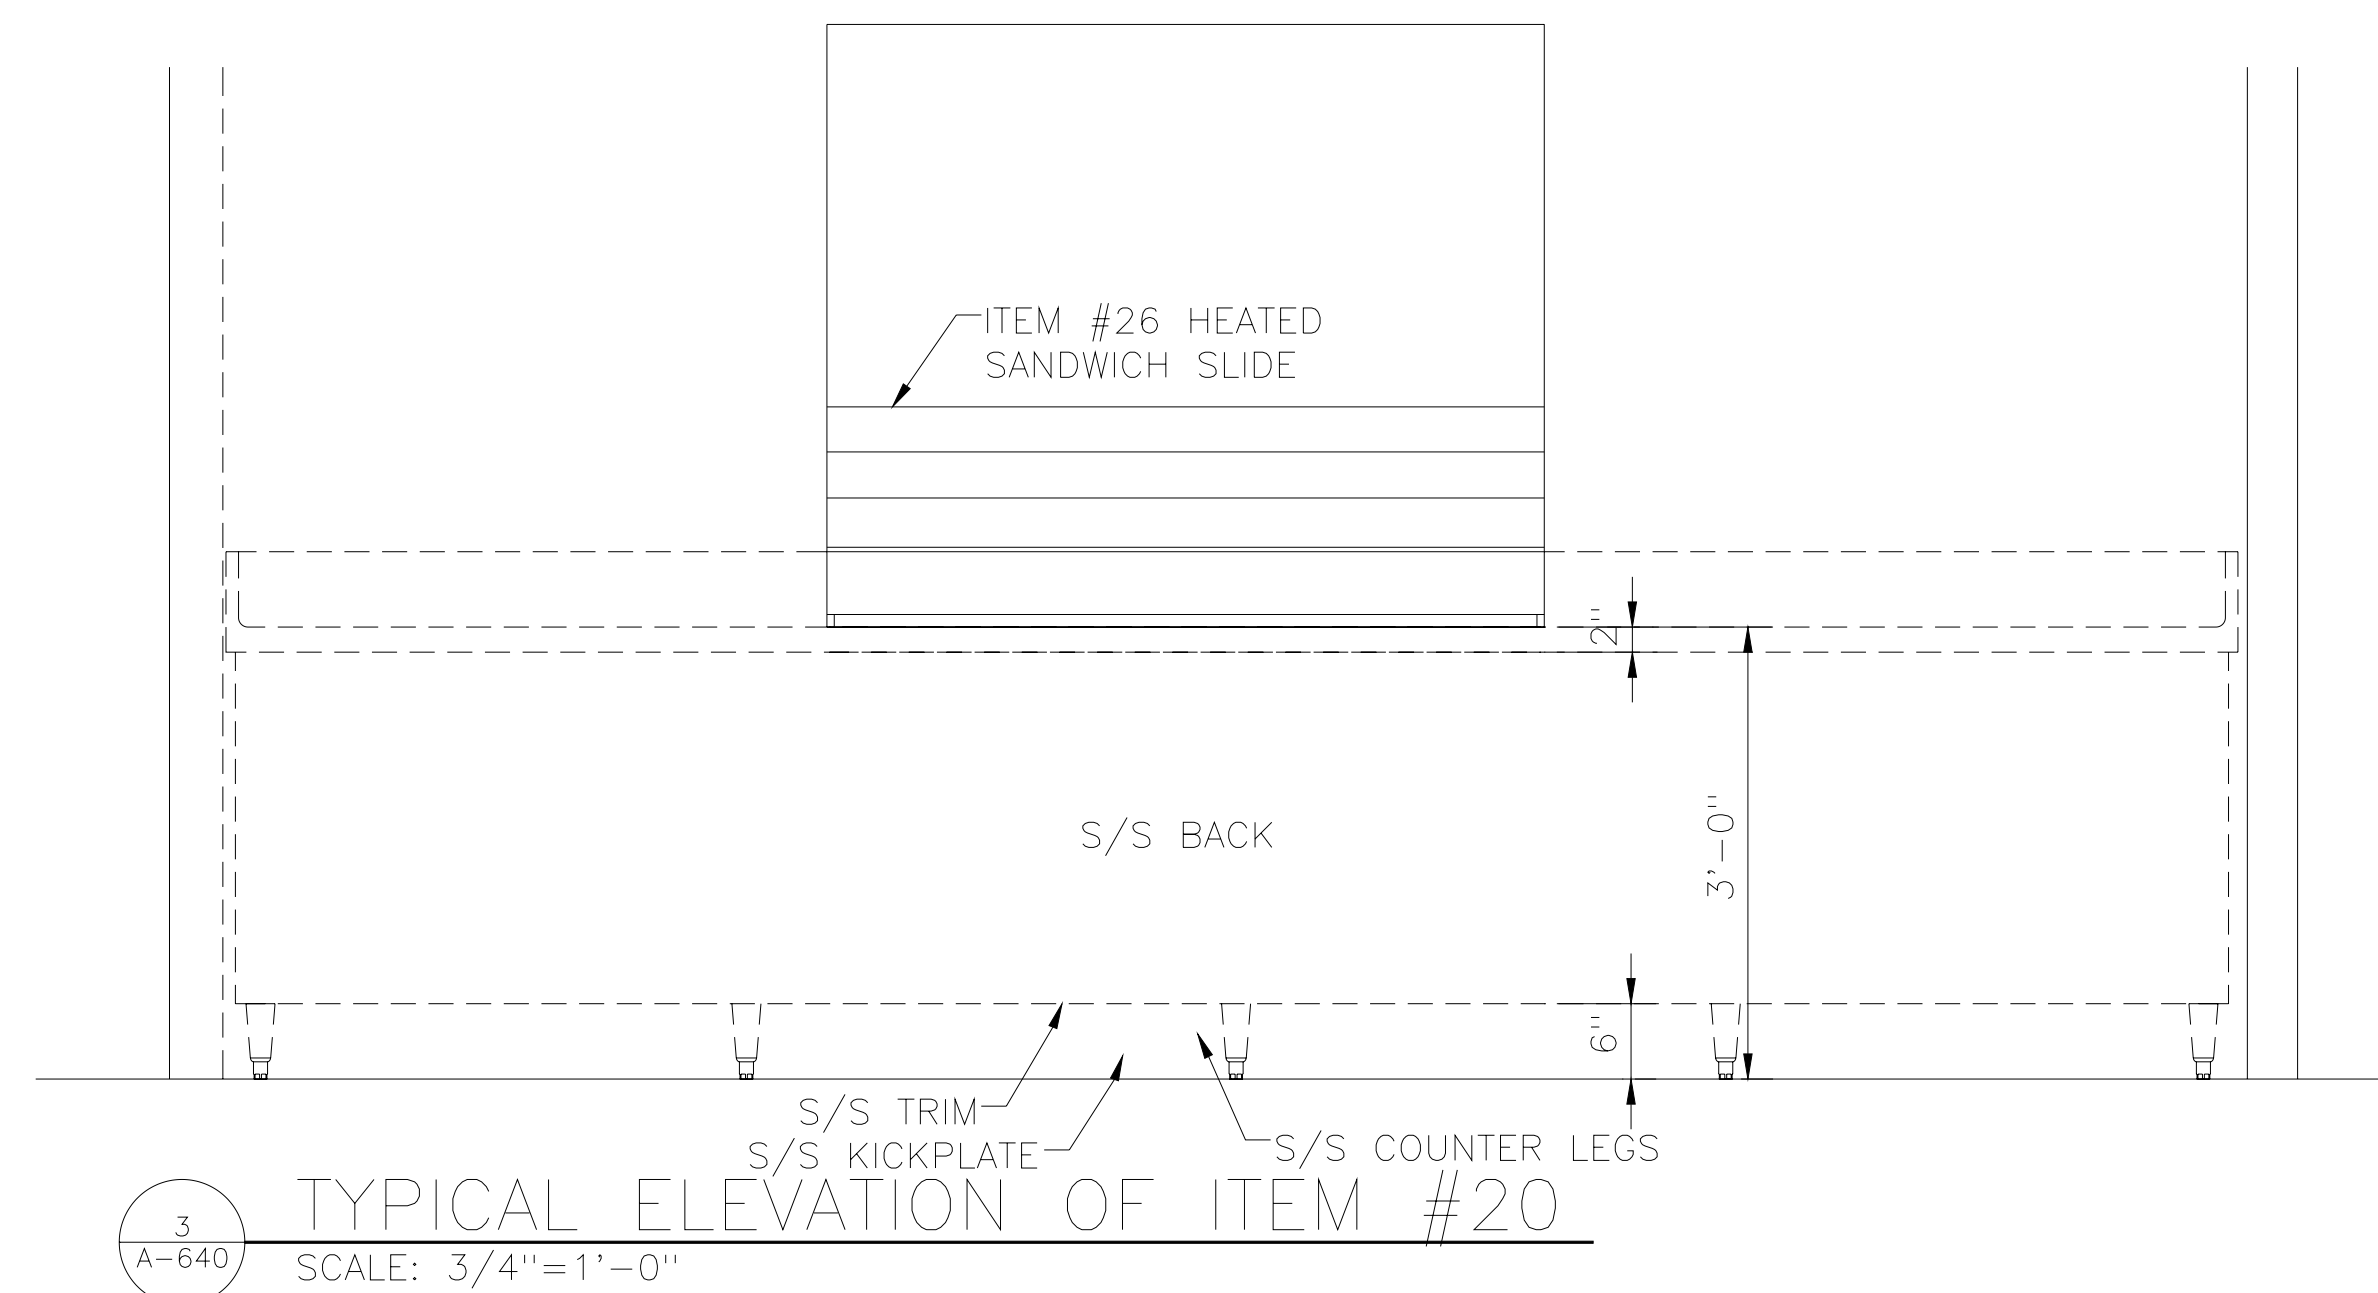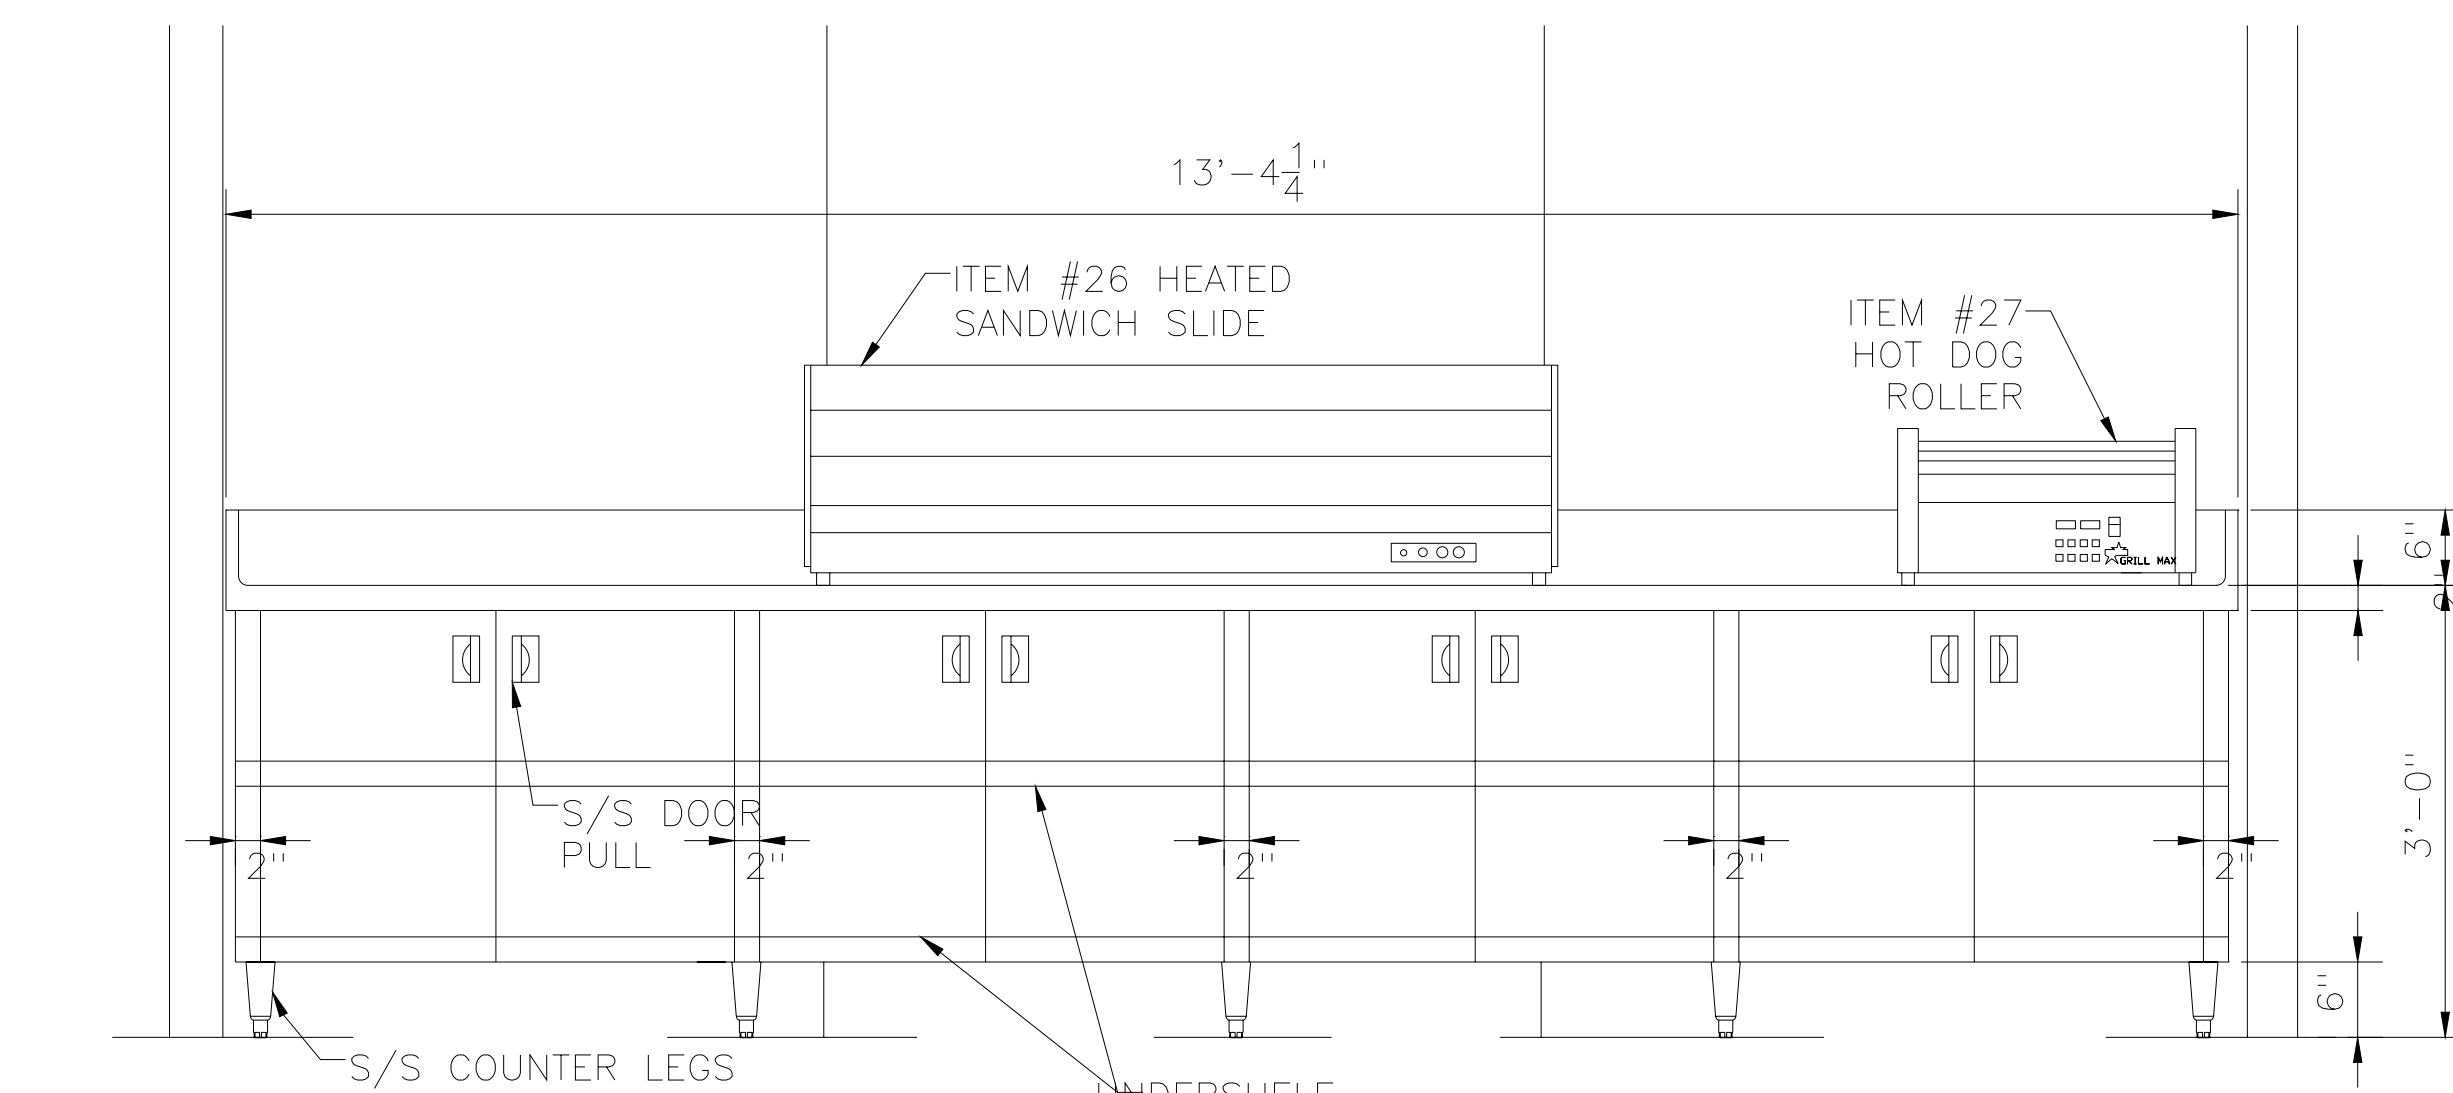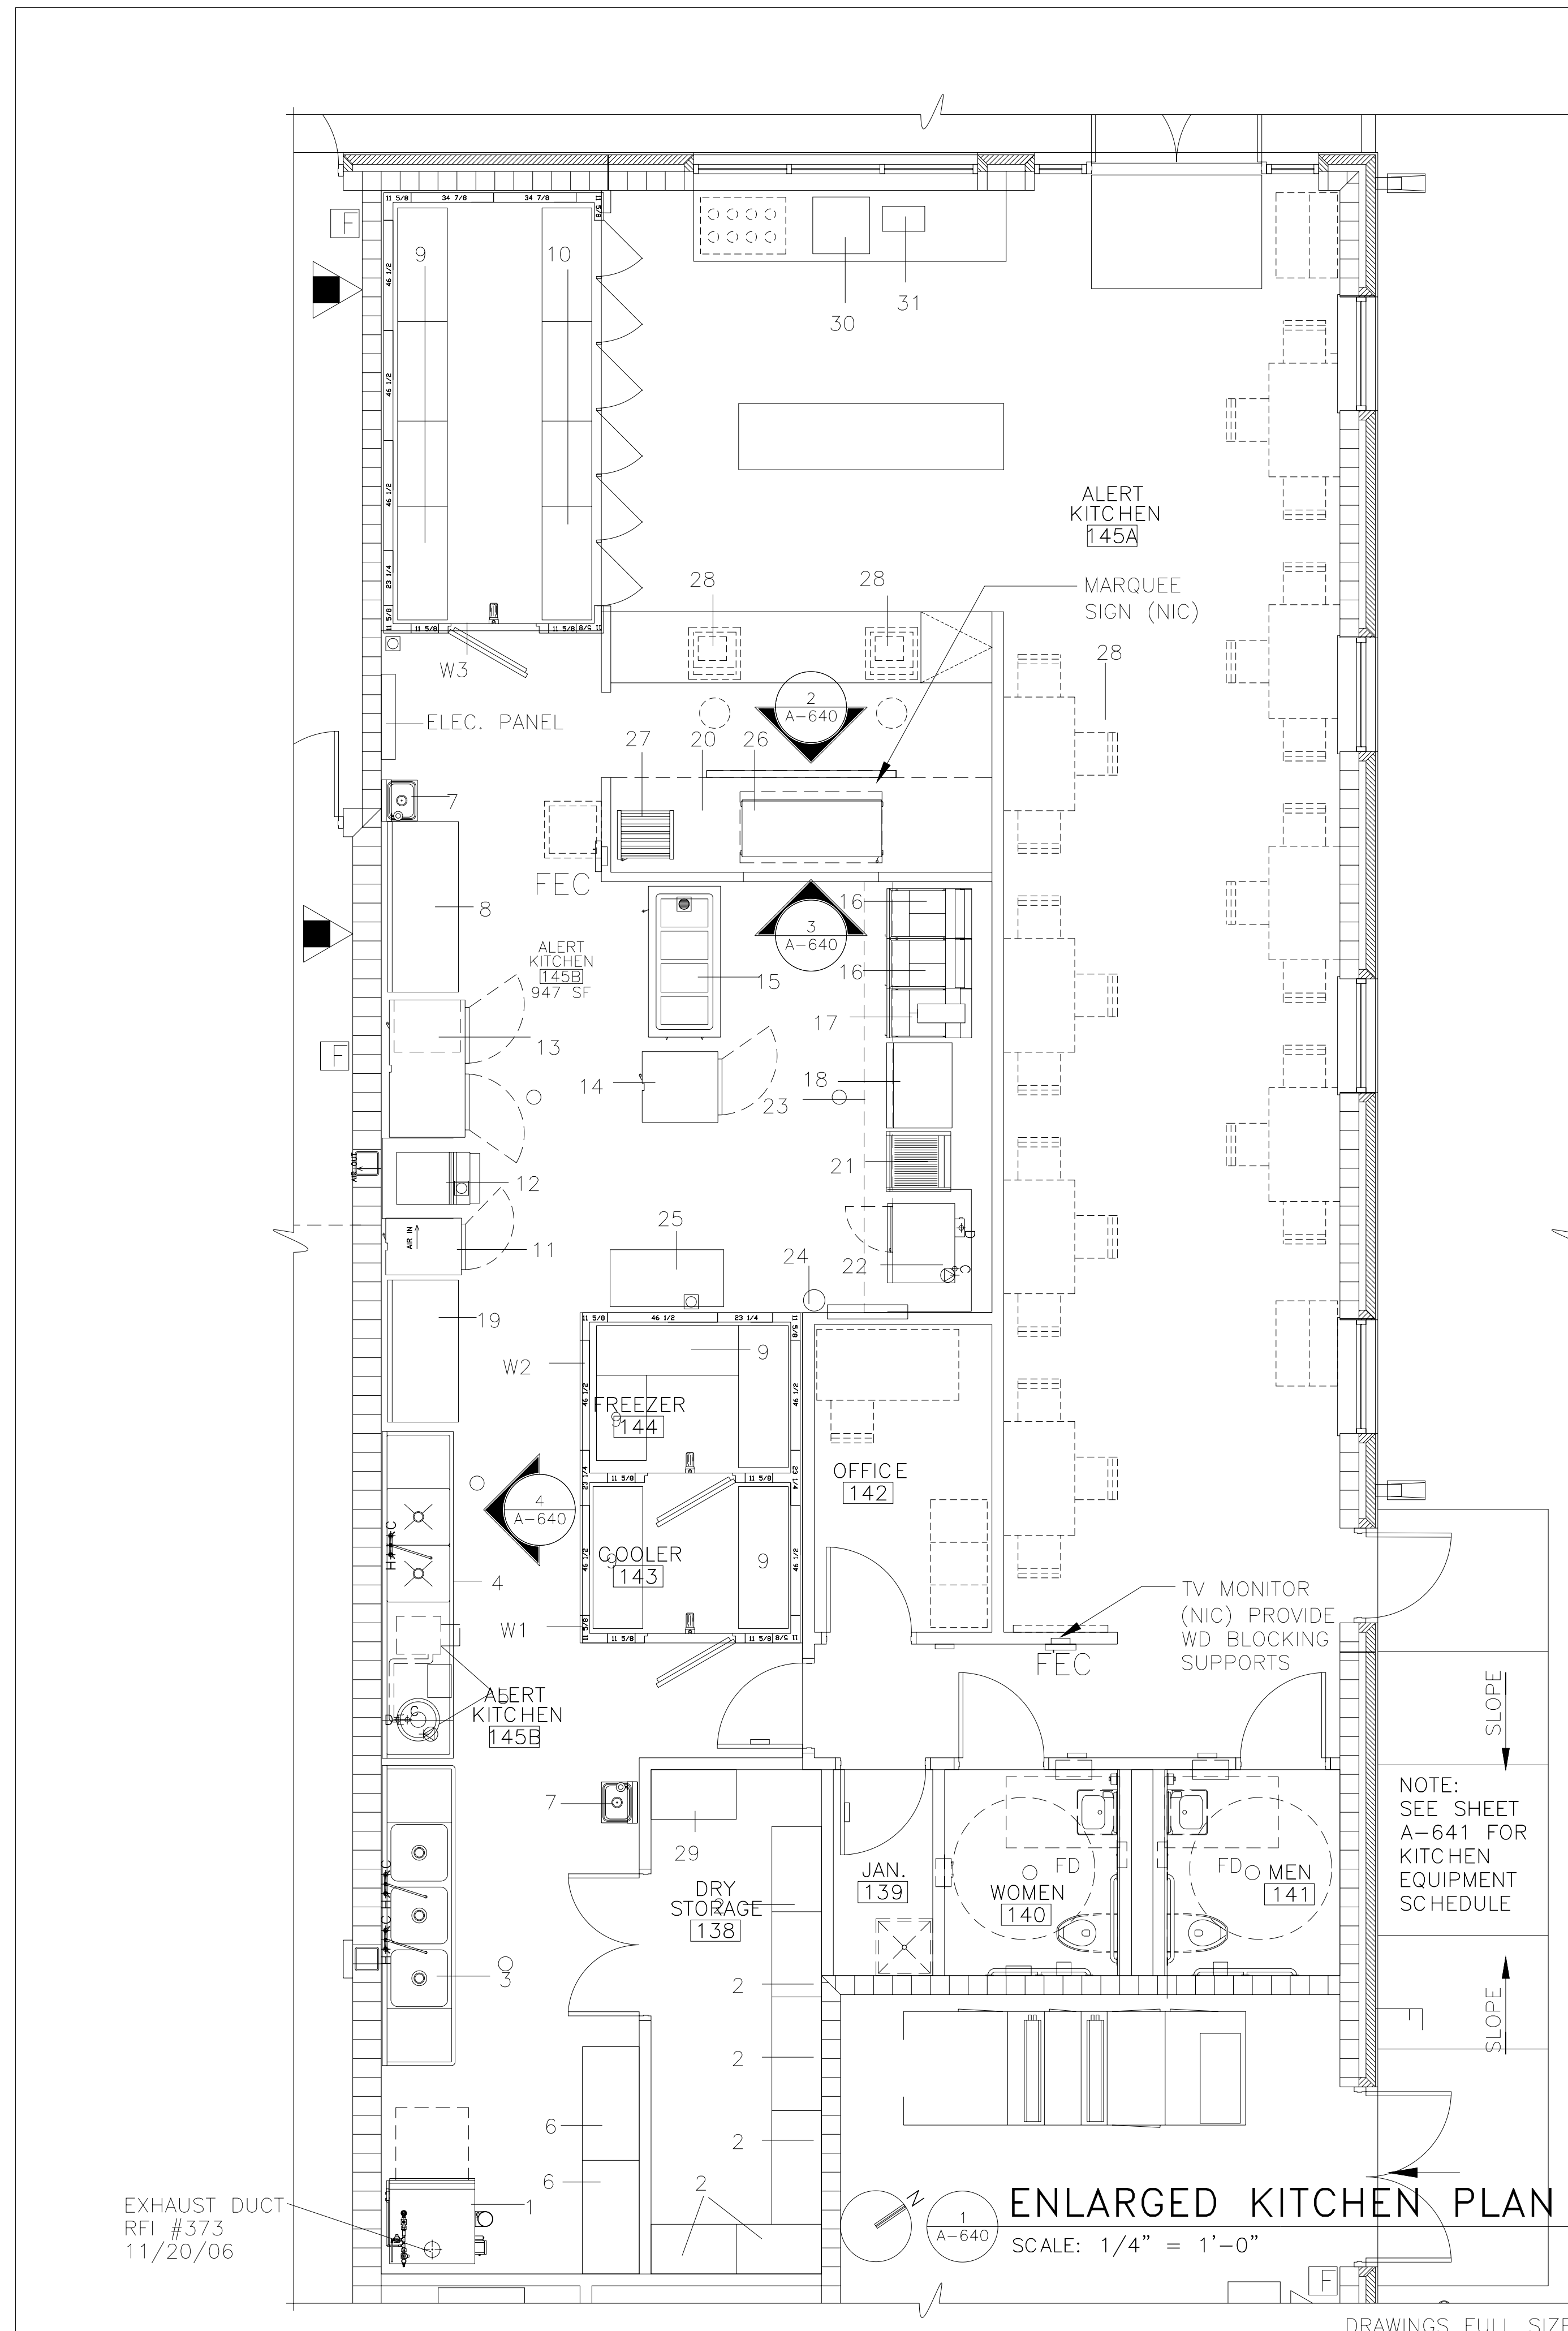


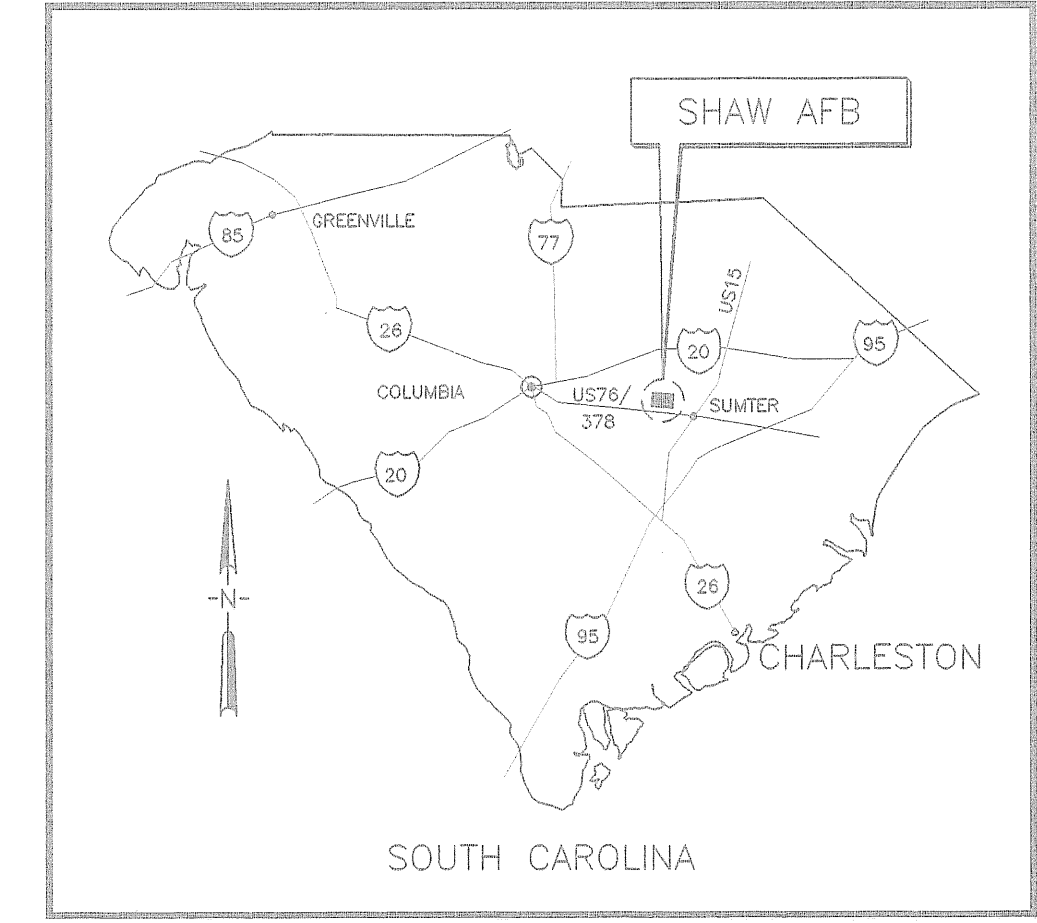

REGIONAL MAP
SCALE: NTS

SHAW AIR FORCE BASE MAP
SCALE: 1" = 1000'-0"

NOTE:
ALL WASTE MATERIAL TO BE DISPOSED OF OFF BASE BY CONTRACTOR

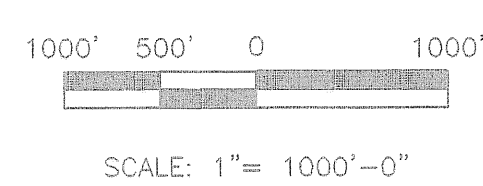

Naval Facilities Engineering Command
Southern Division
Charleston, South Carolina

STATE OF FLORIDA
DAVID R. ZANY
REGISTERED ARCHITECT
No. 16221

SHAW AIR FORCE BASE		SOUTH CAROLINA	
DEPLOYMENT PROCESSING CENTER		REGIONAL AND BASE MAPS	
APPROVED		DATE	
ETD FOR COMMANDER, NAVFAC			

DRAWING REVISIONS			
Rev.	Description	Prep By	Date
1	AS-BUILT DATE		8/14/07
2			
3			
4			
369			